



NOTE: SEE DETAIL 5 ON DWG P430 FOR MORE INFORMATION

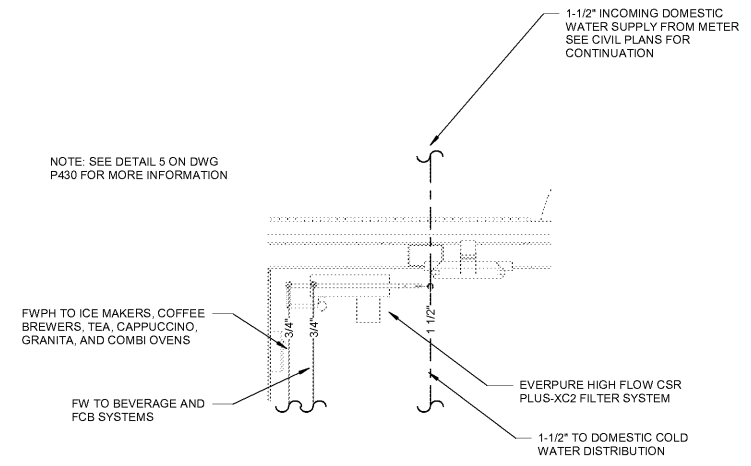

2 ENLARGED WATER PLAN
1/2" = 1'-0"

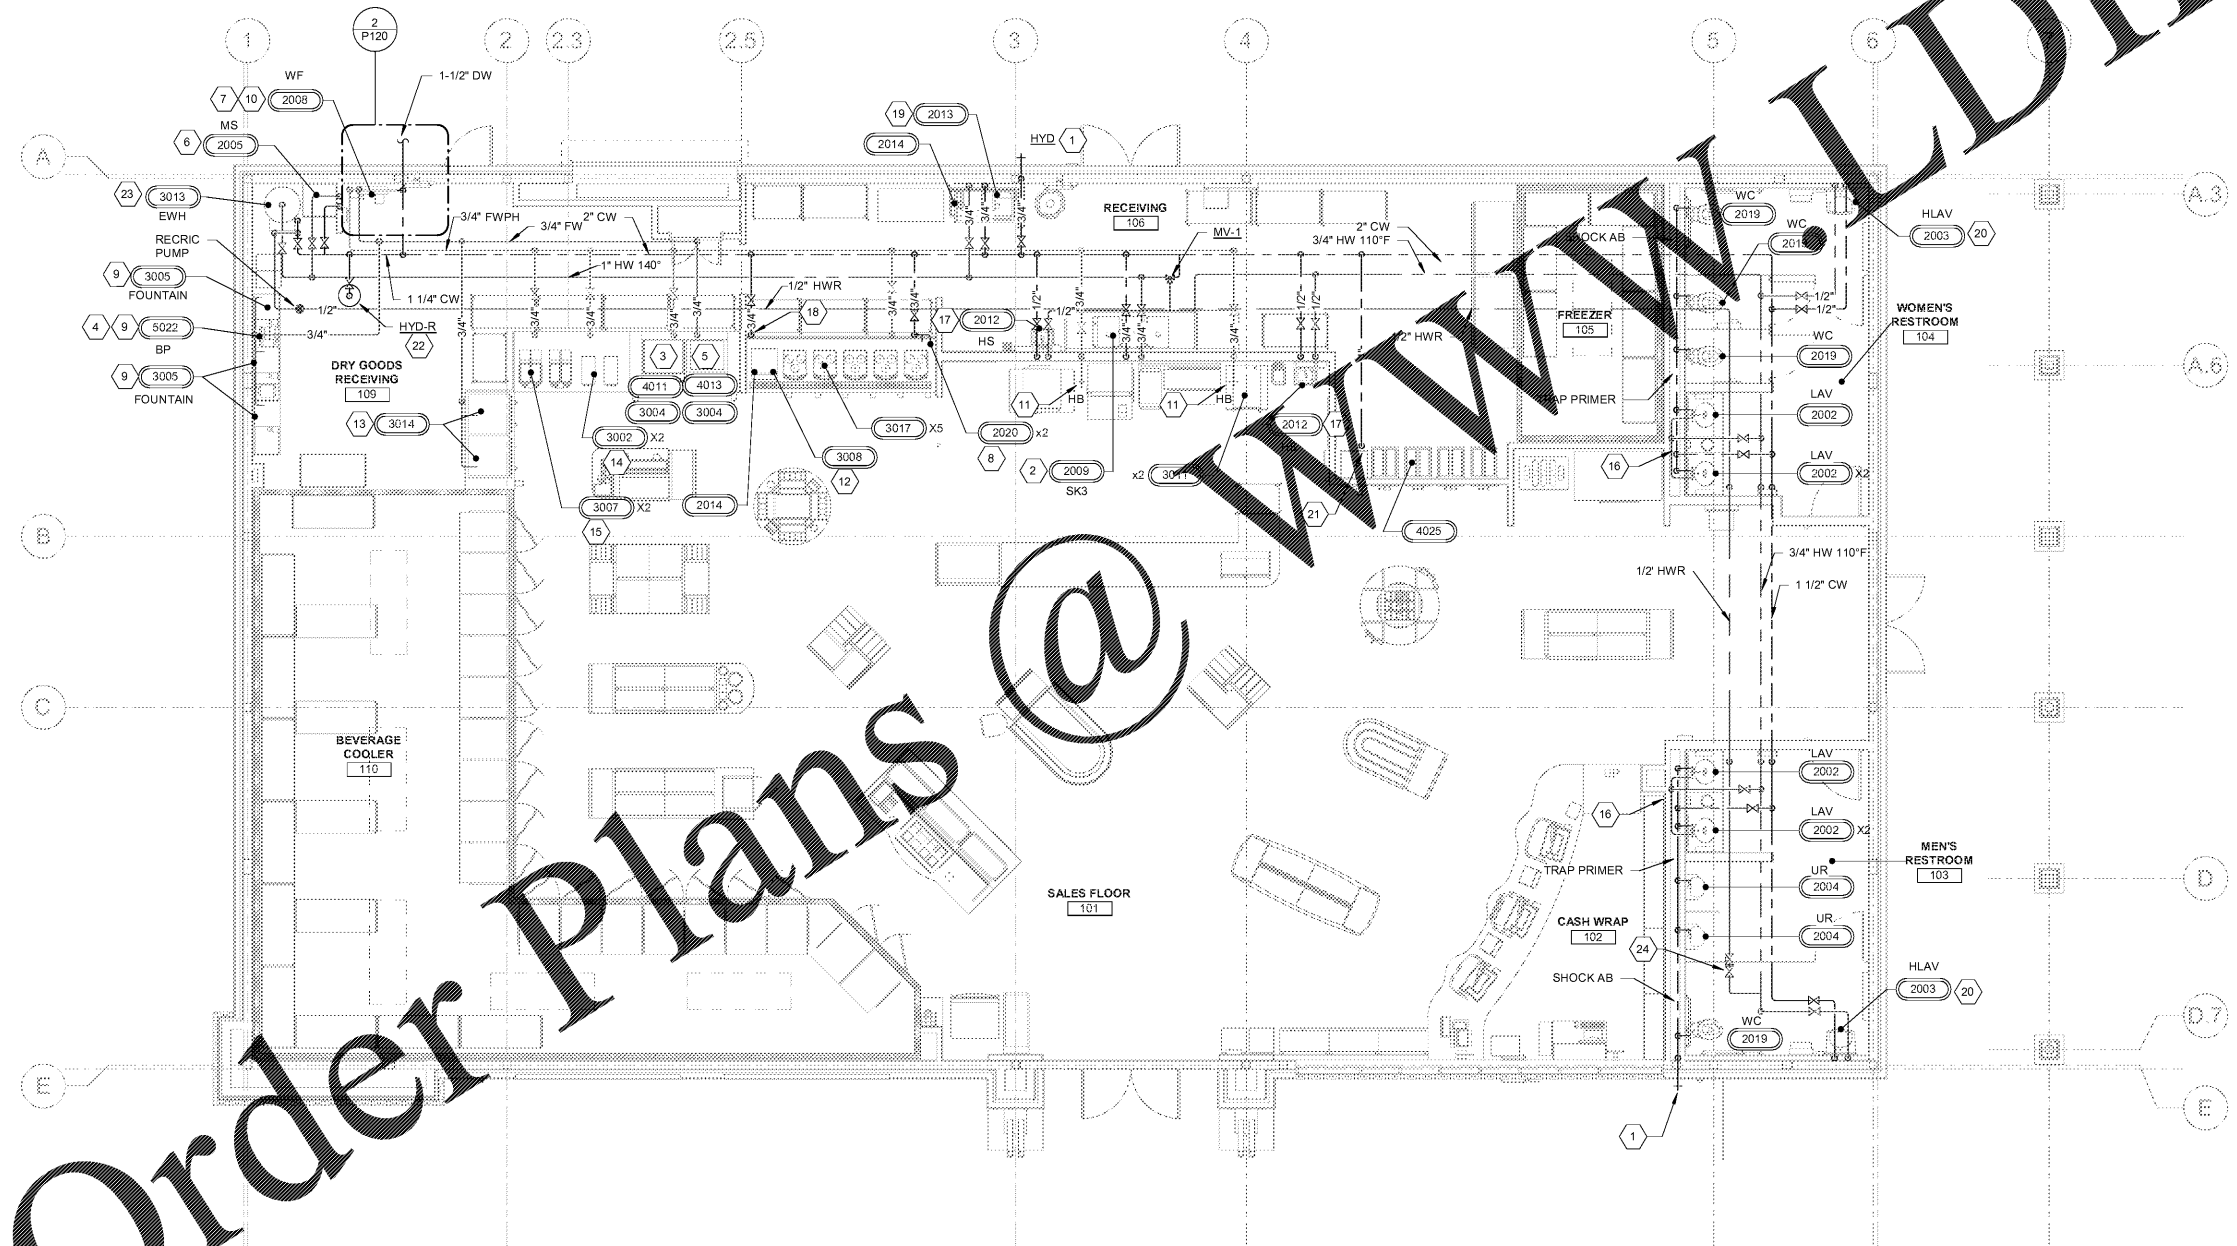

GENERAL NOTES

- REFER TO DOMESTIC WATER ISOMETRIC, SHEET P410 FOR WATER LINE PIPE SIZES.
- CONTRACTOR TO COORDINATE 2" DOMESTIC WATER SERVICE TO BUILDING WITH CIVIL/SITE CONTRACTOR. VERIFY ADEQUATE WATER PRESSURE IS AVAILABLE AT EXISTING PUBLIC WATER MAIN FOR THE BUILDING SYSTEM.
- PROVIDE WATER LINES SIZED TO MEET THE PLUMBING FIXTURES AND EQUIPMENT CONNECTION SIZES, UNLESS NOTED OTHERWISE.
- DOMESTIC WATER METERS PROPOSED TO BE IN PVC METER PITS EXTERNAL FROM THE BUILDING. LOCATE LOCATION WITH CIVIL/SITE CONTRACTOR.

RaceTrac
COPYRIGHT NOTICE
 THESE PLANS ARE SUBJECT TO FEDERAL COPYRIGHT LAWS. ANY USE OF SAME WITHOUT THE EXPRESSED WRITTEN PERMISSION OF RACETRAC PETROLEUM, INC. IS PROHIBITED. 2016 RACETRAC PETROLEUM, INC.

DESIGN PROFESSIONALS
HILLFOLEYROSSI & ASSOCIATES
 ARCHITECTURE
 ENGINEERING
 3680 Pleasant Hill Road
 Suite 200
 Duluth, Georgia 30096
 p 770.622.9858
 f 770.622.9535
 www.hillfoleyrossi.com

ISSUE/REVISION RECORD

DATE	DESCRIPTION
09/04/18	ISSUED FOR PERMIT

RaceTrac
 RACETRAC PETROLEUM, INC.
 200 GALLERIA PARKWAY SOUTHEAST
 SUITE 900
 ATLANTA, GEORGIA 30339
 (770) 431-7600

PROJECT NAME
PEACHTREE PKWY & ENG.

PROJECT LOCATION
**PEACHTREE CORNERS
 5780 PEACHTREE PKWY
 PEACHTREE CORNERS, GA**

RACETRAC STORE NUMBER
1201

PROTOTYPE SERIES 5.5K 2.0
2018 RH MO

PLAN MODIFICATION NOTICE
 SPB NO. DATE

STANDARD PLAN BULLETINS (SPB) MODIFY THE PROTOTYPE SERIES SET NOTED ABOVE. THE LISTED SPB REPRESENTS THE LATEST MODIFICATION INCORPORATED TO THIS PROTOTYPE SERIES SET AT ORIGINAL RELEASE. THE ISSUE/REVISION RECORD COLUMN ABOVE LISTS ANY REVISIONS OR SPB INCORPORATED IN THIS SET AFTER THE ORIGINAL RELEASE. CONTACT RACETRAC ENGINEERING AND CONSTRUCTION FOR ANY SUBSEQUENT BULLETINS NOT INCORPORATED HEREIN.

PROFESSIONAL SEAL

 JUSTIN B. TRACY
 09/04/18

PROJECT NUMBER
 18.703.00

SHEET TITLE
DOMESTIC WATER PLAN

SHEET NUMBER
P120
 ISSUED FOR PERMIT

Order Plans @ www.LDILine.com