


Order Plans

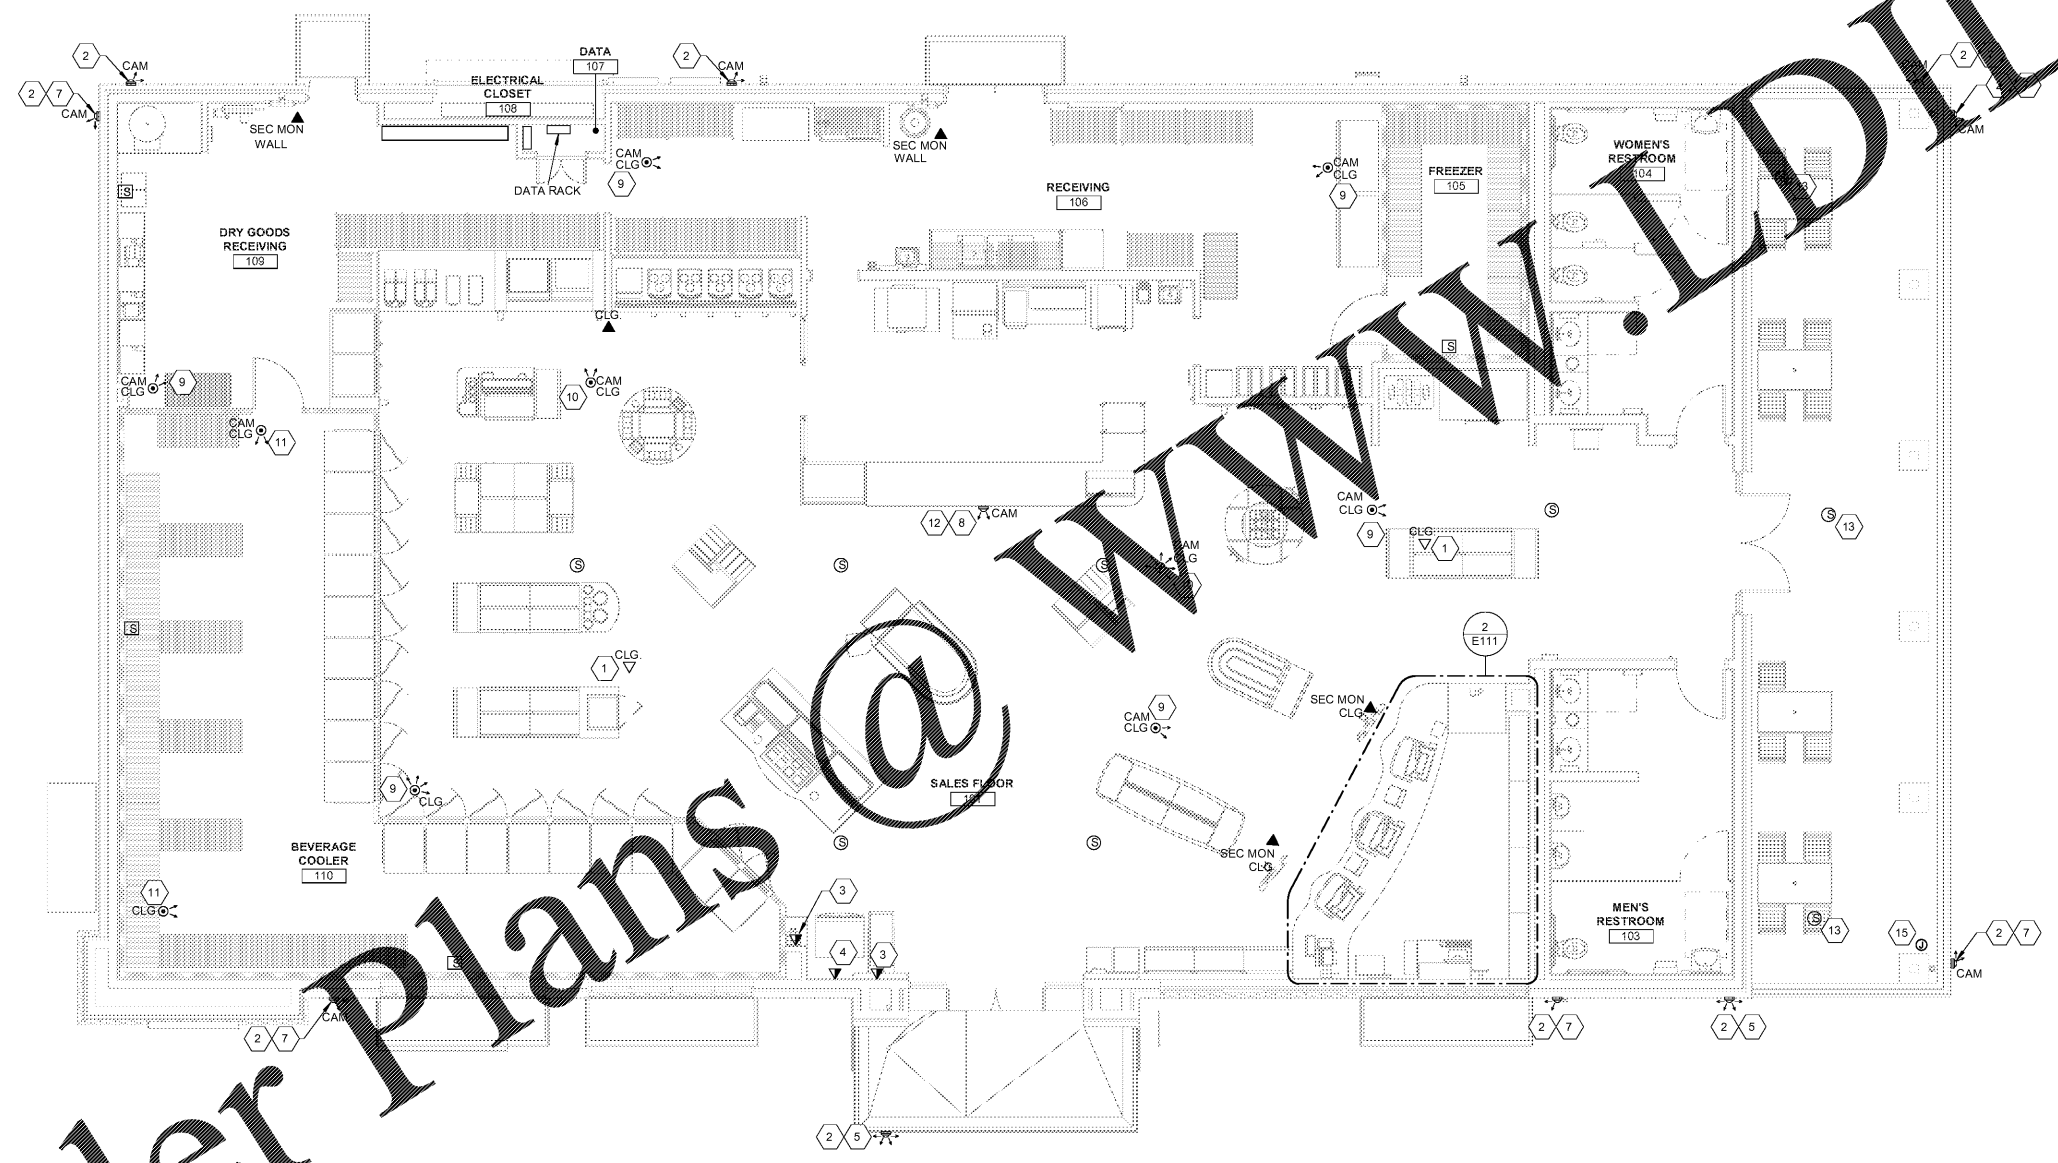

1 LOW VOLTAGE PLAN  
1/8" = 1'-0"

**GENERAL NOTES**

1. SECURITY SYSTEM, INCLUDING MONITOR, RECORDER, CAMERAS, EQUIPMENT UPS AND 500 FT. ROLL OF RG591 CABLE TO BE PROVIDED BY RACE TRAC AND INSTALLED BY THE RACE TRAC VENDOR
2. SECURITY SYSTEM AND UPS TO BE LOCATED ON SHELVING AND CONNECTED AS SHOWN ON SHEET E600.
3. ALL SECURITY SYSTEM CABLES TO BE RUN OVERHEAD IN ACCESSIBLE CEILING SPACE (BY RACETRAC VENDOR).
4. COORDINATE ALL CAMERA LOCATIONS WITH RACE TRAC BEFORE INSTALLATION.
5. ELECTRICAL CONTRACTOR SHALL FIELD VERIFY ALL EQUIPMENT CONNECTION TYPES AND PROVIDE APPROPRIATE PLUG. CONTRACTOR IS RESPONSIBLE FOR MAKING ALL FINAL CONNECTIONS TO EQUIPMENT PROVIDED BY OTHERS.
6. PROVIDE MANUFACTURER RECOMMENDED CABLING TO FUEL CANOPY SECURITY CAMERA. SEE ELECTRICAL SITE PLAN FOR LOCATION.
7. TWO CAT 5 CABLE WITH RJ-45 CONNECTORS IS TO BE PULLED FROM THE ATM TO DATA PANEL. ALL CAT 5 CABLE IS TO BE CLEARLY LABELED AT BOTH ENDS. ALL RJ-45 CONNECTORS/PLUGS TO BE AT&T TERMINATION (KEYSTONE).
8. LEVITON # 45080-256 WALL PLATE WITH THE FOLLOWING CONNECTIONS:
  - 1. TELEPHONE PHONE SERVICE
  - 2. UTILITY PHONE #106-VOICE
  - 3. VEEDER ROOT #41108-DATA (RJ-45) WIRE STRAIGHT THROUGH & TERMINATE @ DATA PANEL
  - 4. VEEDER #41108-DATA (RJ-45) WIRE STRAIGHT THROUGH & TERMINATE @ DATA PANEL

LABEL ALL CONNECTIONS AND PLUG 6TH CONNECTOR OPENING (NO HAND WRITTEN LABELS).

**SHEET KEYNOTES**

1. OUTLETS LOCATED ABOVE CEILING FOR FUTURE WIRELESS ACCESS POINT.
2. MOUNT SECURITY CAMERA AT 12'-0".
3. PROVIDE MANUFACTURER RECOMMENDED CABLING BACK TO TELECOMMUNICATIONS CLOSET. SEE ARCHITECTURAL DRAWINGS FOR MOUNTING HEIGHT.
4. PROVIDE (2) CATS LINES FROM ATM TO THE TELEPHONE BOARD/FRAME RELAY ROUTER. INSTALL RJ11 CONNECTOR ON LINE TO TELEPHONE BOARD/RJ45 CONNECTOR TO ROUTER.
5. SMP OUTDOOR-VD-5340
7. HMP-OUTDOOR FIXED-EDR4700
8. HMP-INDOOR VARIFOCAL-FD-3400
9. HMP-INDOOR FIXED-EFD4700
10. HMP-INDOOR VERIFOCAL-FD-2400
11. HMP-OUTDOOR BULLET-EBL2100
12. MOUNT CAMERA ON FACE OF SOFFIT ABOVE FOOD BAR.
13. EXTERIOR GRADE RECESSED SPEAKER.
15. L.V.E.C SHALL PROVIDE (1) SPARE 3/4" CONDUIT WITH PULL-STRING.

**RaceTrac**  
COPYRIGHT NOTICES  
 THESE PLANS ARE SUBJECT TO FEDERAL COPYRIGHT LAWS. ANY USE OF SAME WITHOUT THE EXPRESSED WRITTEN PERMISSION OF RACETRAC PETROLEUM, INC. IS PROHIBITED. 2016 RACETRAC PETROLEUM INC.

**HILLFOLEYROSSI & ASSOCIATES**  
 ARCHITECTURE  
 ENGINEERING  
 3680 Pleasant Hill Road  
 Suite 200  
 Duluth, Georgia 30096  
 p 770.622.9858  
 f 770.622.9535  
 www.hillfoleyrossi.com

**ISSUE/REVISION RECORD**

DATE	DESCRIPTION
09/04/18	ISSUED FOR PERMIT

**RaceTrac**  
 RACETRAC PETROLEUM, INC.  
 200 GALLERIA PARKWAY SOUTHEAST  
 SUITE 900  
 ATLANTA, GEORGIA 30339  
 (770) 431-7600

**PROJECT NAME**  
**PEACHTREE PKWY & ENG.**


**PEACHTREE CORNERS**  
**5780 PEACHTREE PKWY**  
**PEACHTREE CORNERS, GA**  
**RACETRAC STORE NUMBER**  
**1201**

**PROTOTYPE SERIES 5.5K 2.0**  
**2018 RH MO**

**PLAN MODIFICATION NOTICE**

SPB NO.	DATE

STANDARD PLAN BULLETINS (SPB) MODIFY THE PROTOTYPE SERIES SET NOTED ABOVE. THE LISTED SPB REPRESENTS THE LATEST MODIFICATION INCORPORATED TO THIS PROTOTYPE SERIES SET AT ORIGINAL RELEASE. THE ISSUE/REVISION RECORD COLUMN ABOVE LISTS ANY REVISIONS OR SPB INCORPORATED IN THIS SET AFTER THE ORIGINAL RELEASE. CONTACT RACETRAC ENGINEERING AND CONSTRUCTION FOR ANY SUBSEQUENT BULLETINS NOT INCORPORATED HEREIN.

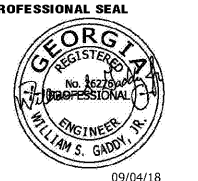

09/04/18  
**PROJECT NUMBER**  
 18.703.00  
**SHEET TITLE**  
**LOW VOLTAGE PLAN**

**SHEET NUMBER**  
**E120**  
 ISSUED FOR PERMIT