

PLOT DATE:  
October 22, 2018

Revision Schedule		
Revision Number	Revision Description	Revision Date

STORE NUMBER  
1692  
Liberty Station

Liberty Pkwy and the Proposed  
Eastern Roadway  
Vestavia Hills  
Jefferson Co., AL


48.10  
1/8/2018  
SIENNA LITE

SLAB PLAN

As Indicated

S1.2


PERMIT SET DATE 10/01/2018 1:55:42 PM

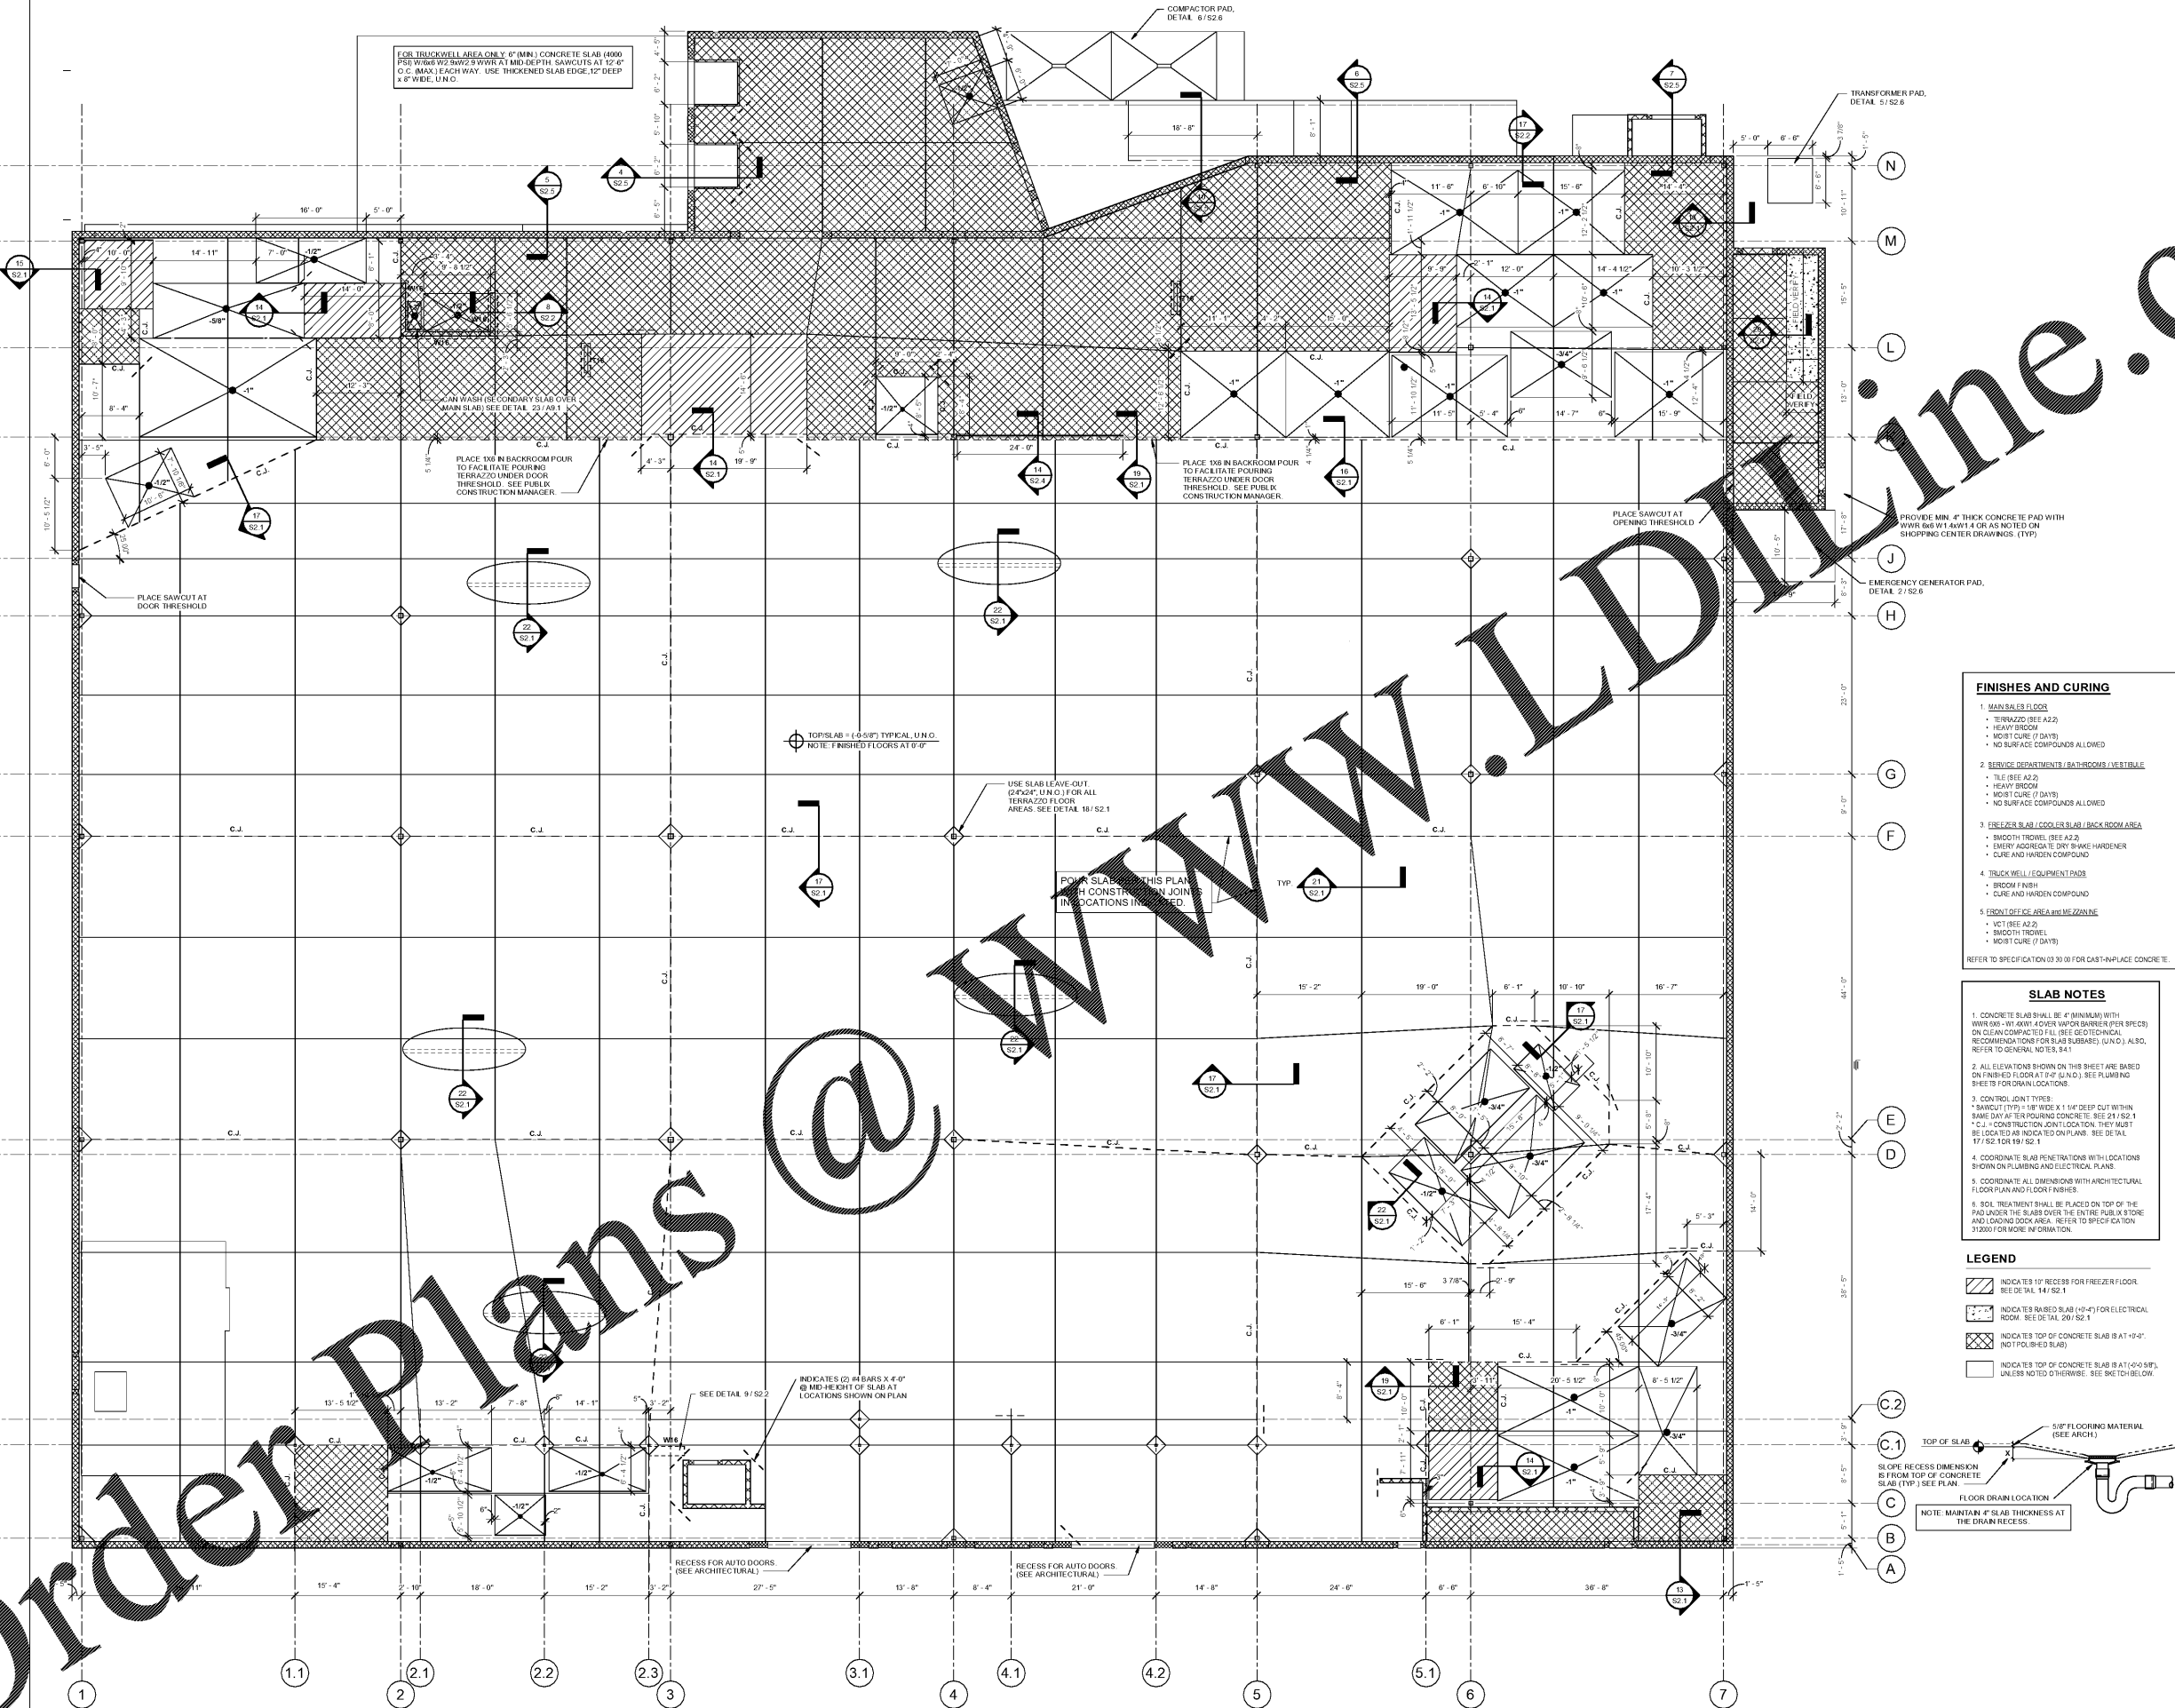

- FINISHES AND CURING**
- MAIN SLAB FLOOR**
    - TERRAZZO (SEE A2.2)
    - HEAVY BRCCM
    - MOIST CURE (7 DAYS)
    - NO SURFACE COMPOUNDS ALLOWED
  - SERVICE DEPARTMENTS / BATHROOMS / VESTIBULE**
    - TILE (SEE A2.2)
    - HEAVY BRCCM
    - MOIST CURE (7 DAYS)
    - NO SURFACE COMPOUNDS ALLOWED
  - FREEZER SLAB / COOLER SLAB / BACK ROOM AREA**
    - SMOOTH TROWEL (SEE A2.2)
    - EMERY AGGREGATE DRY BRAKE HARDENER
    - CURE AND HARDEN COMPOUND
  - TRUCK WELLS / EQUIPMENT PAD**
    - BROOF FINISH
    - CURE AND HARDEN COMPOUND
  - FRONT OFFICE AREA AND MEZZANINE**
    - VCT (SEE A2.2)
    - SMOOTH TROWEL
    - MOIST CURE (7 DAYS)
- REFER TO SPECIFICATION 03 30 00 FOR CAST-IN-PLACE CONCRETE

- SLAB NOTES**
- CONCRETE SLAB SHALL BE 4" (MINIMUM) WITH WWR (MIN. W/ 400) 4 COVER VAPOR BARRIER (PER SPECS) ON CLEAR COMPACTED FILL (PER GEOTECHNICAL RECOMMENDATIONS FOR SLAB SUBBASE) (U.N.C.). ALSO, REFER TO GENERAL NOTES 8 & 11.
  - ALL ELEVATIONS SHOWN ON THIS SHEET ARE BASED ON FINISHED FLOOR AT 0'-0" (U.N.C.). SEE PLUMBING SHEETS FOR DRAIN LOCATIONS.
  - CONTROL JOINT TYPES:
    - SAWCUT (TYP.) 1" W/ 1/2" X 1" DEEP CUT WITH SAME DAY AF TER POURING CONCRETE. SEE 21 / S2.1
    - C.J. = CONSTRUCTION JOINT LOCATION. THEY MUST BE LOCATED AS INDICATED ON PLANS. SEE DETAIL 17 / S2.1 OR 19 / S2.1
  - COORDINATE SLAB PENETRATIONS WITH LOCATIONS SHOWN ON PLUMBING AND ELECTRICAL PLANS.
  - COORDINATE ALL DIMENSIONS WITH ARCHITECTURAL FLOOR PLAN AND FLOOR FINISHES.
  - S.O.D. TREATMENT SHALL BE PLACED ON TOP OF THE PAD UNDER THE SLAB OVER THE ENTIRE PUBLIX STORE AND LOADING DOCK AREA. REFER TO SPECIFICATION 312000 FOR MORE INFORMATION.

- LEGEND**
- INDICATES 1" RECESS FOR FREEZER FLOOR. SEE DETAIL 14 / S2.1
  - INDICATES 8" RECESSED SLAB (8'-4") FOR ELECTRICAL ROOM. SEE DETAIL 20 / S2.1
  - INDICATES TOP OF CONCRETE SLAB AT +0'-0" (NOT FOR RECESSED SLAB)
  - INDICATES TOP OF CONCRETE SLAB AT +0'-0" UNLESS NOTED OTHERWISE. SEE SKECH BELOW.

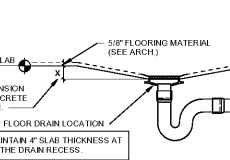

1 SLAB PLAN  
SCALE: 1/8" = 1'-0"

Order Plans @ WWW.LDOnline.com