








LEGEND RCP

-  SUSP. ACOUST. TILE CLG. 2x2 GRID 4 TILE
-  GYPSUM BOARD CEILING
-  CEILING HEIGHT
-  2x4 LIGHT FIXTURE PER SPECS
-  SUPPLY REGISTER

NOTE: ALL EXISTING CONDITIONS SHOULD BE FIELD VERIFIED

1. PROTECT ALL EXISTING STRUCTURE IN AREA WHERE WORK IS TO BE DONE.
2. ALL ITEMS, MATERIALS, SURFACES OR OTHERWISE WHICH ARE DAMAGED SHALL BE MADE WHOLE & REPAIRED TO ORIGINAL CONDITION UNLESS NOTED OTHERWISE.
3. ALL CEILING TILES AND GRIDS IN CORRIDORS ARE TO BE REMOVED FOR HVAC REPLACEMENT. NEW GRID AND TILES SHALL BE INSTALLED AT THEIR ORIGINAL HEIGHT AND LOCATIONS.
4. ALL LIGHTING, SPEAKERS, SECURITY CAMERAS, OTHER CEILING MOUNTED EQUIPMENT IS TO BE STORED AND RE-INSTALLED IN ORIGINAL LOCATION IN NEW CEILING GRID.
5. SEE MECHANICAL DRAWINGS FOR ALL HVAC SUPPLY AND RETURNS OR FOR EQUIPMENT THAT WILL BE INSTALLED IN CEILING.

COPYRIGHT OWNERSHIP:
This drawing is the property of Foreman Seeley Fountain Architecture and may not be used, copied or reprinted without expressed written permission.

© 2018

Revisions:

No.	Description

**HVAC AND ROOFING RENOVATIONS FOR
BRITT ELEMENTARY SCHOOL**

2503 SKYLAND DRIVE SW
SNELLVILLE, GEORGIA 30078

Facility Code
3050

FOREMAN | SEELEY | FOUNTAIN
architecture

3001 Government Lake Drive, Suite 150, Peachtree Corners, Georgia 30071
(770) 729-8433 www.FSArchitecture.com Fax (770) 729-8446


Sheet Title:
REFLECTED CEILING PLAN

Drawn By: DBM
Scale: AS NOTED
Date: 12/14/2018
Job No.: 1810
Sheet No.:

A3.1

FOR PRICING

1 REFLECTED CEILING PLAN
SCALE: 1/16"=1'-0"

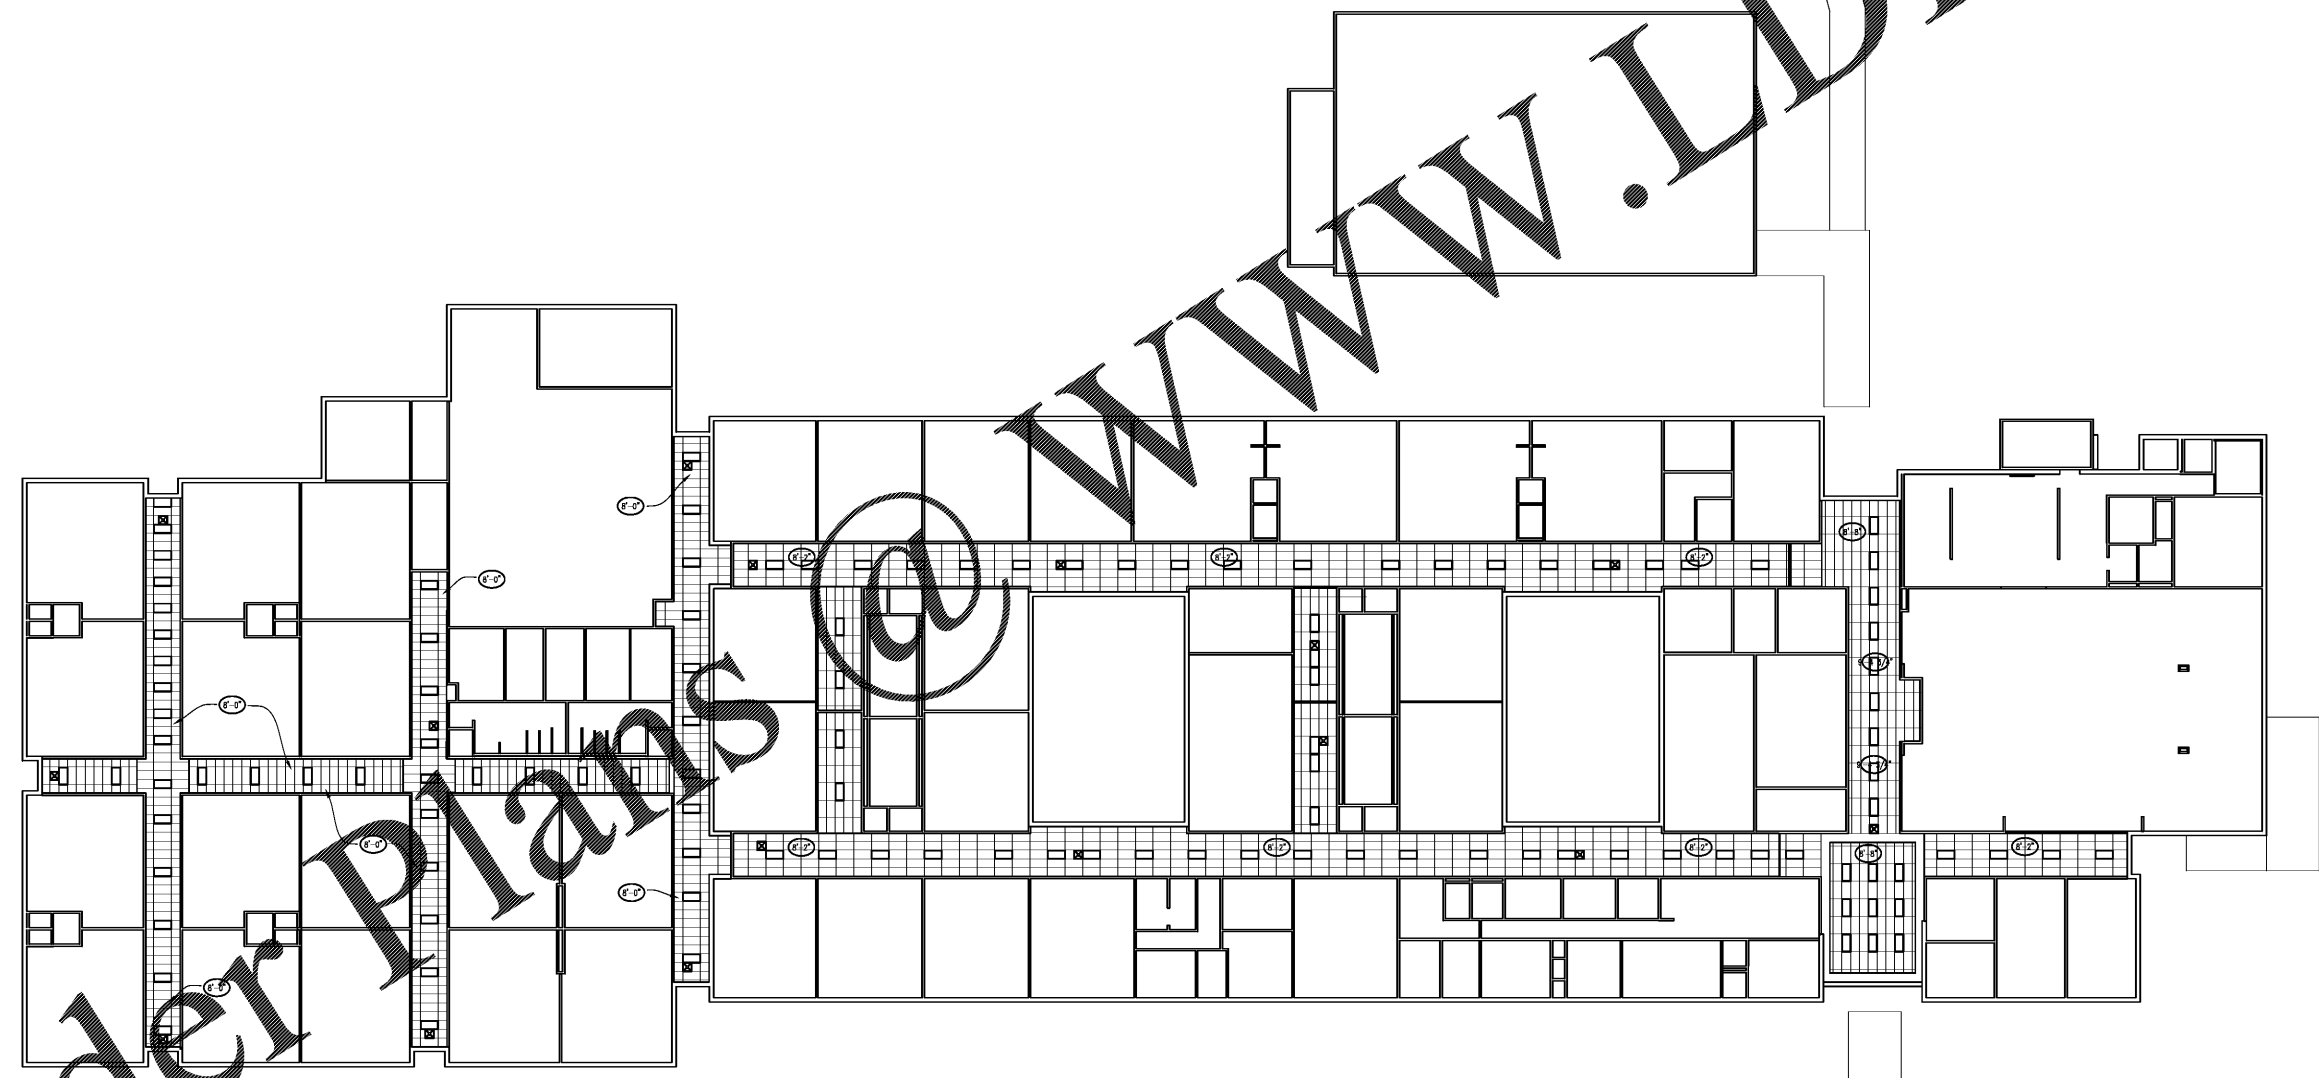

Order Plans @