



COPYRIGHT OWNERSHIP
This drawing is the property of Foreman Seeley Fountain Architecture and may not be used, copied or revised without expressed written permission. © 2018

Revisions:

HVAC AND ROOFING RENOVATIONS FOR
BRITT ELEMENTARY SCHOOL

2503 SKYLAND DRIVE SW
SNELLVILLE, GEORGIA 30078

Facility Code
3050

FOREMAN | SEELEY | FOUNTAIN
architecture

3001 Governors Lake Drive, Suite 150, Peachtree Corners, Georgia 30071
(770) 724-8433 www.seeleyfountain.com (770) 724-8468

Sheet Title:
CLASSROOM BUILDING -
HVAC ROOF PLANS

Drawn By: GBP
Scale: AS NOTED
Date: 12/14/2018
Job No.: 18JS97
Sheet No.:

M2.5

GENERAL NOTES


1. SEE M0.1 FOR HVAC GENERAL NOTES.

KEY NOTES (DEMOLITION)


- ① REMOVE EXISTING ENERGY RECOVERY VENTILATOR, CAP/SEAL REMAINING ROOF PENETRATIONS PER ARCHITECTURAL DETAILS.
- ② REMOVE EXISTING GRAVITY RELIEF AIR VENTILATOR, SEAL REMAINING ROOF PENETRATION/CURB PER ARCHITECTURAL DETAILS.
- ③ REMOVE EXISTING ROOF INTAKE HOOD ASSOCIATED WITH SUPPLY AIR FANS, CAP/SEAL REMAINING ROOF PENETRATIONS PER ARCHITECTURAL DETAILS.
- ④ REMOVE EXISTING EXHAUST FANS FOR INSTALLATION OF NEW UNIT.
- ⑤ REMOVE ABANDONED MAKE-UP SUPPLY FAN AND ASSOCIATED DUCTWORK, CAP/SEAL REMAINING ROOF PENETRATIONS PER ARCHITECTURAL DETAILS.
- ⑥ SEAL/CAP BOILER FLUE STACK.
- ⑦ REMOVE EXISTING RELIEF AIR HOOD, CAP/SEAL REMAINING ROOF PENETRATION PER ARCHITECTURAL DETAILS.

KEY NOTES (NEW WORK)

- ① NEW DOAS UNIT ON ROOF PER SCHEDULE, PROVIDE NEW ROOF CURB AND DUCT OPENINGS AS REQUIRED, COORDINATE LOCATION OF NEW OPENINGS WITH EXISTING ROOF STRUCTURE, FIELD VERIFY ROUTING ON DUCTWORK.
- ② NEW ROOFTOP UNIT TO REPLACE EXISTING, PROVIDE NEW ROOF CURB AND REUSE EXISTING OPENING.
- ③ NEW EXHAUST FAN, PROVIDE ROOF CURB ADAPTER AS REQUIRED, CONNECT FAN TO NEW EXHAUST DUCT.
- ④ ALL EXISTING EQUIPMENT AND ASSOCIATED DUCTWORK TO REMAIN UNLESS OTHERWISE NOTED.
- ⑤ NEW EXHAUST FAN TO REPLACE EXISTING.

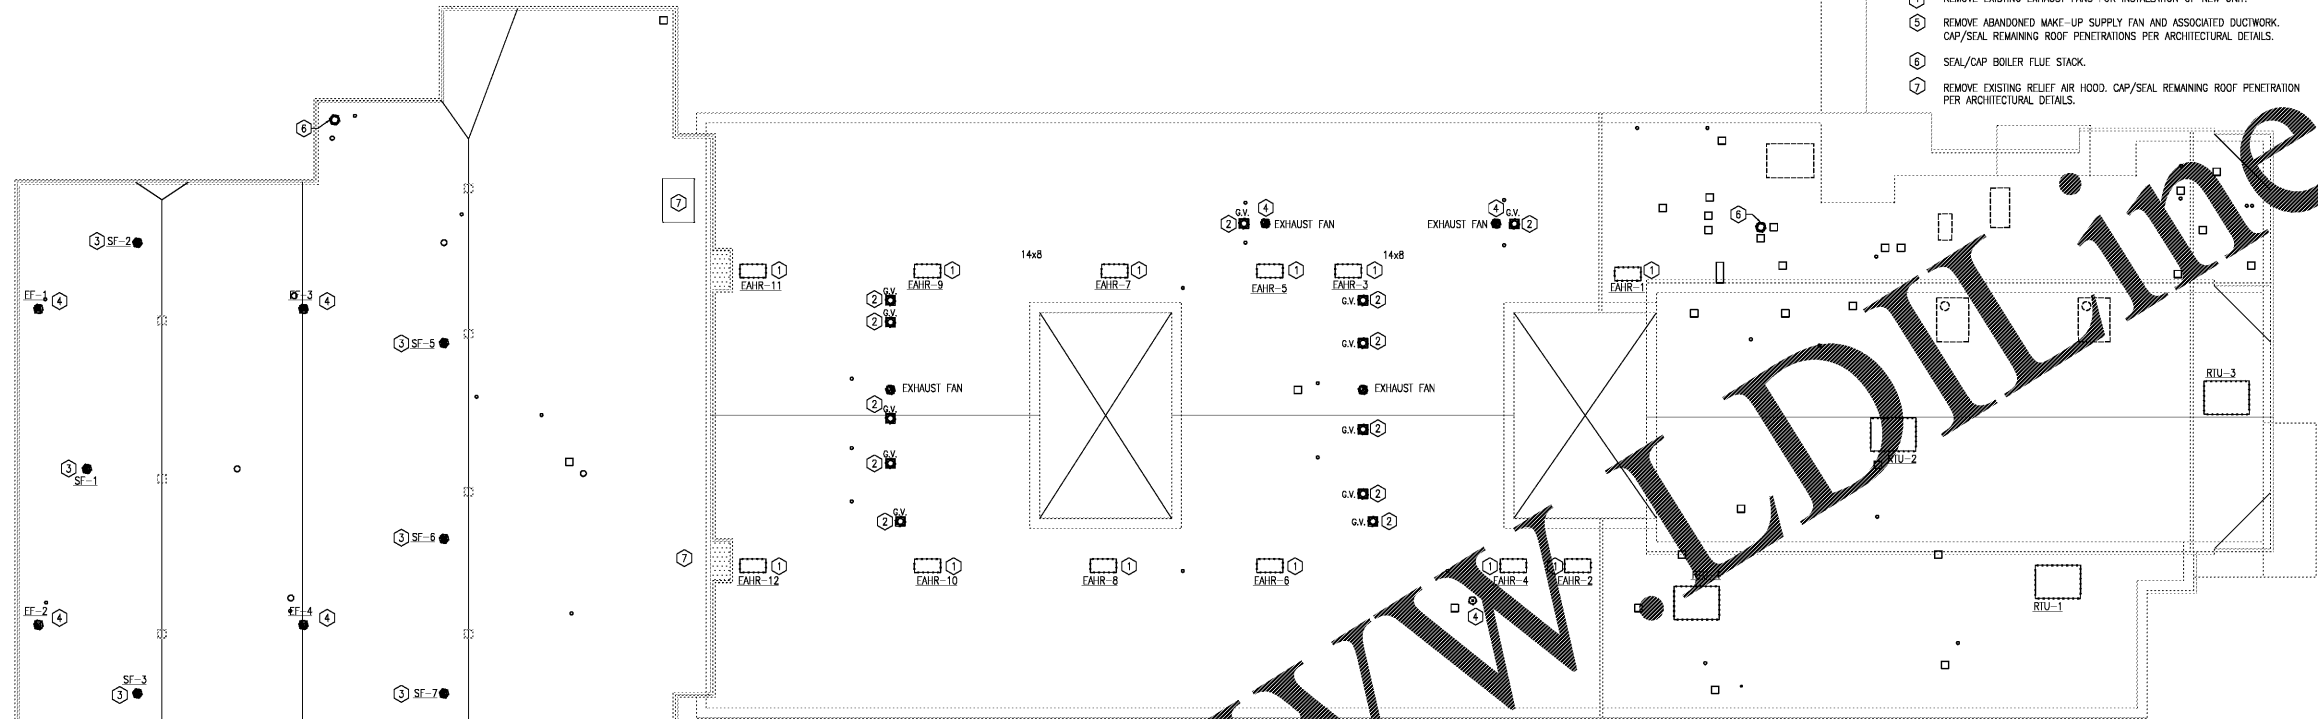

1 HVAC ROOF DEMO PLAN
M2.5 SCALE: 1/16" = 1'-0"

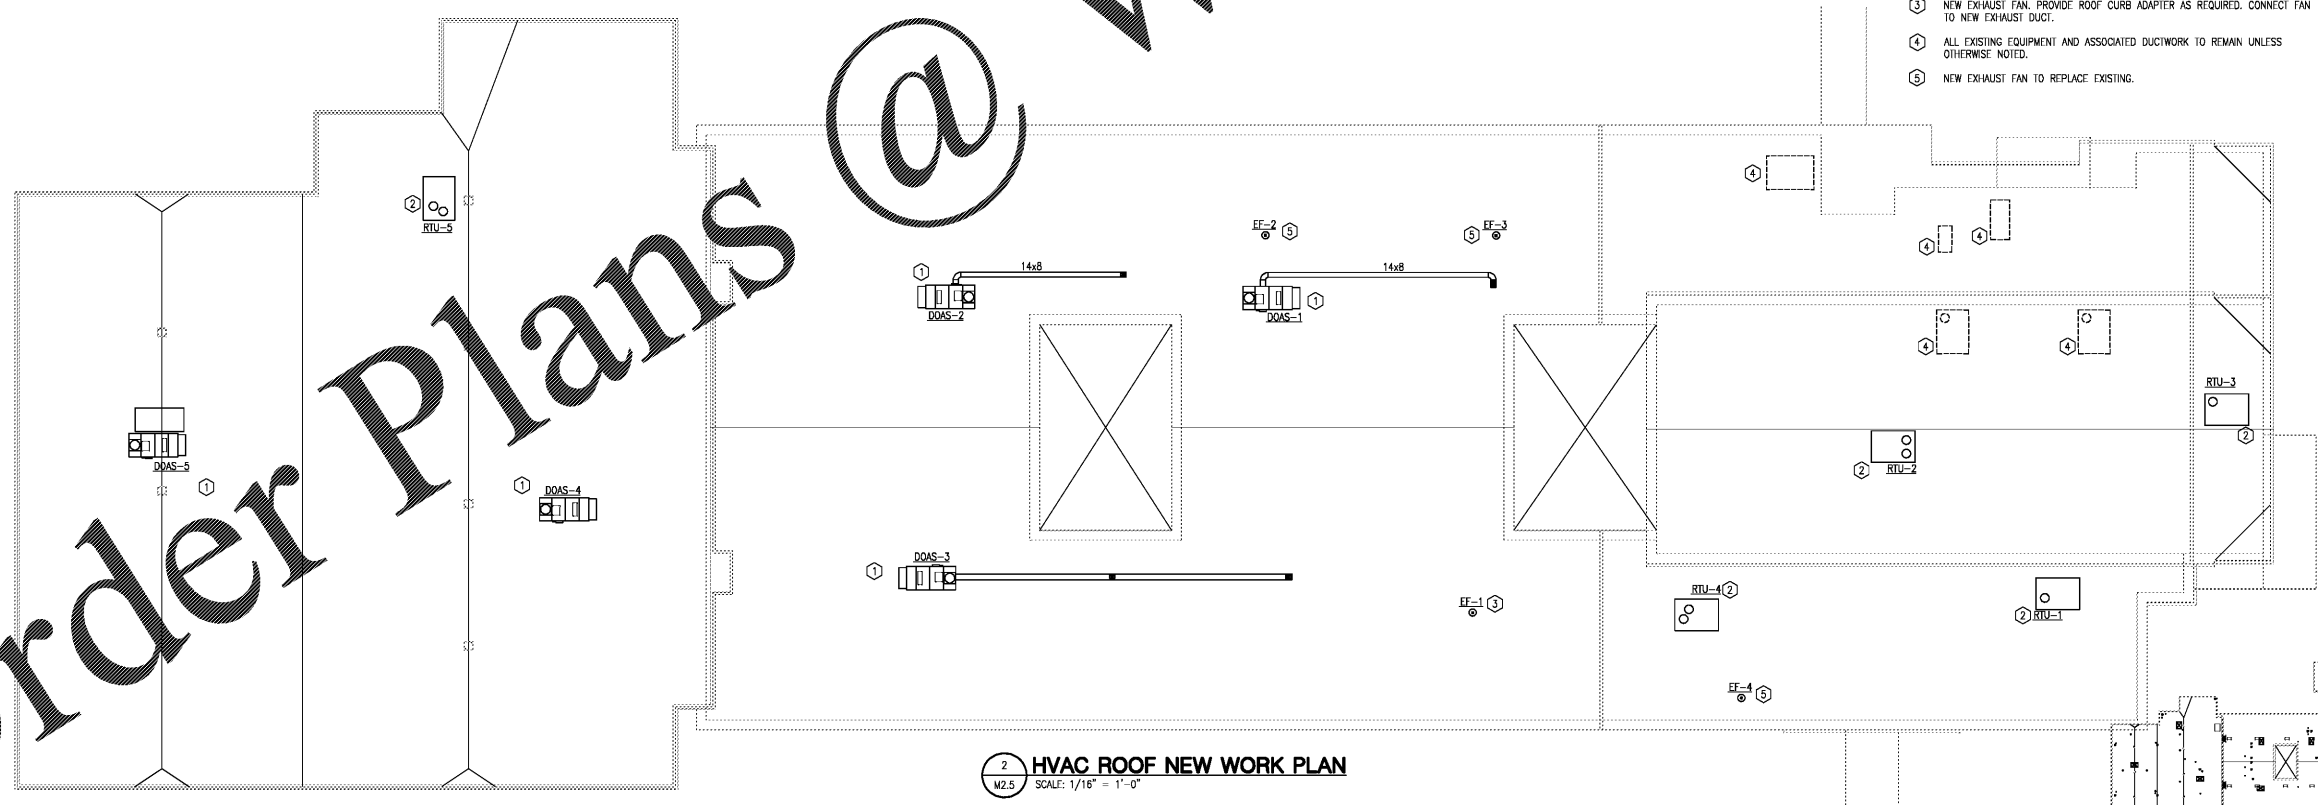

2 HVAC ROOF NEW WORK PLAN
M2.5 SCALE: 1/16" = 1'-0"



KEY PLAN
SCALE: 1" = 100'

FOR PRICING

Order Plans @

WWW.DI.LINE.COM