
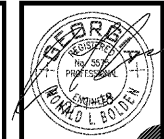


1 ELECTRICAL PARTIAL FLOOR PLAN - FIRE ALARM  
SCALE: 1/8"=1'-0"

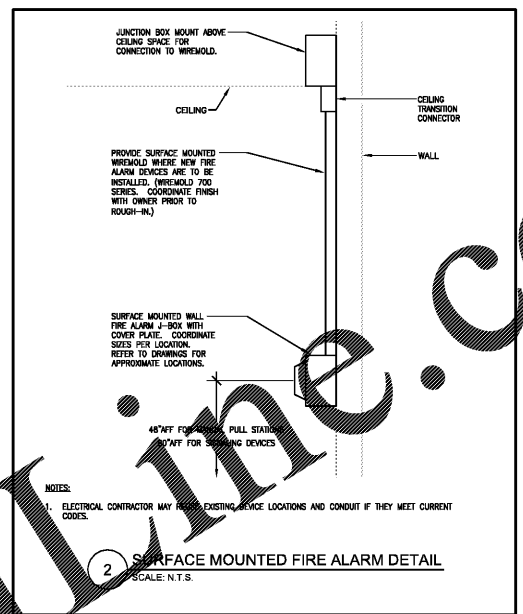

COPYRIGHT OWNERSHIP  
This drawing is the property of Foreman Seeley Fountain Architecture and may not be copied or reused without expressed written permission.  
© 2018

Revisions:


HVAC AND ROOFING RENOVATIONS FOR  
**BRITT ELEMENTARY SCHOOL**

2503 SKYLAND DRIVE SW  
SNELLVILLE, GEORGIA 30078

Facility Code  
# 3030

FOREMAN SEELEY FOUNTAIN  
architecture

3001 Courtyard Lane Drive, Suite 150, Peachtree Corners, Georgia, 30071  
(770) 729-8433  
www.SF5architects.com

Sheet Title:  
ELECTRICAL FLOOR PLAN  
FIRE ALARM

Drawn By: Z.S.G.  
Scale: AS NOTED  
Date: 12/14/2018  
Job No.: 1810  
Sheet No.:

E5.1

FOR PRICING