

**NOTES**  
(THIS SHEET ONLY)

○ REMOVE EXISTING FIRE ALARM CONTROL PANEL AND REPLACE WITH NEW PER SPECIFICATIONS. EXTEND AND RECONNECT EXISTING POWER CIRCUIT.



**COPYRIGHT OWNERSHIP:**  
This drawing is the property of Foreman Seelye Fountain Architecture and may not be used, copied or revised without expressed written permission.  
© 2018

Revisions:

No.	Description

**HVAC AND ROOFING RENOVATIONS FOR  
BRITT ELEMENTARY SCHOOL**

2503 SKYLAND DRIVE SW  
SNELLVILLE, GEORGIA 30078

Facility Code  
# 3050


FOREMAN | SEELEY | FOUNTAIN  
architecture

3000 Courtyard Lane Drive, Suite 150, Peachtree Corners, Georgia, 30071  
(770) 729-8433  
www.FSArchitecture.com

Sheet Title:  
**ELECTRICAL FLOOR PLAN  
FIRE ALARM**

Drawn By: Z.S.G.  
Scale: AS NOTED  
Date: 12/14/2018  
Job No.: 1810  
Sheet No.:

**E5.2**

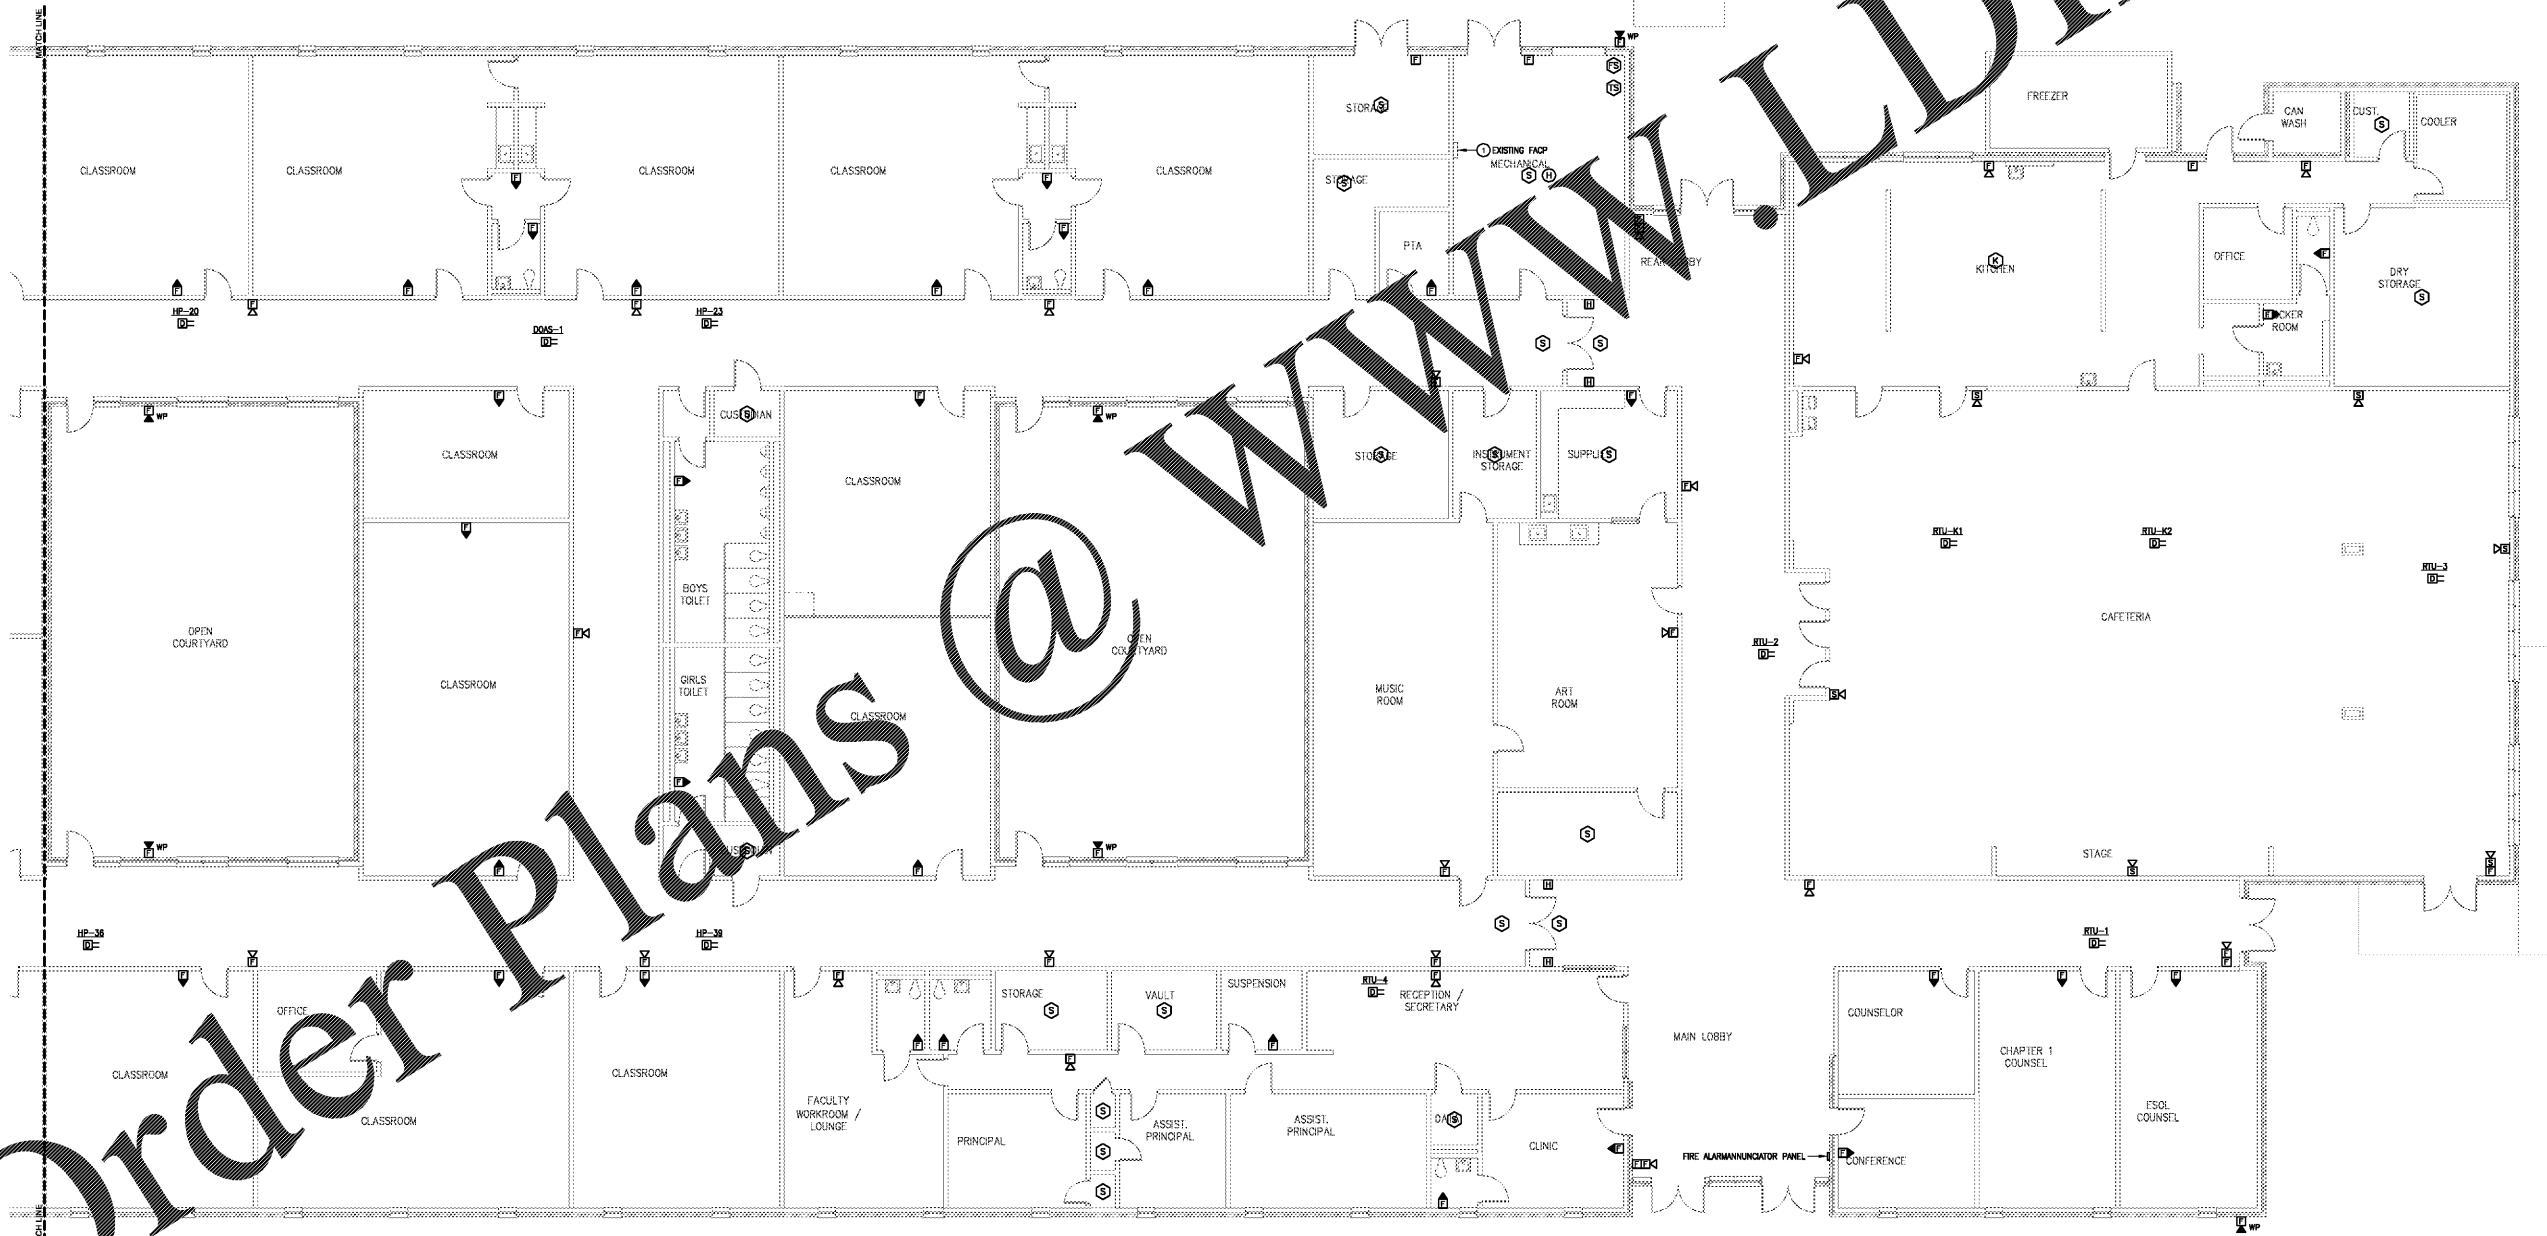

**1 ELECTRICAL PARTIAL FLOOR PLAN - FIRE ALARM**  
SCALE: 1/8"=1'-0"

FOR PRICING

Order Plans @ [www.LDILine.com](http://www.LDILine.com)