


Order Plans @

WWW.LDILine.com

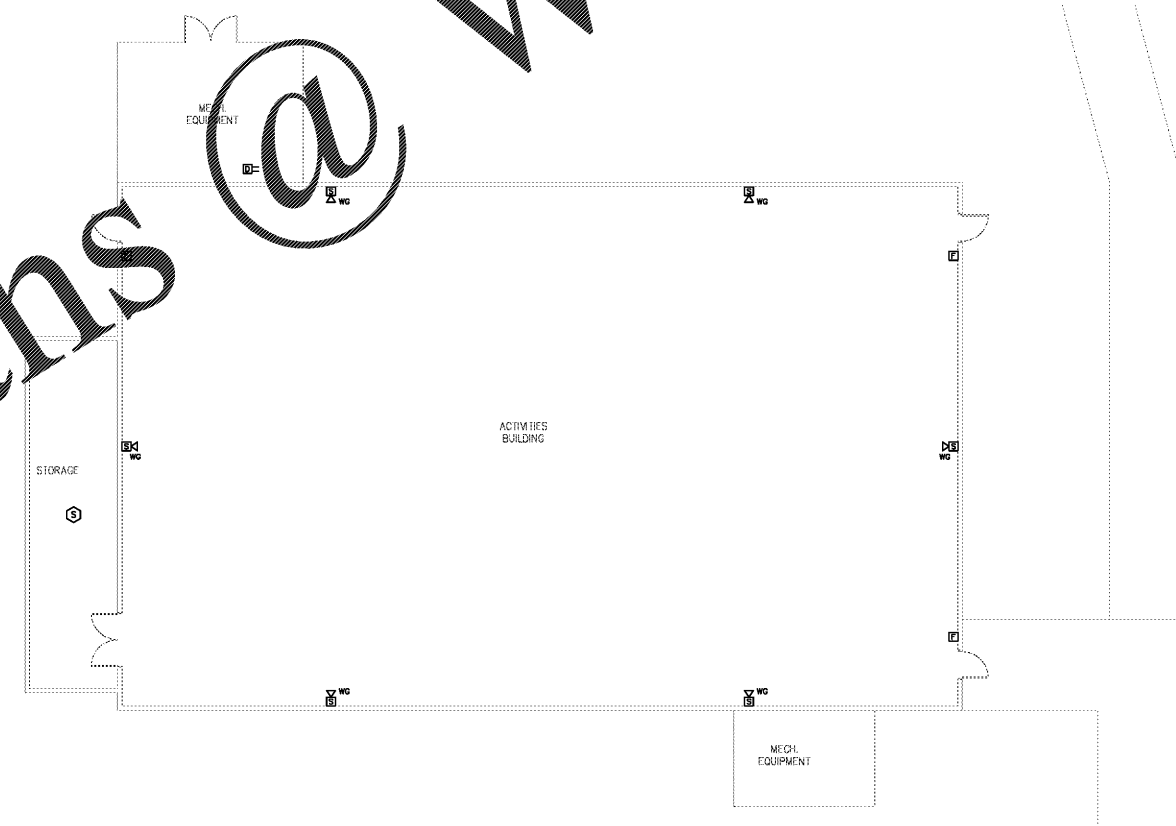

1 ELECTRICAL PARTIAL FLOOR PLAN - FIRE ALARM
SCALE: 1/8"=1'-0"



COPYRIGHT OWNERSHIP:
This drawing is the property of Foreman Seeley Fountain Architecture and may not be copied, copied or revised without expressed written permission.
© 2018

Revisions:

No.	Description

**HVAC AND ROOFING RENOVATIONS FOR
BRITT ELEMENTARY SCHOOL**

2503 SKYLAND DRIVE SW
SNELLVILLE, GEORGIA 30078

Facility Code
3050

FOREMAN | SEELEY | FOUNTAIN
architecture

3001 Courtyard Lane Drive, Suite 150, Peachtree Corners, Georgia, 30071
(770) 729-8433
www.FSF-architect.com

Sheet Title:
ELECTRICAL FLOOR PLAN
FIRE ALARM

Drawn By: Z.S.G.
Scale: AS NOTED
Date: 12/14/2018
Job No.: 1810
Sheet No.:

E5.3

FOR PRICING