


NOTE: 1. THE ELECTRICIAN SHALL INSTALL ADDITIONAL #12 WIRE TIE SUPPORTS FROM THE CEILING GRID TO THE STRUCTURE ABOVE FOR SUPPORT OF THE LIGHT FIXTURES CLIPPED ON THE GRID.  
 NOTE: 2. LIGHT FIXTURES ARE TENANT SUPPLIED / CONTRACTOR INSTALLED.  
 NOTE: 3. MOUNT LIGHTS 10'-0" AFF IN STOCKROOM.

REFLECTED CEILING LEGEND	
	2'-0" x 4'-0" ACOUSTICAL CEILING TILE AND GRID- SEE FINISH NOTE 4.
	GWB - PAINT WHITE UNLESS OTHERWISE NOTED.
	8'-0" STRIP LED LIGHT FIXTURE WITH LAMPS ON NIGHT LIGHT CIRCUIT. SURFACE MOUNT TO GWB AND ACT CEILING.
	8'-0" STRIP LED LIGHT FIXTURE. SURFACE MOUNT TO GWB AND ACT CEILING.
	8'-0" STRIP LED LIGHT FIXTURE WITH LAMPS ON EMERGENCY LIGHT CIRCUIT WITH BATTERY PACK. SURFACE MOUNT TO GWB AND ACT CEILING. FOR FIXTURES WITH 4 LAMPS, THE EMERGENCY BATTERY PACK WILL ONLY OPERATE 2 OF THE LAMPS.
	4'-0" STRIP LED LIGHT FIXTURE WITH LAMPS ON NIGHT LIGHT CIRCUIT. SURFACE MOUNT TO TO GWB AND ACT CEILING.
	4'-0" STRIP LED LIGHT FIXTURE. SURFACE MOUNT TO ACT AND GWB CEILING.
	4'-0" STRIP LED LIGHT FIXTURE WITH LAMPS ON EMERGENCY LIGHT CIRCUIT WITH BATTERY PACK. SURFACE MOUNT TO TO GWB AND ACT CEILING.
	EXIT LIGHT
	VENTILATION FAN
	CEILING HEIGHT ABOVE FINISH FLOOR
	DIFFUSER
	RETURN AIR GRILLE
	SPRINKLER HEAD (SHOWN FOR INFORMATIONAL PURPOSES ONLY. SPRINKLER CONTRACTOR SHALL PREPARE DRAWINGS AS REQUIRED BY CODE FOR RELOCATION OR ADDITION OF HEADS.)
	POWER POLE
	EMERGENCY LIGHT FIXTURE

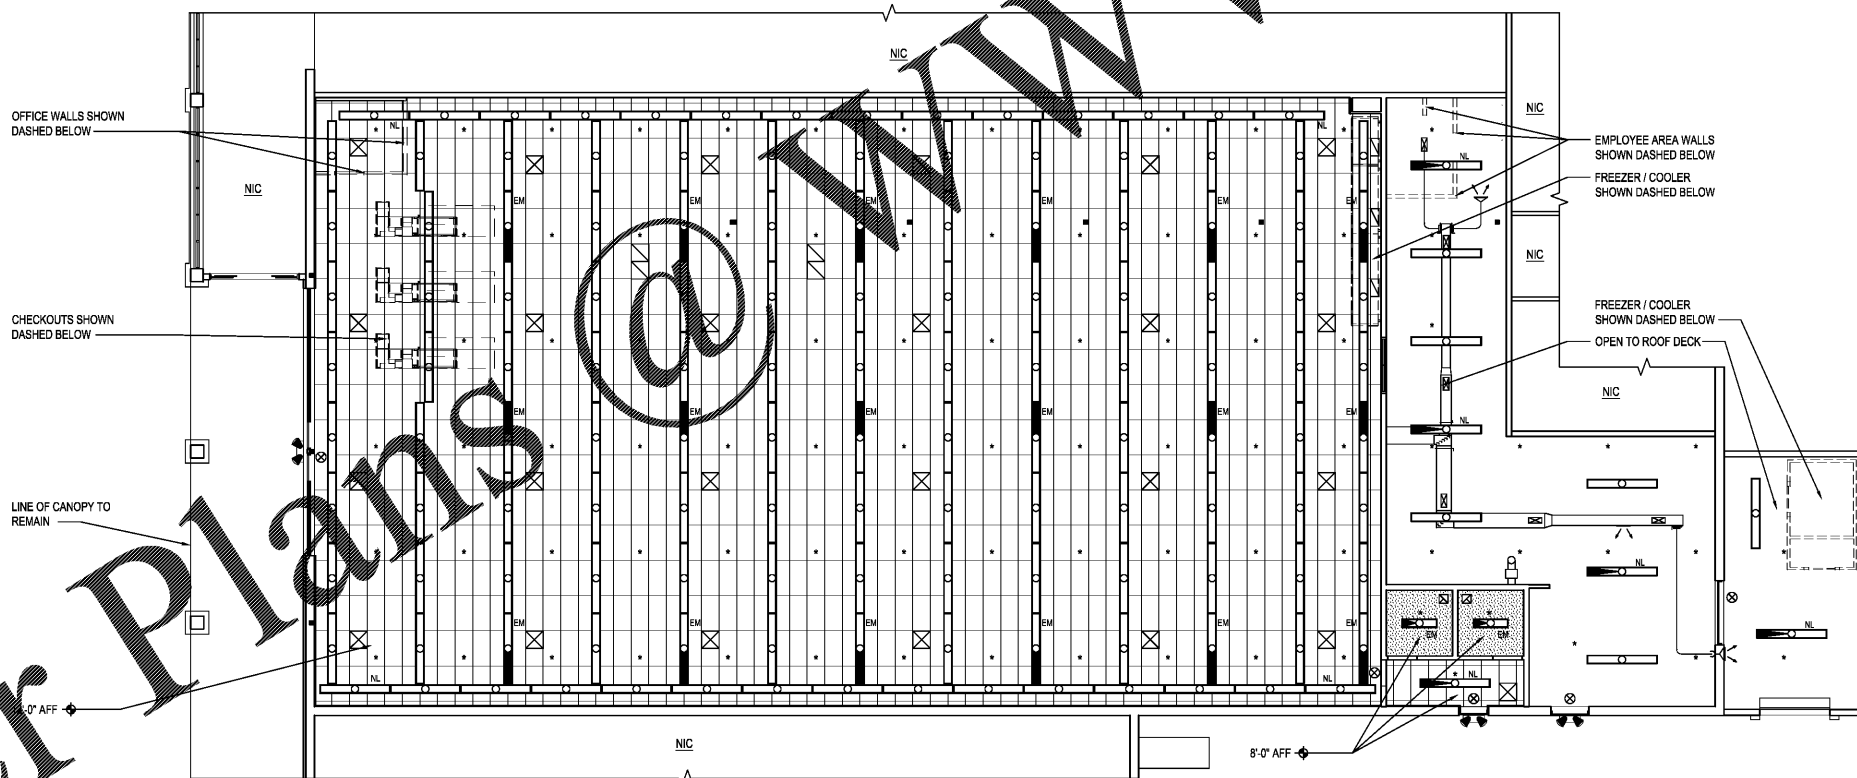

REFLECTED CEILING PLAN  
 SCALE: 1/8" = 1'-0"



Order Plans @ WWW.LDILine.com

project description

by

date

mark revisions

date	project	designed	drawn	checked
10/10/2018		RWH	RWH	DMH
10/25/18		RWH	RWH	DMH



**RRMM ARCHITECTS, P.C.**  
 Robert S Berz, Jr, Architect  
 Duane M Harver, Architect

1317 Executive Blvd, Suite 200  
 Chesapeake, VA 23320  
 (757) 622-2828 / fax (757) 622-6883

project

**DOLLAR TREE**  
 FORMER HARVEY'S  
 FORT VALLEY, GEORGIA  
 REFLECTED CEILING PLAN AND LEGEND

drawing

sheet

**A2**