


Order Plans

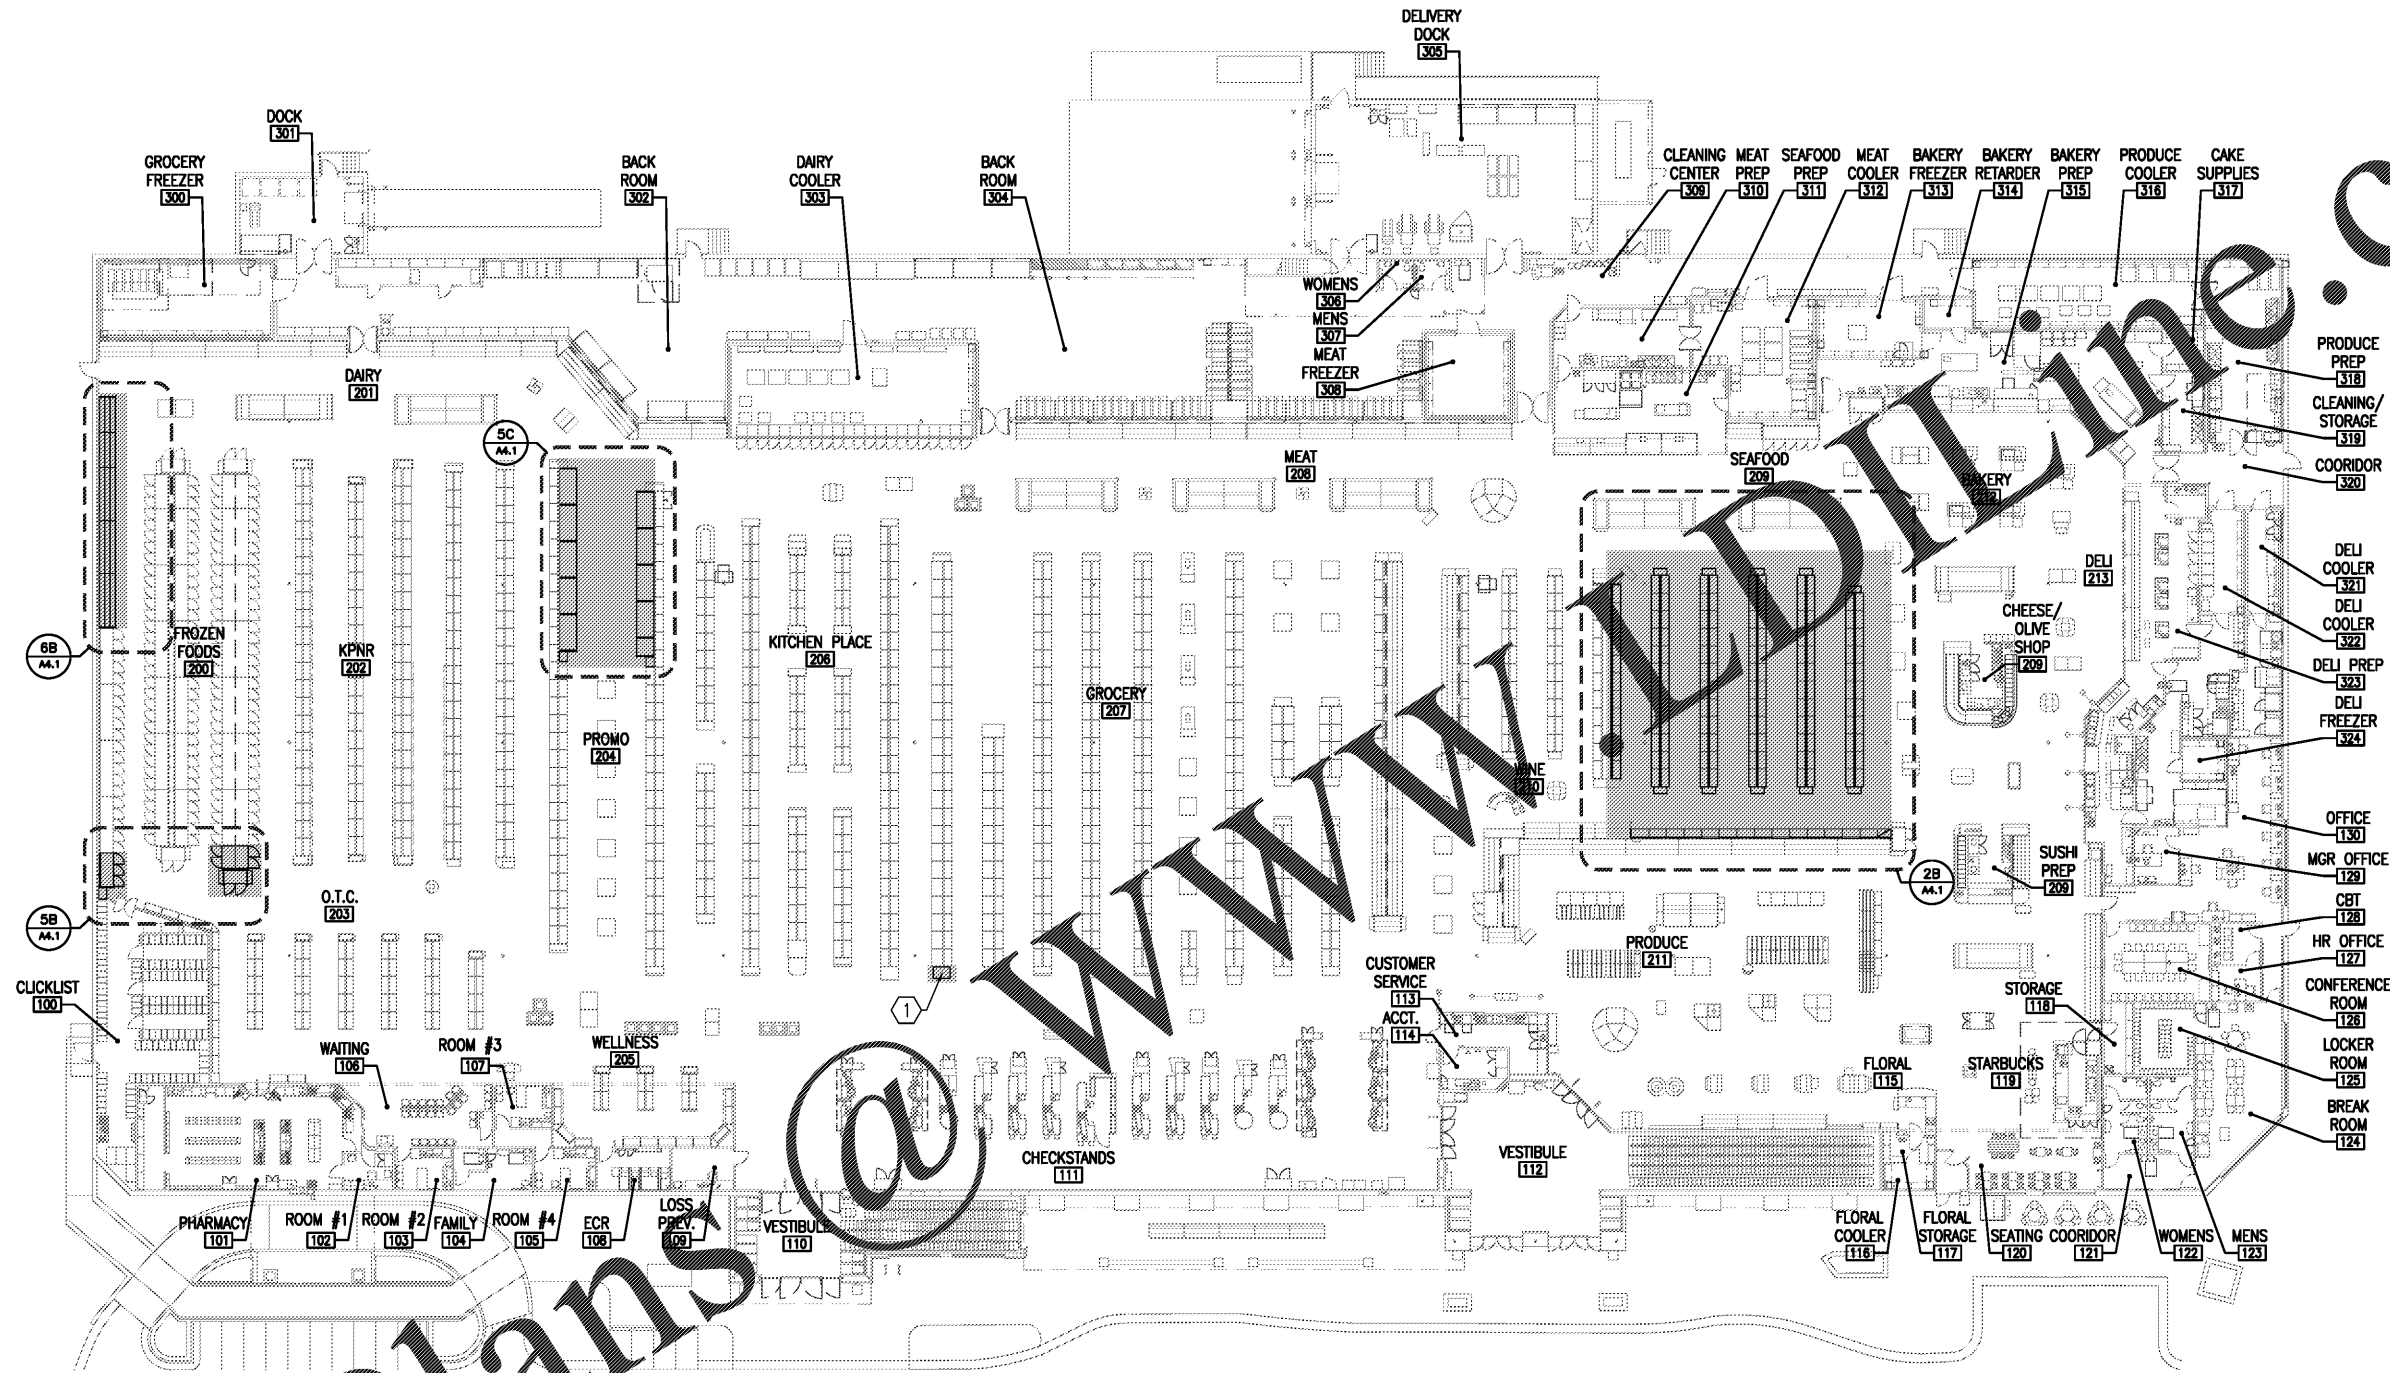

4B FLOOR PLAN - MAIN LEVEL
SCALE: 1/8" = 1'-0"

PLAN NOTES

1. NEW FIXTURE TO BE FURNISHED BY KROGER AND INSTALLED BY REFRIGERATION CONTRACTOR (R.C.) PER SPEC. SECT. 114122. SEE PLUMBING, ELECTRICAL AND/OR REFRIGERATION DRAWINGS FOR MORE INFORMATION. G.C. TO COORDINATE.

AREA OF WORK

TOTAL AREA OF WORK = 5,900 S.F.

GENERAL NOTES

1. SEE AS SHEET SERIES FOR ASD & GISD DETAILS
2. ALL FIRE PROTECTION SYSTEM COMPONENTS AND SMOKE ALARM SYSTEMS TO REMAIN INTACT AND FUNCTIONAL DURING CONSTRUCTION PROCESS. G.C. TO PROVIDE MODIFICATIONS TO EXISTING SYSTEM AS REQUIRED BY NEW WORK TO MEET CURRENT FIRE PROTECTION CODES. G.C.'S FIRE PROTECTION CONTRACTOR TO PROVIDE LOCAL JURISDICTION W/ ANY DRAWINGS/SPECIFICATIONS BY LICENSED FIRE PROTECTION ENGINEER AS REQUIRED FOR NEW WORK.
3. REFER TO ELECTRICAL & PLUMBING DRAWINGS FOR MORE INFORMATION ON NEW & DEMOLITION WORK RELATED AND REQUIRED.
4. FURNISH & INSTALL FRT WOOD BLOCKING IN WALLS FOR ALL WALL MOUNTED FIXTURES AND ACCESSORIES PER SPECIFICATION SECTION 061053.
5. INSTALL KROGER FURNISHED FIRE EXTINGUISHERS. COORDINATE LOCATIONS WITH BUILDING OFFICIAL AND FIRE OFFICIAL.
6. PATCH AND REPAIR ALL EXISTING WALLS RECEIVING NEW FINISHES. FINISHES TO INCLUDE PAINT, WALLPAPER, MARLITE, ETC. INTENT IS TO PROVIDE SMOOTH EVEN FINISH.
7. FURNISH & INSTALL NEW FLOOR FINISHES TO MATCH EXIST. ADJACENT WHERE EXISTING SLAB HAS BEEN EXPOSED BY REMOVED WALLS/FIXTURE OR NEW SLAB HAS BEEN POURED.
8. MODIFY, REPAIR AND REPAINT VERTICAL PIPE DROPS PER GISD-4 FOR ELECTRICAL & REFRIGERATION LINES REQUIRE BY NEW WORK.
9. ABBREVIATIONS: F.C.(FURNISHED BY CONTRACTOR, I.C.(INSTALLED BY CONTRACTOR, F.O.(FURNISHED BY OWNER), I.O.(INSTALLED BY OWNER).



CAPSTONE PROJECT SERVICES, PLC
ARCHITECTURAL & CONSTRUCTION SERVICES
OFFICE LOCATIONS: ROANOKE, VA - FT. WALTER, FL

A REMODEL FOR:
KROGER GA-388
564 CROSSTOWN DRIVE
PEACHTREE CITY, GA

12-21-2018
CONSTRUCTION SET

MARK	DATE	DESCRIPTION

PROJECT NO: CP5008-04
CAD DWG FILE: CP5008-04-A11
DRAWN BY: JMH
CHK'D BY: JMH

A1.1