

KEYED NOTES

PD01 DEMOLISH DRAIN AND CAP PIPING BELOW SLAB. REFER TO DETAIL 'D' ON COVER SHEET.

PD02 REMOVE EXISTING HOUSE TRAP TO LOCATION SHOWN ON P1.1. REFER TO NEW PLUMBING FLOOR PLAN FOR ADDITIONAL NOTES.

PD03 DEMOLISH DRAIN. REFER TO P1.1 FOR NEW WORK CONNECTING INTO EXISTING FITTING.

CAPSTONE
 PROJECT # 2018-016
 333 S. TAMM LANE, SUITE 103
 WINNEMUCA, KY 40485

MECHANICAL/ELECTRICAL ENGINEERS
 WWW.KLHENGINEERS.COM
 LEXINGTON, KENTUCKY
 LOUISVILLE, KENTUCKY
 NEW YORK, NEW YORK

KLH ENGINEERS
 1500 ALEXANDRIA PIKE, SUITE 11
 FT. THOMAS, KENTUCKY 41075
 502-442-8008 FAX
 502-442-8008 FAX

CONSULTANT

A REMODEL OR NEW CONSTRUCTION FOR:

KROGER GA-388

564 CROSSTOWN DRIVE PEACHTREE CITY, GA

PROJECT KROGER REGION

12-21-2018

DATE CONSTRUCTION SET

PLUMBING
 EXISTING
 DEMOLITION
 PLAN WASTE
 AND VENT


REVISIONS

NO.	DATE	DESCRIPTION

PROJECT NO: 20995
 CAD DWG FILE:
 DRAWN BY: ISF
 CHECKED BY: KCN

PD1.1

SHEET NO

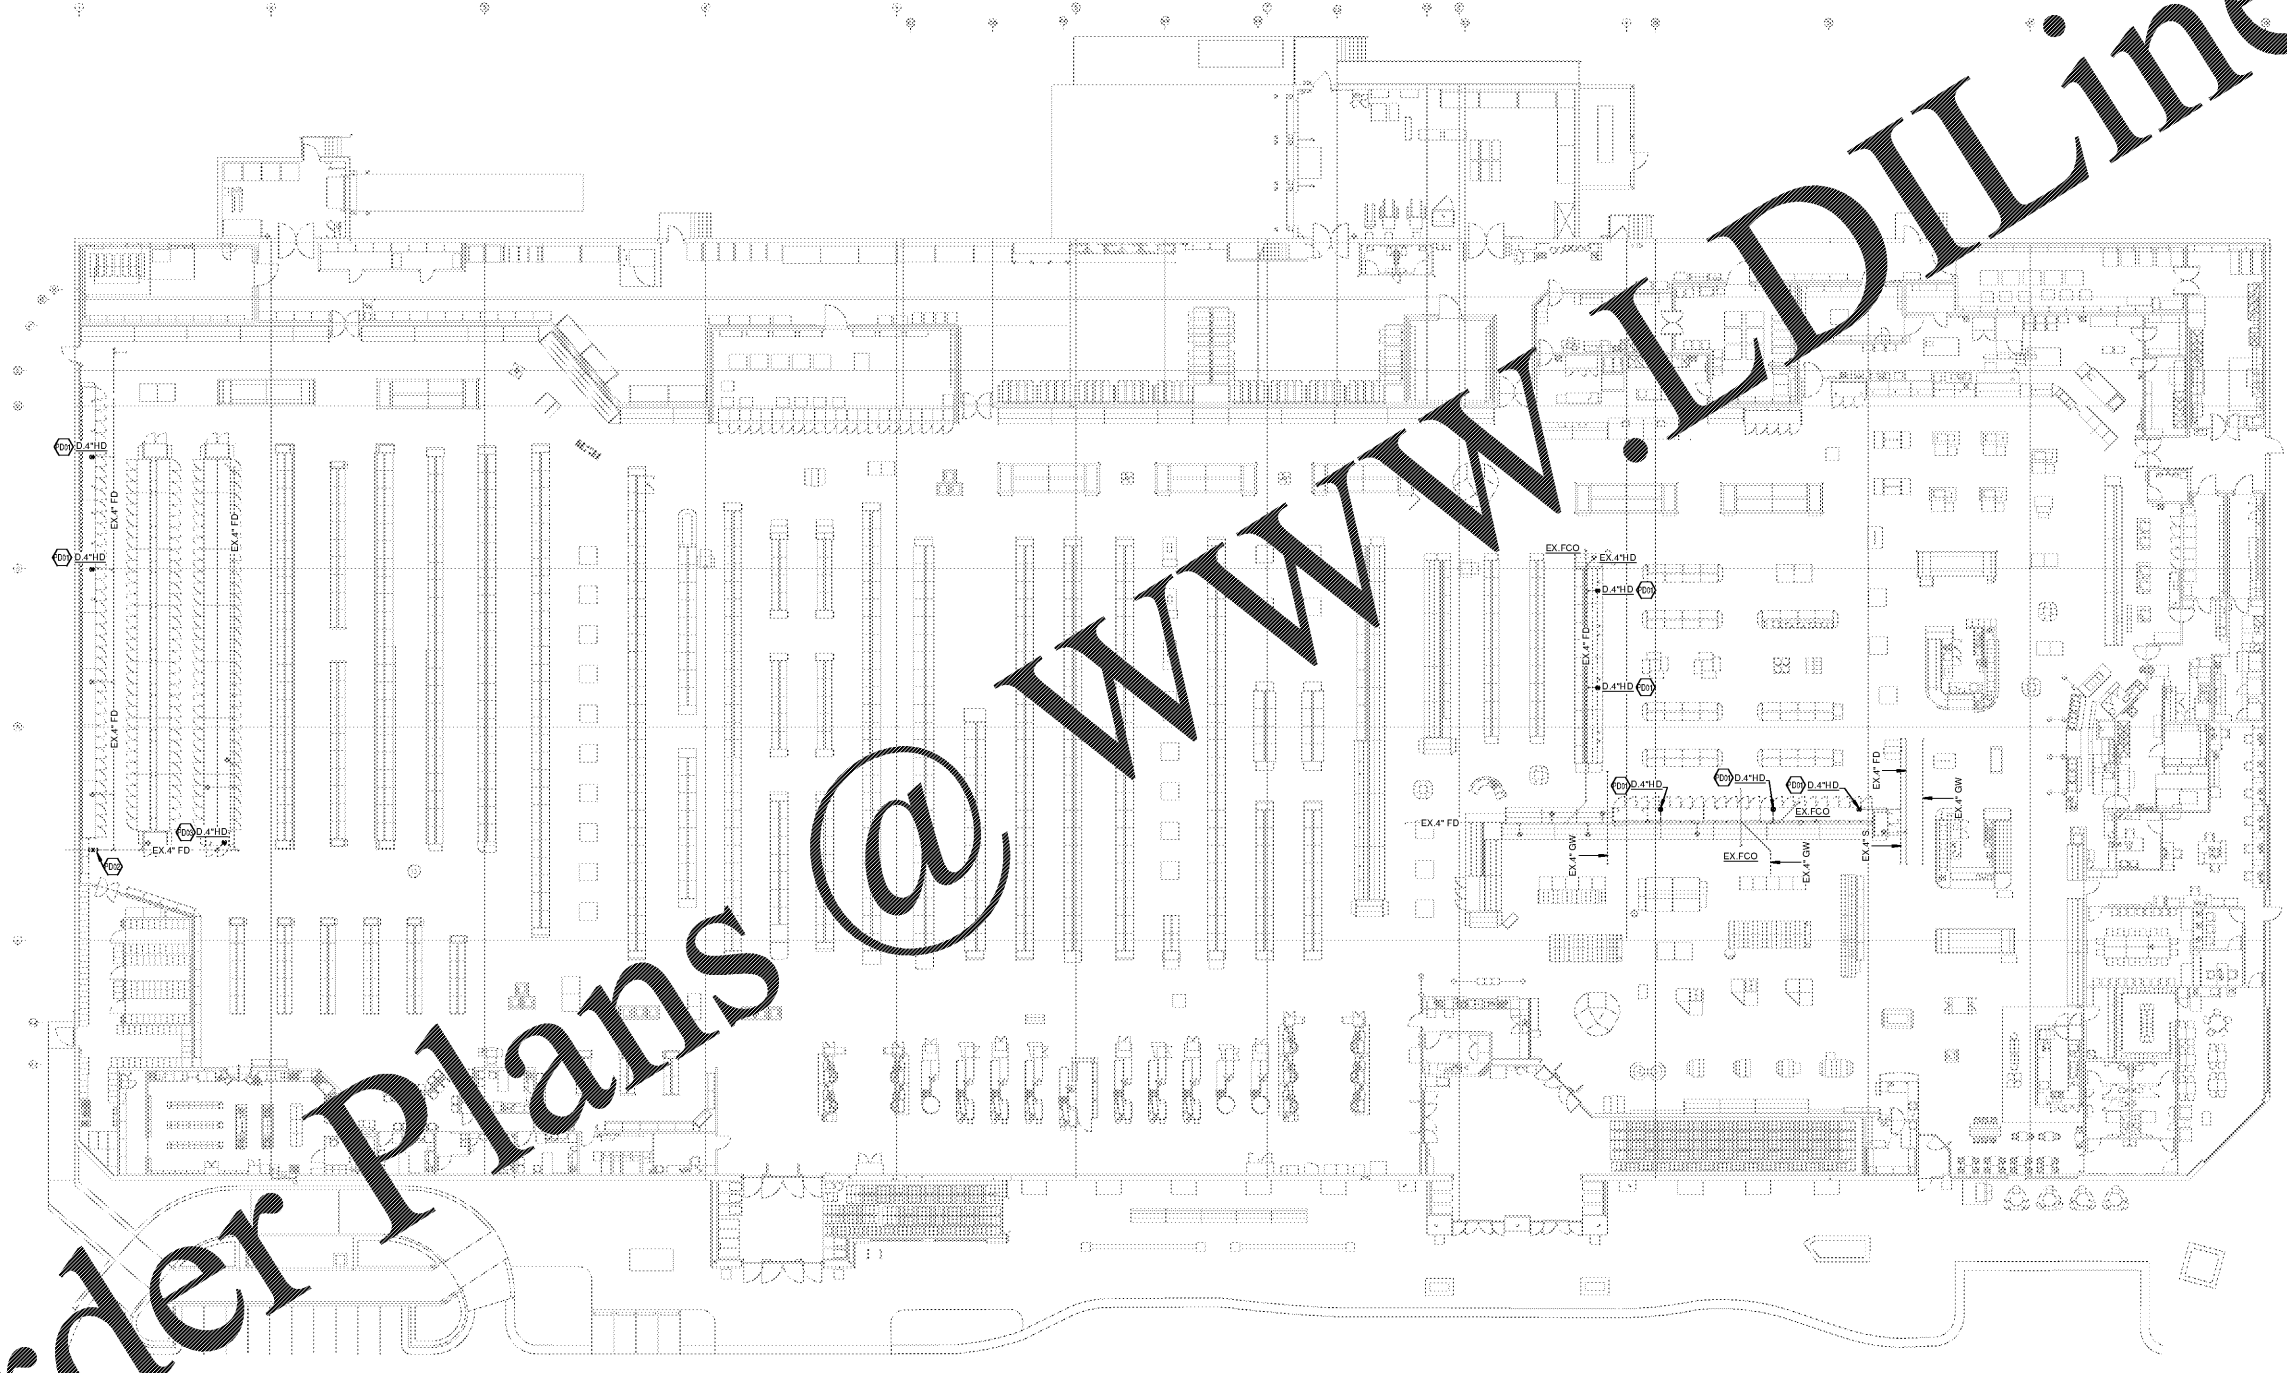

1 PLUMBING EXISTING DEMOLITION PLAN
 1/16" = 1'-0"

2" REFERENCE LINE

Order Plans @

WWW.LDLine.com

OWNERSHIP OF INSTRUMENTS OF SERVICE
 All reports, plans, specifications, computer files, field data, notes and other documents and instruments prepared by the Consultant as instruments of service shall remain the property of the Consultant. The Consultant shall retain all common law, statutory and other reserved rights, including, without limitation, the copyright therein.