


GENERAL LIGHTING NOTES
 A. ALL FLUORESCENT LAMPS SHALL BE 3500 K, FURNISHED BY KROGER UNLESS NOTED OTHERWISE.
 B. DO NOT ATTACH ANY CONDUITS OR SUSPEND ANY LIGHTING FROM ROOF DECK.

CAPSTONE
 PROJECT NO. 2018-016
 333 S. TAMM LANE, SUITE 103
 WINNEMUCA, KY 40485



MECHANICAL/ELECTRICAL ENGINEERS
 WWW.KLHENRIS.COM
 LEXINGTON, KENTUCKY
 LOUISVILLE, KENTUCKY
 NEW YORK, NEW YORK

KLH ENGINEERS
 1500 ALEXANDRIA PIKE, SUITE 11
 FT. THOMAS, KENTUCKY 41075
 502-805-1200
 502-842-8058 FAX

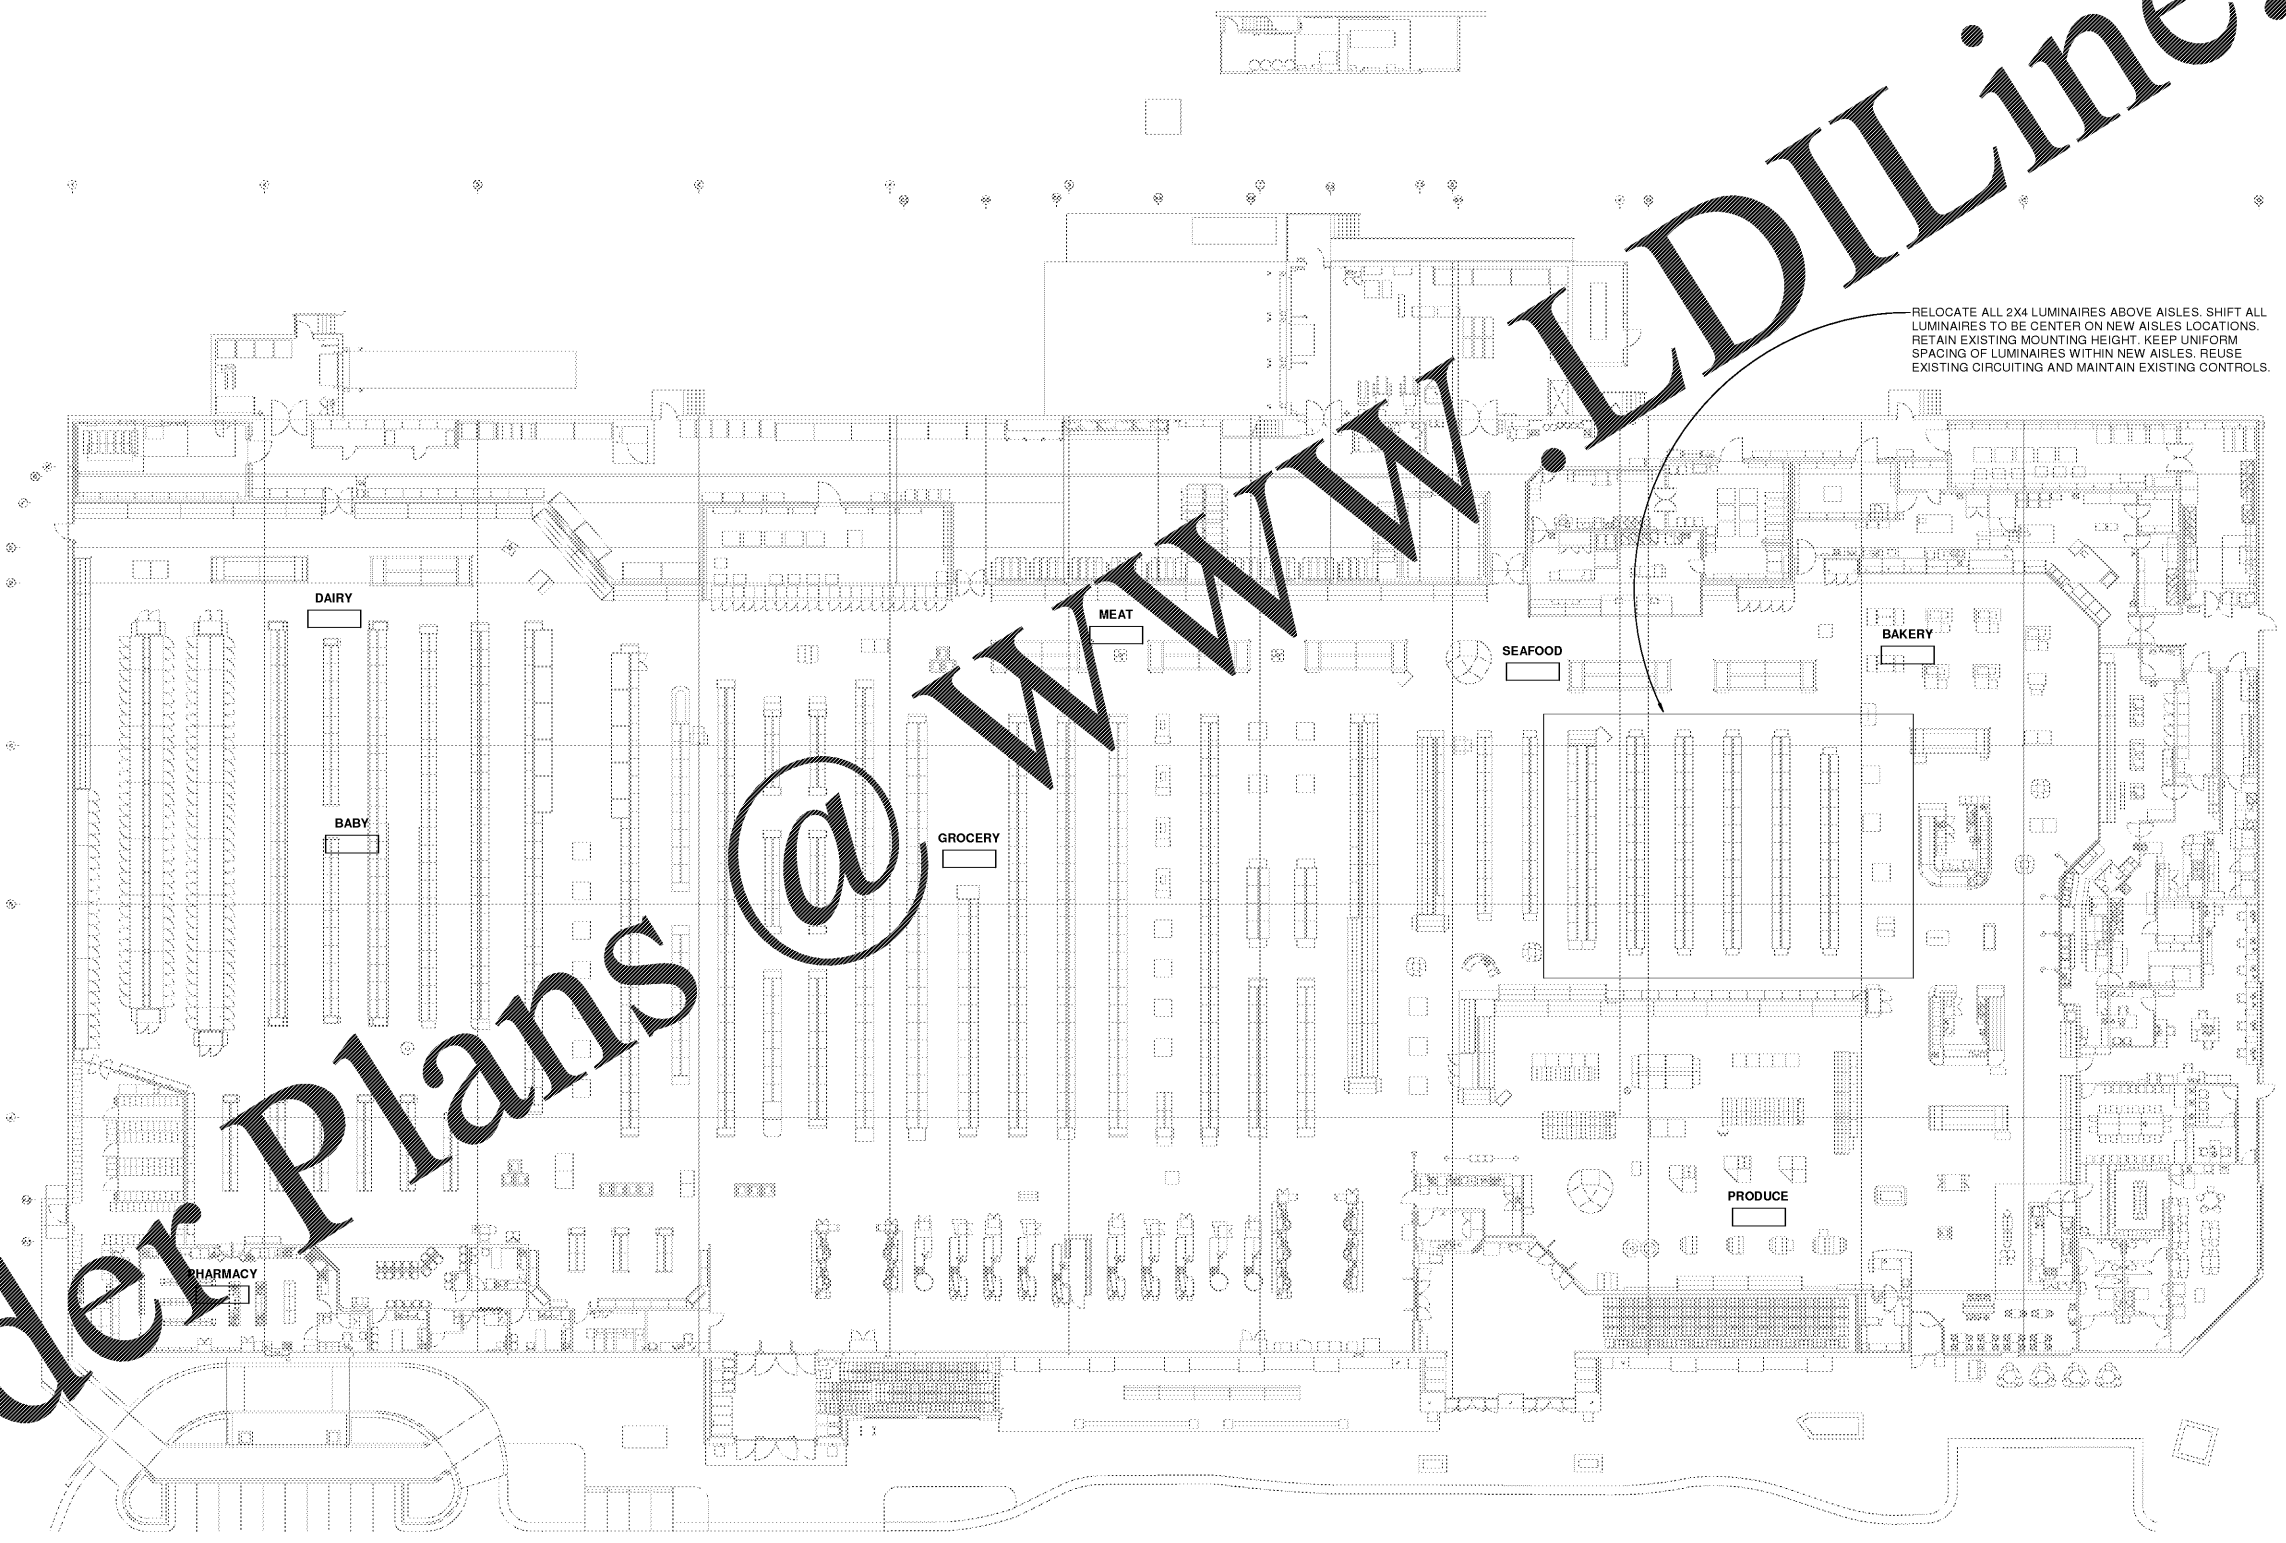

Order Plans @

WWW.LDILine.com

A REMODEL OR NEW CONSTRUCTION FOR:
KROGER GA-388
 564 CROSSTOWN DRIVE PEACHTREE CITY, GA

PROJECT: KROGER REGION
 DATE: 12-21-2018
 CONSTRUCTION SET

LIGHTING PLAN AND DETAILS

NO.	DATE	DESCRIPTION

PROJECT NO: 20995
 CAD DWG FILE:
 DRAWN BY: JAD
 CHECKED BY: JAT

E1.1

1 LIGHTING PLAN AND DETAILS
 1/16" = 1'-0"

2" REFERENCE LINE

OWNERSHIP OF INSTRUMENTS OF SERVICE
 All reports, plans, specifications, computer files, field data, notes and other documents and instruments prepared by the Consultant as instruments of service shall remain the property of the Consultant. The Consultant shall retain all common law, statutory and other reserved rights, including, without limitation, the copyright thereto.