




4 EXHAUST DUCTWORK DETAIL - FIRST, SECOND, & THIRD FLOORS
SCALE: NOT TO SCALE

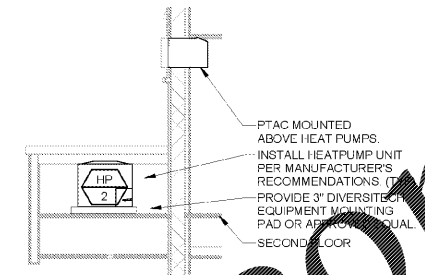

3 SECTION AT UTILITY ROOM 240
SCALE: NOT TO SCALE

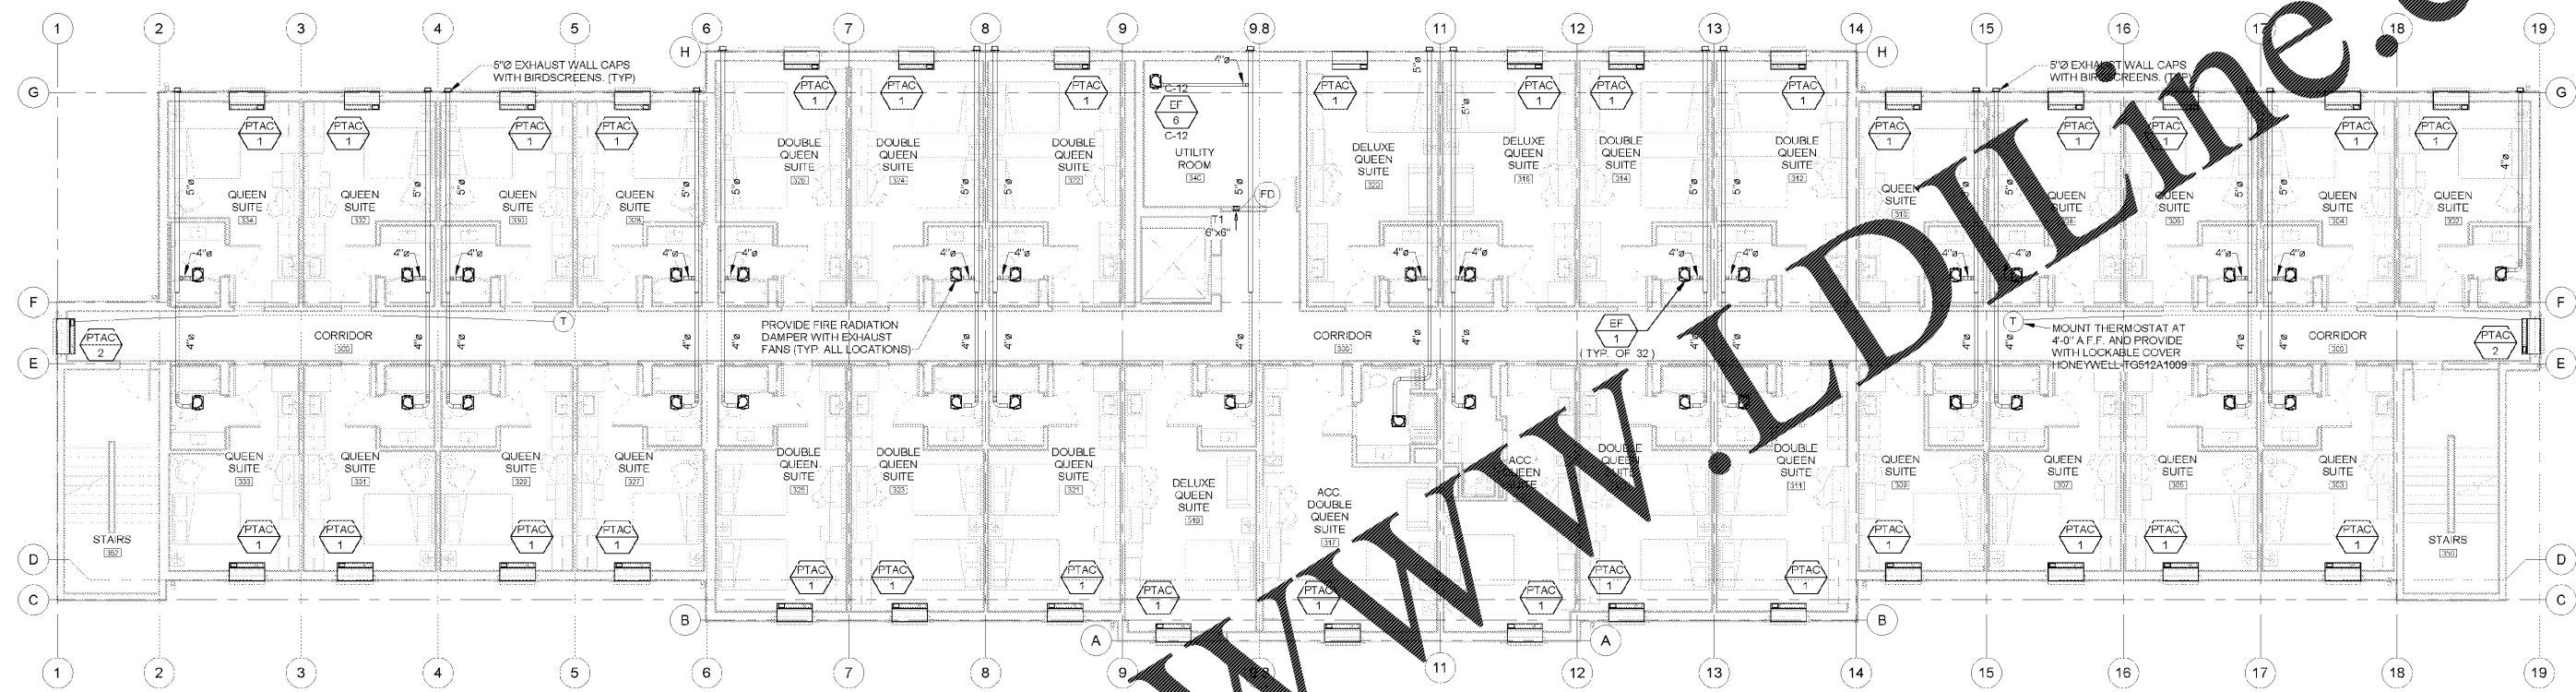

MECHANICAL THIRD FLOOR PLAN
SCALE: 1/8" = 1'-0"

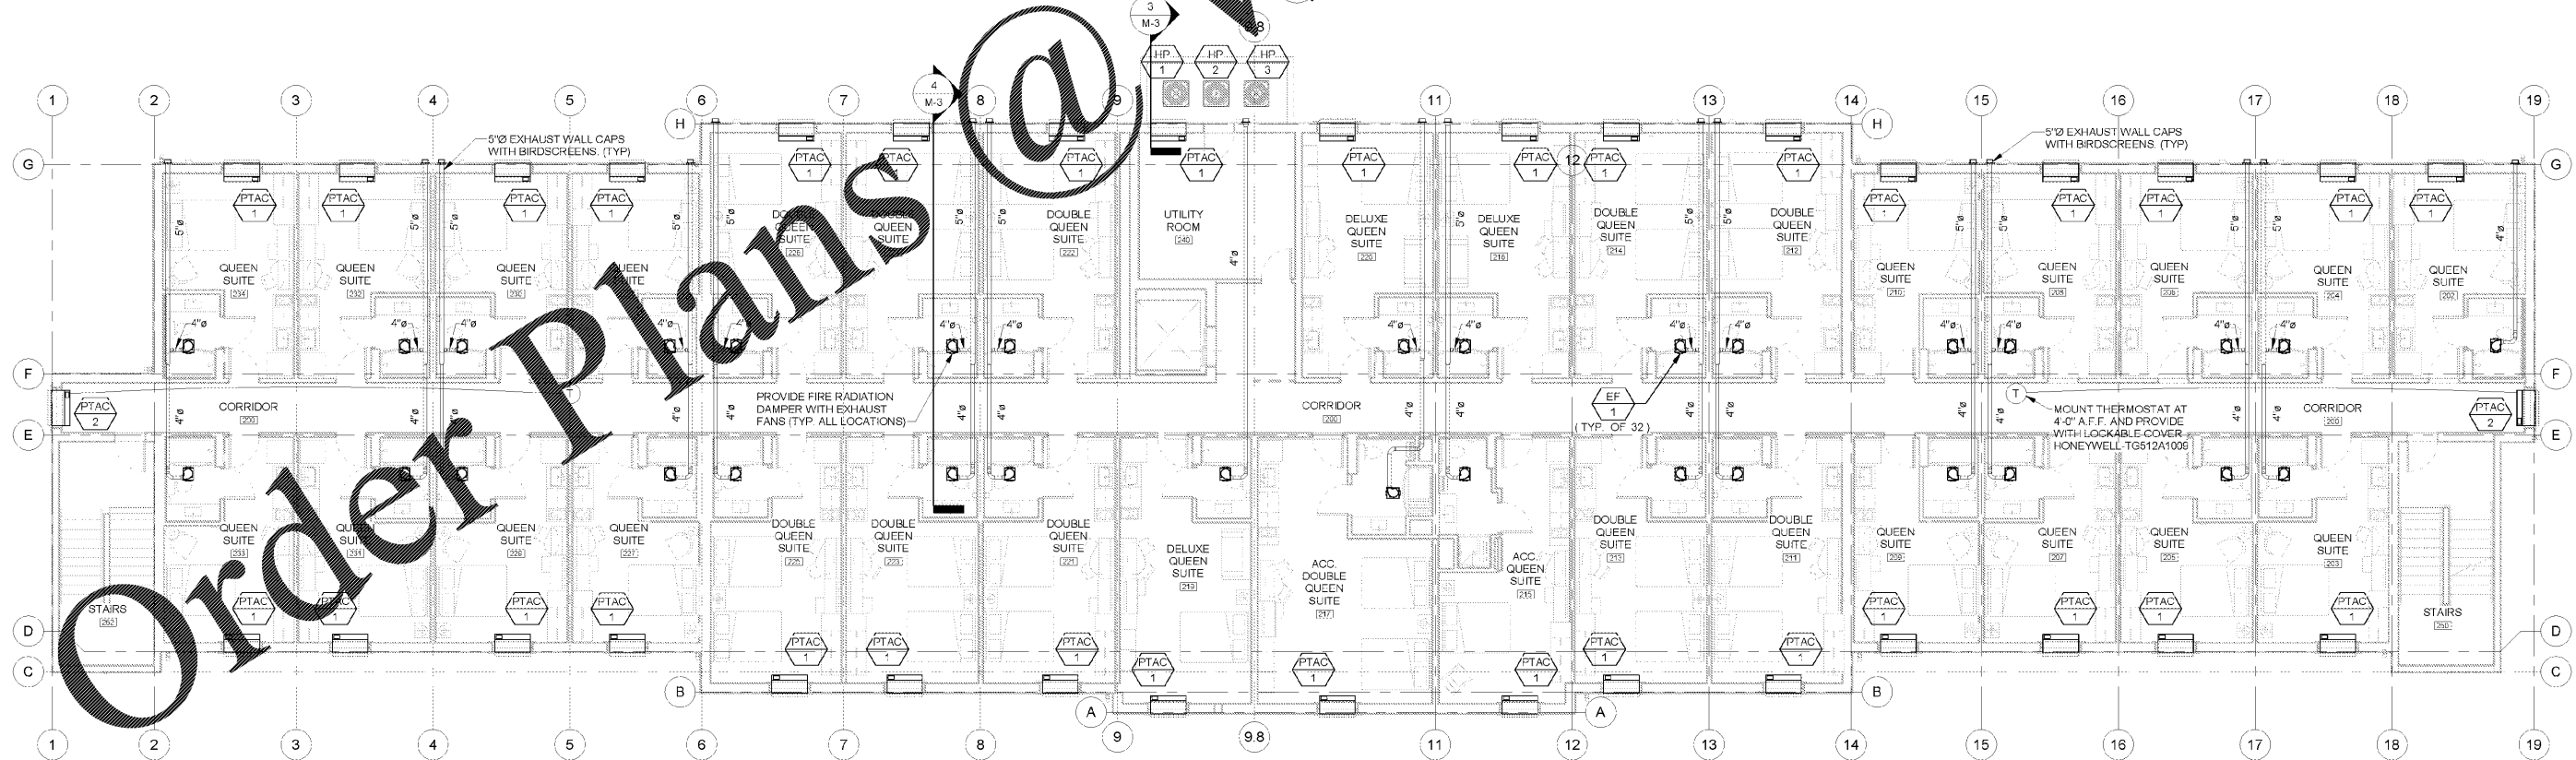

1 MECHANICAL SECOND FLOOR PLAN
SCALE: 1/8" = 1'-0"

WOOLPERT
377 Northridge Road
Suite 300
Atlanta, GA 30350
770.391.4095
FAX: 770.391.4104

ACERTUS CONSULTING GROUP, LLC
14817 West 95th Street • Lenexa, Kansas 66215
P 913 322 5150 • F 913 322 5155
www.AcerusGroup.com

WOODSPRING SUITES
CYPRESS CREEK, FLORIDA
Pasco County
Cypress Creek, FL

Issues & Revisions:

Proj. No.: 078761
Date: 10/05/2018

Sheet Name:
MECHANICAL
SECOND AND THIRD
FLOOR PLANS

M-3

60% OWNER REVIEW | 09.10.18

11/2/2018 5:01:20 PM