


**2 EXHAUST DUCTWORK DETAIL - FOURTH FLOOR**  
 SCALE: NOT TO SCALE

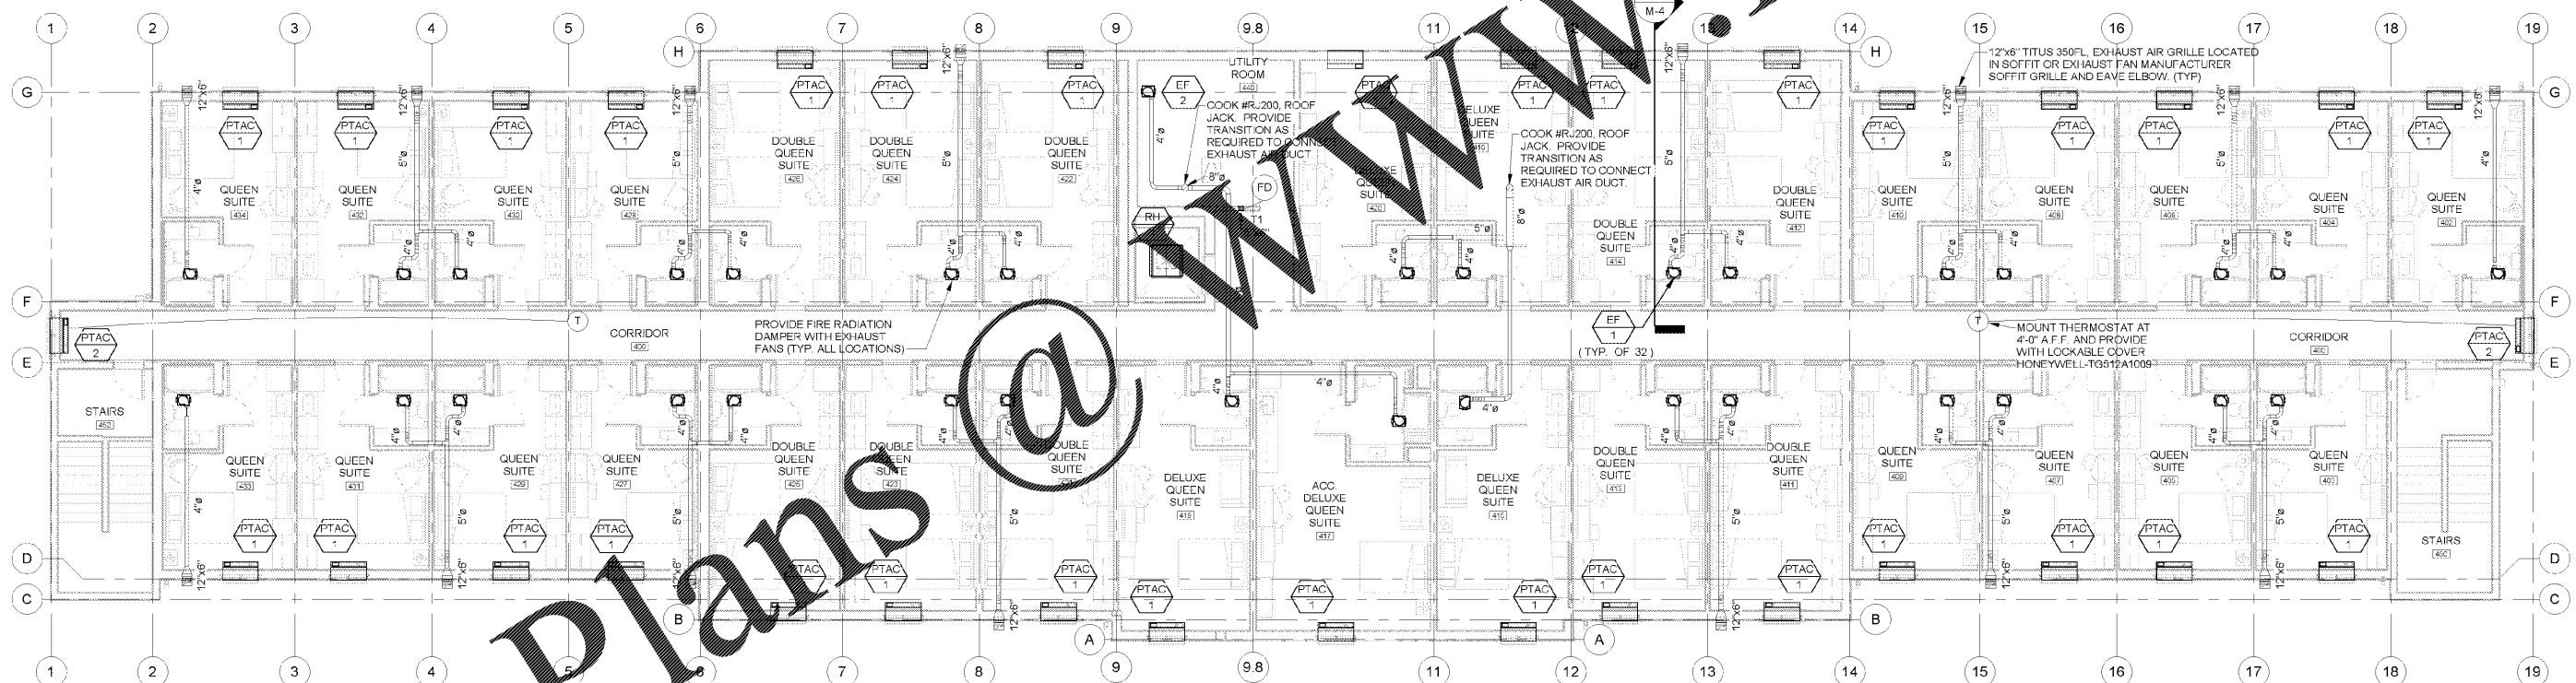

**1 MECHANICAL FOURTH FLOOR PLAN**  
 SCALE: 1/8" = 1'-0"

**WOODSPRING SUITES**  
 CYPRESS CREEK, FLORIDA  
 Pasco County  
 Cypress Creek, FL

Issues & Revisions:

Proj. No.: 078761  
 Date: 10/05/2018

Sheet Name:  
 MECHANICAL  
 FOURTH FLOOR  
 PLAN

**M-4**

**60% OWNER REVIEW | 09.10.18**

11/2/2018 5:01:25 PM

Order Plans @

www.LDline.com