


PANELBOARD A
BUS AMPS: 255A
LOCATION: ELECTRICAL ROOM 145
MAIN SIZE / TYPE: NEMA 1
VOLT/PHASE: 208Y/120V, 3PH, 4W
MOUNTING: SURFACE
AFC VALUE: 30,955A
AFC RATING: 65,000A SERIES RATED

PANELBOARD D
BUS AMPS: 255A
LOCATION: GUEST LAUNDRY 142
MAIN SIZE / TYPE: NEMA 1
VOLT/PHASE: 208Y/120V, 3PH, 4W
MOUNTING: RECESSED
AFC VALUE: 30,955A
AFC RATING: 20,000A SERIES RATED

PANELBOARD B
BUS AMPS: 255A
LOCATION: ELECTRICAL ROOM 145
MAIN SIZE / TYPE: NEMA 1
VOLT/PHASE: 208Y/120V, 3PH, 4W
MOUNTING: SURFACE
AFC VALUE: 30,955A
AFC RATING: 65,000A SERIES RATED

PANELBOARD G (TYPICAL OF 122 REQUIRED)
BUS AMPS: 125A
LOCATION: GUEST ROOMS
MAIN SIZE / TYPE: NEMA 1
VOLT/PHASE: 208Y/120V, 1PH, 3W
MOUNTING: RECESSED
AFC VALUE: 36,799A
AFC RATING: 40,000 SERIES RATED

PANELBOARD C
BUS AMPS: 100A
LOCATION: UTILITY ROOM 343
MAIN SIZE / TYPE: NEMA 1
VOLT/PHASE: 208Y/120V, 3PH, 4W
MOUNTING: SURFACE
AFC VALUE: 3,680A
AFC RATING: 10,000A SERIES RATED

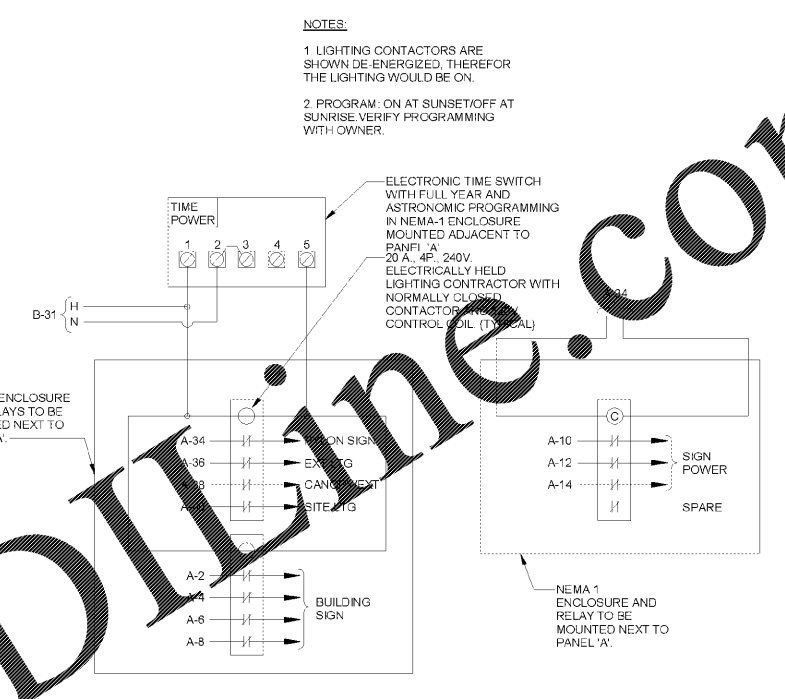

NOTES:
1 LIGHTING CONTACTORS ARE SHOWN ENERGIZED, THEREFOR THE LIGHTING WOULD BE ON.
2 PROGRAM ON AT SUNSET/OFF AT SUNRISE. VERIFY PROGRAMMING WITH OWNER.

1 EXTERIOR LIGHTING CONTROL
SCALE: NOT TO SCALE

SYMBOL LEGEND
SYMBOL DESCRIPTION MOUNTING
(A) FLUORESCENT FIXTURE & FIXTURE LETTER CEILING

SPECIAL OUTLET SCHEDULE
SYMBOL DESCRIPTION
V thru W THRU WALL OUTLET 15A 2 POLE GROUNDING RECEPTACLE

ELECTRICAL GENERAL NOTES

- 1. VERIFY ALL OUTLET LOCATIONS ON THE JOB PRIOR TO ROUGH-IN.
2. REFER TO RELATED ARCHITECTURAL, MECHANICAL, AND STRUCTURAL DRAWINGS FOR RELATED INFORMATION.
3. REFER TO THE SPECIFICATIONS FOR DATA NOT ON THE DRAWINGS.
4. COORDINATE OUTLET BOX LOCATIONS WITH MASONRY TO MINIMIZE CUTTING OF BRICK BLOCK.

LIGHT FIXTURE SCHEDULE
FIXTURE TAG MANUFACTURER MODEL NUMBER NO. LAMP TYPE VOLTAGE TOTAL VA FINISH MOUNTING REMARKS

WOODSPRING SUITES
CYPRESS CREEK, FLORIDA
Pasco County Cypress Creek, FL
1417 West 95th Street • Lenexa, Kansas 66151
P 913 322 5150 • F 913 322 5155
www.AcertusGroup.com

WOODSPRING SUITES
CYPRESS CREEK, FLORIDA
Pasco County Cypress Creek, FL

Proj. No.: 078761
Date: 10/05/2018
Sheet Name: ELECTRICAL PANELS AND SCHEDULES