


2 SECOND FLOOR ELECTRICAL PLAN
SCALE: 1/8" = 1'-0"



1 FIRST FLOOR ELECTRICAL PLAN
SCALE: 1/8" = 1'-0"

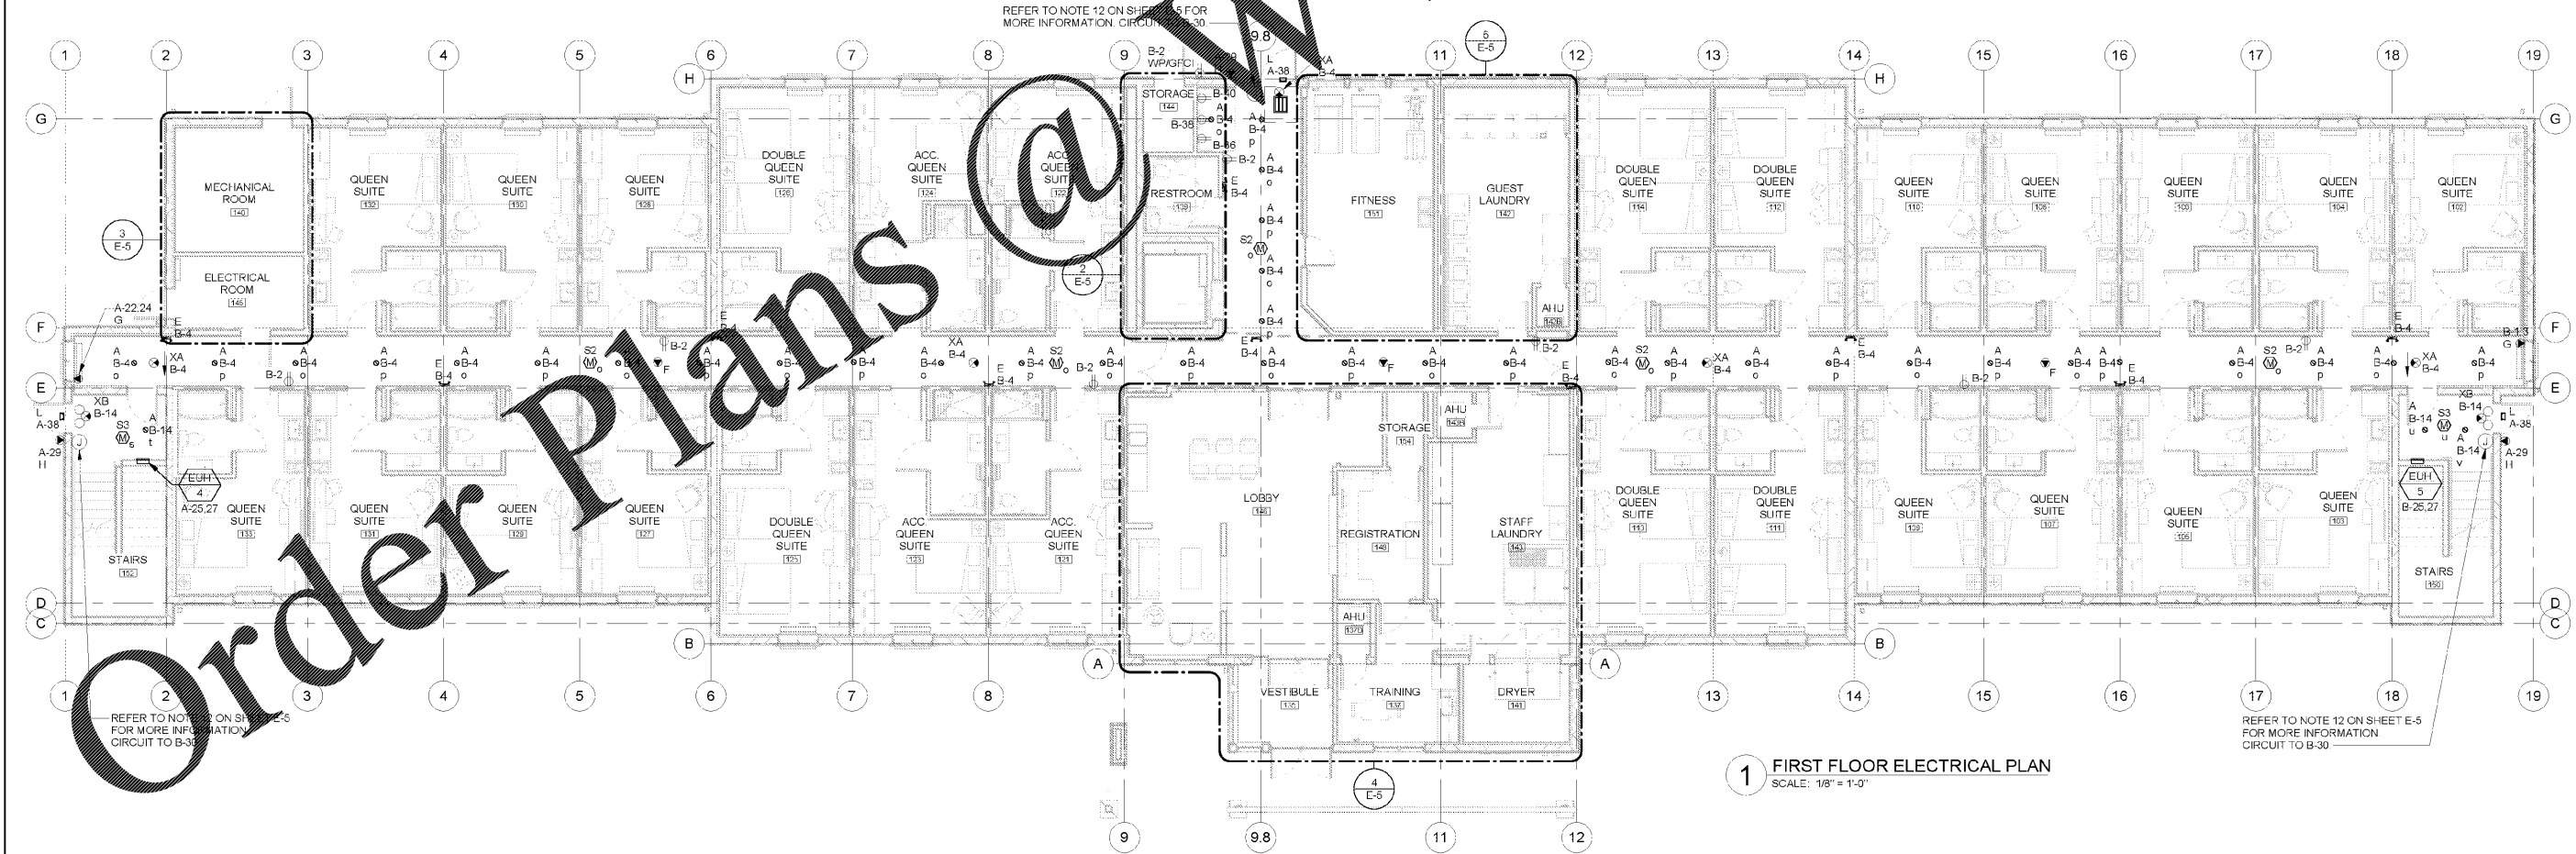

377 Northridge Road
Suite 300
Atlanta, GA 30350
770.391.4095
FAX: 770.391.4104



14817 West 95th Street • Lenexa, Kansas 66156
P 913 322 5150 • F 913 322 5155
www.AcertusGroup.com

WOODSPRING SUITES
CYPRESS CREEK, FLORIDA
Pasco County
Cypress Creek, FL

Issues & Revisions:

Proj. No.: 078761
Date: 10/05/2018

Sheet Name:
ELECTRICAL PLANS -
FIRST AND SECOND
FLOOR

E-3

60% OWNER REVIEW | 09.10.18

11/2/2018 5:00:43 PM