


11/2/2018 5:01:02 PM

Order Plans @

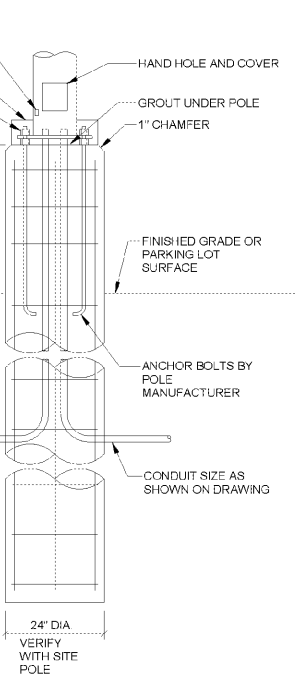

SITE LIGHT FIXTURE SCHEDULE									
FIXT LTR	MANUFACTURER	CATALOG NUMBER	LAMPS		FIXT VOLT	FINISH	MOUNTING	TOTAL VA	REMARKS
			NO.	TYPE					
SA	LSI	XLCS 3 LED HO 50 UE BRZ	-	LED W/UNIT	120	BRONZE	30' POLE	140	SITE LIGHTING HEAD
POLE		4SQB3 S11G 30S BRZ POLE							

LIGHT FIXTURE SCHEDULE NOTES

1. VERIFY LAMP COLOR WITH ARCHITECT PRIOR TO ORDERING.
2. MANUFACTURERS LISTED IN THIS SCHEDULE OR BY WRITTEN ADDENDUM WILL BE THE ONLY APPROVED MANUFACTURERS TO BID THE LIGHTING FIXTURES FOR THIS PROJECT. CONTRACTORS AND SUPPLIERS USING PRICING FROM MANUFACTURERS NOT LISTED ON SCHEDULE OR BY ADDENDUM DO SO AT THEIR OWN RISK.
3. FIXTURES BY THE FOLLOWING MANUFACTURERS EQUAL TO THOSE SPECIFIED AND APPROVED BY THE ENGINEER WILL BE ACCEPTABLE: FIXTURE EQUALS SHALL BE MANUFACTURED THE SAME AS SPECIFIED UNITS, I.E., ENCLOSED SPRING LOADED LATCHES, ALUMINUM DOORS, POST PAINTED FINISH.
4. PROVIDE POLE AS NOTED, POLE TYPE AND EXACT SPEC MUST MEET ALL CODE REQUIREMENTS FOR LOCAL WIND LOAD CATEGORY. PROVIDE POLE WITH VIBRATION DAMPER.

- GENERAL NOTES
1. VERIFY PAD LOCATION, DIMENSIONS AND ALL REQUIREMENTS WITH LOCAL UTILITY CO. OPENINGS ARE BASED ON ABBB & GE TRANSFORMERS. CHECK WITH LOCAL UTILITY CO. PRIOR TO CONSTRUCTION OF PAD.
  2. THE TOP OF THE TRANSFORMER PAD SHALL RECEIVE A SMOOTH TROWEL FINISH. THE CORNERS AND EDGES SHALL BE ROUNDED OR BEVELLED.
  3. IF THE TRANSFORMER PAD IS INSTALLED IN AN AREA SUBJECT TO VEHICULAR TRAFFIC, THE INSTALLATION SHALL BE PROTECTED PER UTILITY CO. STANDARDS.
  4. THE CONDUIT OPENING SHALL BE FREE AND CLEAR OF CONCRETE.
  5. THE MAXIMUM NUMBER OF CONDUITS ON SECONDARY SERVICE SHALL NOT EXCEED THE MAXIMUM NUMBER ALLOWED BY THE UTILITY CO. VERIFY WITH UTILITY CO. PRIOR TO ROUGH-IN.
  6. PROVIDE PROPER CLEARANCE AROUND TRANSFORMER FROM ANY ABOVE GROUND OBSTRUCTIONS. VERIFY REQUIREMENTS WITH LOCAL UTILITY CO. AND A.U.


2 POLE BASE DETAIL

COORDINATE STRUCTURAL REQUIREMENTS OF POLE BASE WITH STRUCTURAL ENGINEER.

VERIFY ALL PRIMARY AND SECONDARY ELECTRICAL SERVICE ENTRANCE REQUIREMENTS WITH LOCAL UTILITY CO. CODES AND ORDINANCES PRIOR TO BID. INCLUDE ALL ASSOCIATED COSTS.

PROVIDE AND INSTALL (2) 3" CONDUITS FROM BUILDING TO PROPERTY LINE AS REQUIRED. ONE FOR TELEPHONE SERVICE AND ONE FOR CATV SERVICE. VERIFY ROUTING AND REQUIREMENTS WITH LOCAL SERVICE PROVIDERS PRIOR TO ROUGH-IN. SEE SPECIFICATIONS FOR ADDITIONAL REQUIREMENTS.

- PYLON SIGN NOTES:
1. CONTRACTOR TO PROVIDE AND INSTALL ALL CONDUIT, WIRE, AND DEVICES REQUIRED FOR MONUMENT SIGN. VERIFY LOCATION AND REQUIREMENTS WITH SIGN MANUFACTURER PRIOR TO ROUGH-IN.
  2. SIGN LOCATION UNDETERMINED AT TIME OF DESIGN. CONTRACTOR TO VERIFY EXACT LOCATION PRIOR TO BID.
  3. PROVIDE GROUNDING AND BONDING PER MANUFACTURER'S (WATCHFIRE) AND LOCAL REQUIREMENTS.
  4. COORDINATE WITH SIGN VENDOR FOR ALL CONTROL REQUIREMENTS.

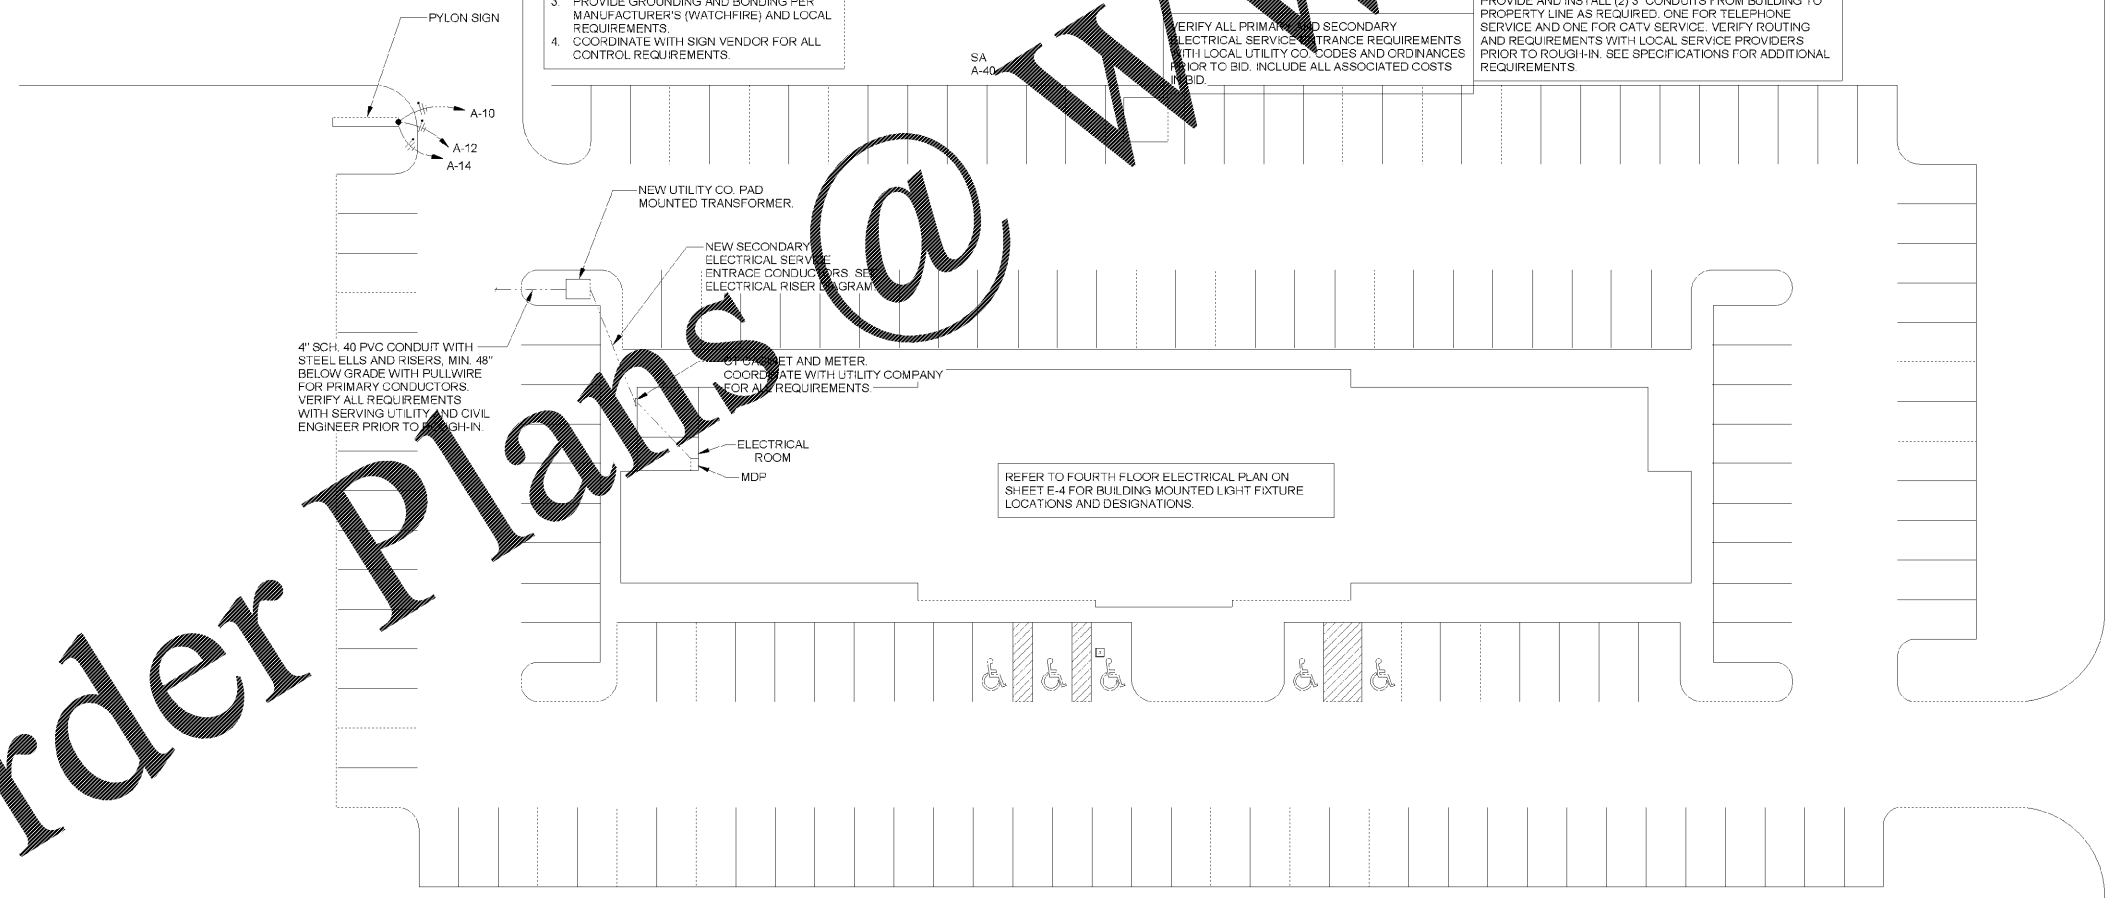

1 SITE PLAN

SCALE: 1" = 20'-0"



377 Northridge Road  
Suite 300  
Atlanta, GA 30350  
770.391.4095  
FAX: 770.391.4104



14817 West 95th Street • Lenexa, Kansas 66215  
P 913 322 5150 • F 913 322 5155  
www.AcertusGroup.com

WOODSPRING SUITES  
CYPRESS CREEK, FLORIDA  
Pasco County  
Cypress Creek, FL

Issues & Revisions:

Proj. No.: 078761  
Date: 10/05/2018

Sheet Name:  
ELECTRICAL SITE PLAN

E-7