

BLDG PLAN GENERAL NOTES

1. SEE LIFE SAFETY PLANS FOR ALL WALL AND STRUCTURAL STEEL FIRE RATINGS
2. SEE LIFE SAFETY PLANS FOR ALL FIRE EXTINGUISHER LOCATIONS
3. ALL GYP BOARD AT WET WALL LOCATIONS AND POOL AREA TO BE MOISTURE RESISTANT
4. GO TO VERIFY THAT ALL MECHANICAL EXHAUST VENTS ARE A PROPER DISTANCE AWAY FROM ALL MECHANICAL AIR INTAKE VENTS PER ALL APPLICABLE CODES PRIOR TO INSTALLATION. SEE MEP DWGS FOR FURTHER INFORMATION



WINDSOR AUGHTRY

HOME2 ASHEVILLE

380 AIRPORT RD.
ASHEVILLE, NC 28704

SHEET ISSUE
07/30/18
FOR CONSTRUCTION


Revisions		
Number	Description	Date

PRINCIPAL IN CHARGE: BZ
PROJECT ARCHITECT: BZ
DRAWN BY: BT

SHEET TITLE:
LEVEL 4 FLOOR PLAN

SHEET NO. PROJ. NO.
017378.00

A104

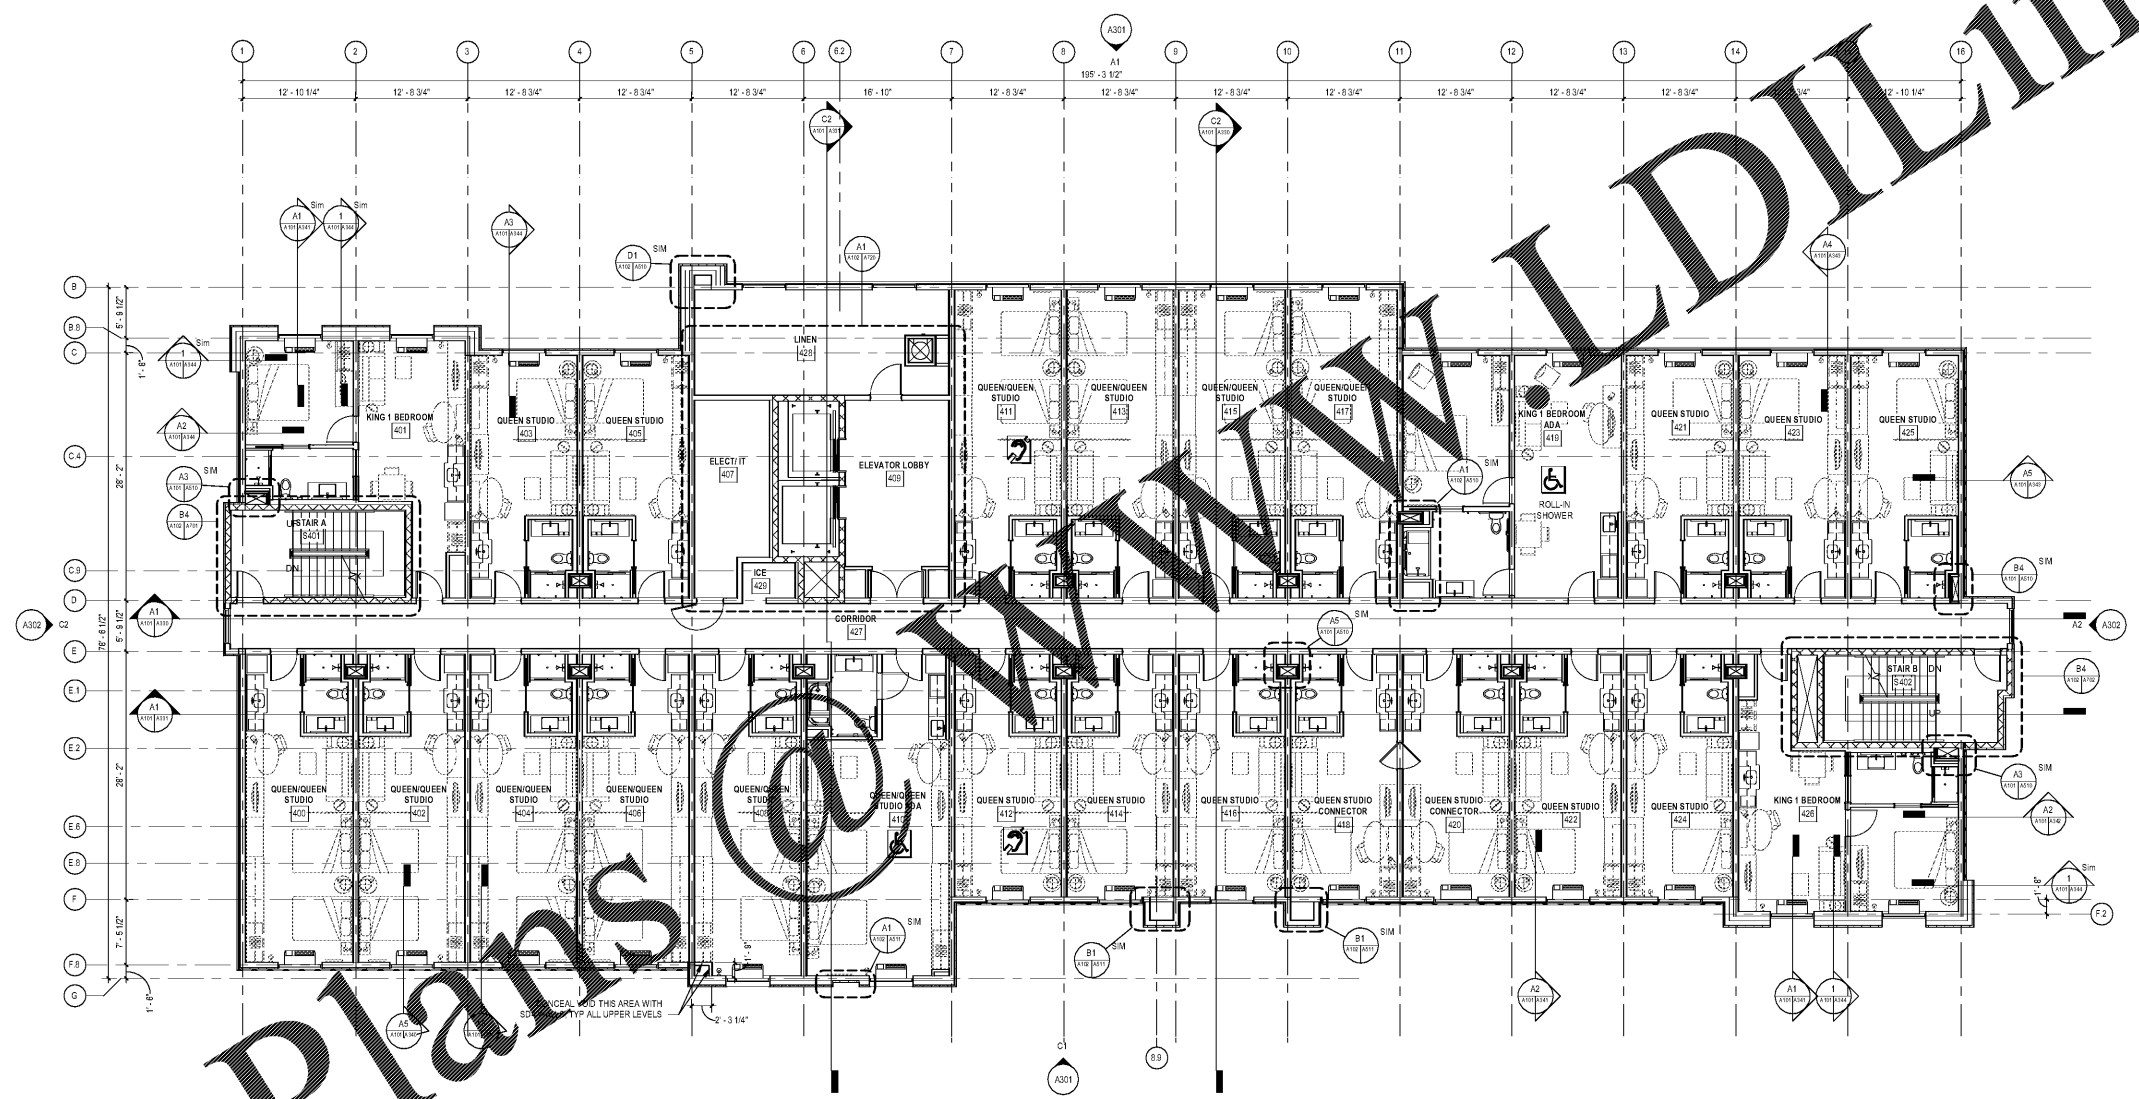

LEVEL 4
1/8" = 1'-0"

Order Plans @ www.dline.com

www.dline.com