


BLDG PLAN GENERAL NOTES

- SEE LIFE SAFETY PLANS FOR ALL WALL AND STRUCTURAL STEEL FIRE RATINGS
- SEE LIFE SAFETY PLANS FOR ALL FIRE EXTINGUISHER LOCATIONS
- ALL GYP BOARD AT WET WALL LOCATIONS AND POOL AREA TO BE MOISTURE RESISTANT
- GO TO VERIFY THAT ALL MECHANICAL EXHAUST VENTS ARE A PROPER DISTANCE AWAY FROM ALL MECHANICAL AIR INTAKE VENTS PER ALL APPLICABLE CODES PRIOR TO INSTALLATION. SEE MEP DWGS FOR FURTHER INFORMATION.

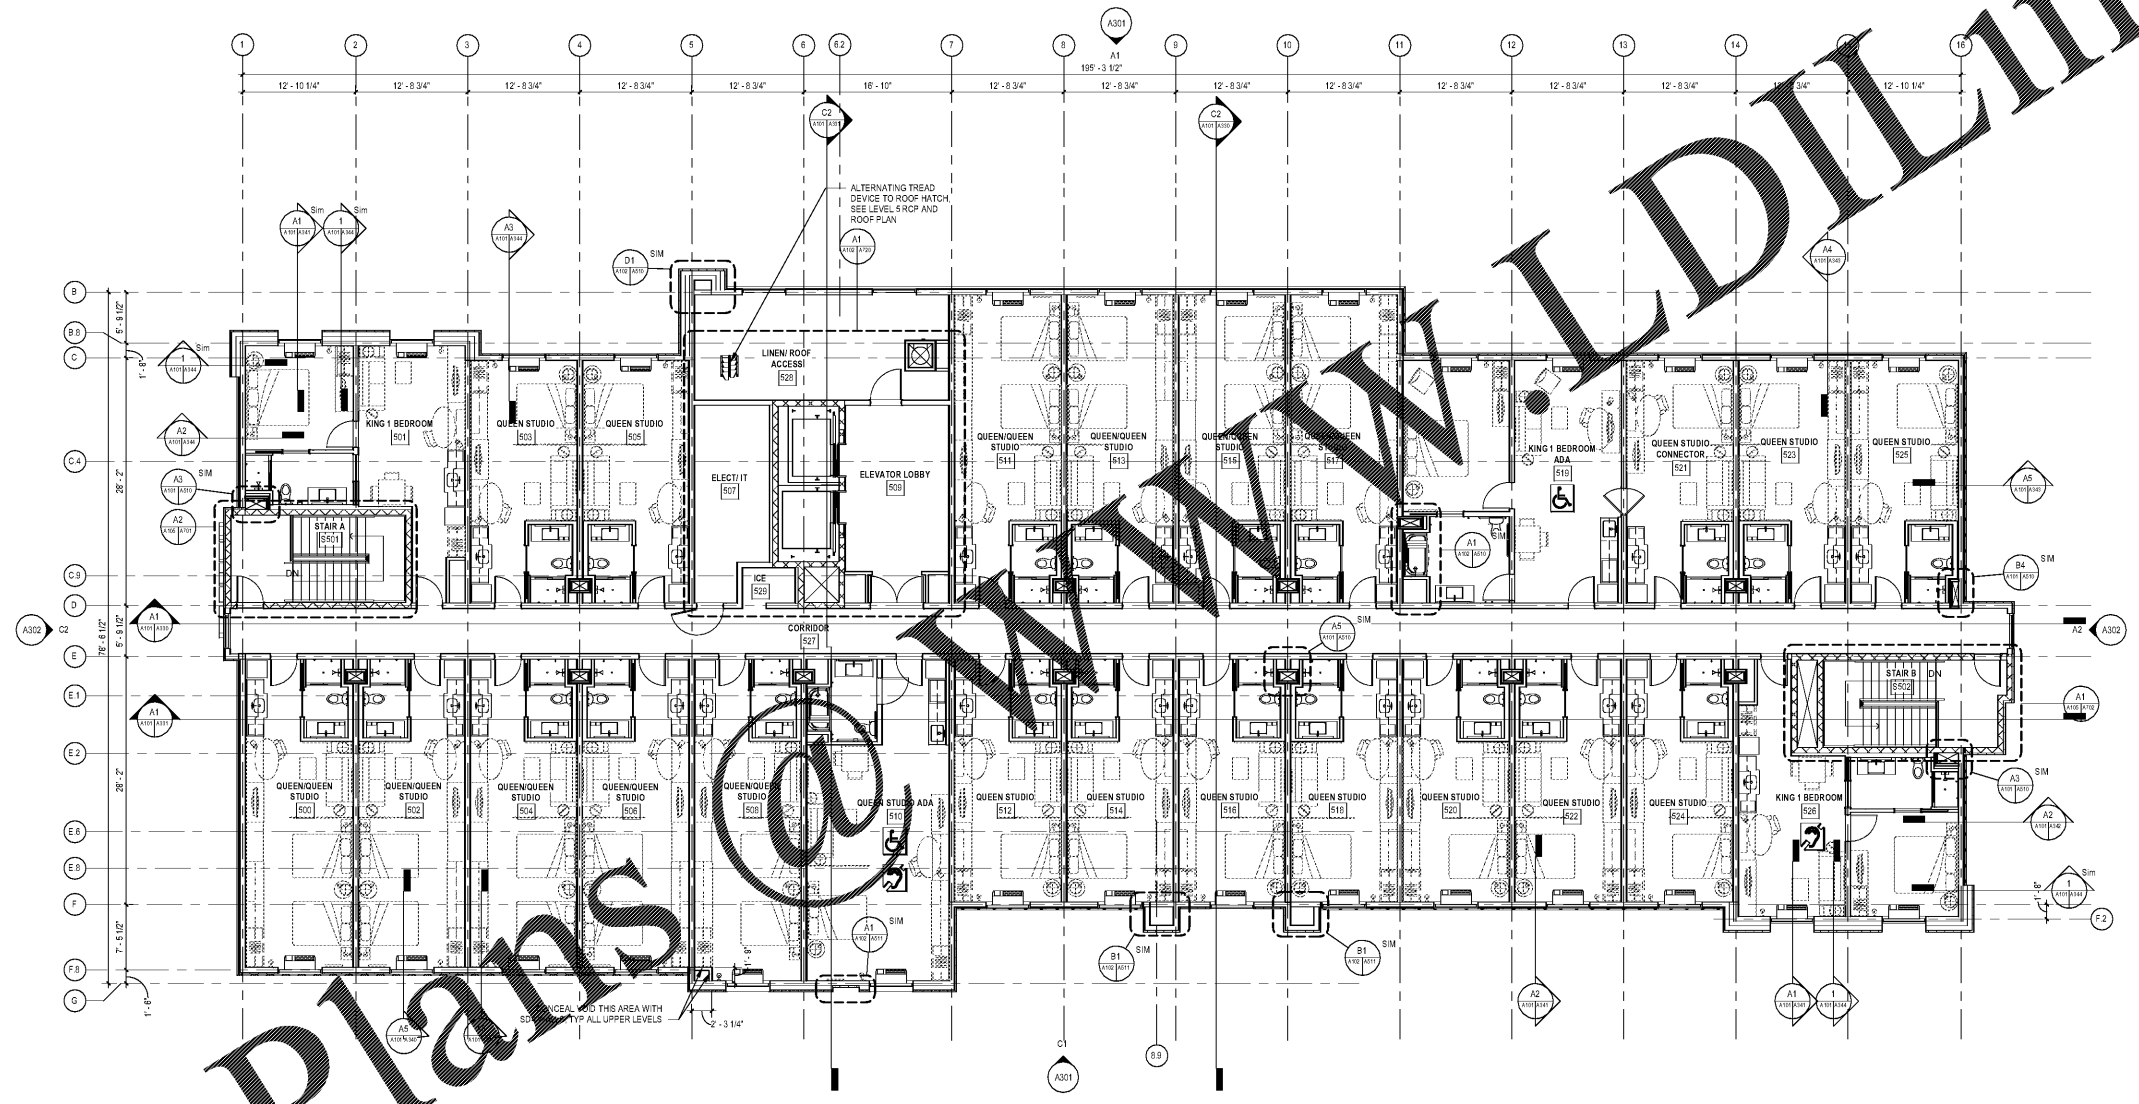

**LEVEL 5**  
1/8" = 1'-0"

WINDSOR AUGHTRY  
HOME2 ASHEVILLE

390 AIRPORT RD.  
ASHEVILLE, NC 28704

SHEET ISSUE  
07/30/18  
FOR CONSTRUCTION

Revisions		
Number	Description	Date

PRINCIPAL IN CHARGE: BZ  
PROJECT ARCHITECT: BZ  
DRAWN BY: BT

SHEET TITLE:  
**LEVEL 5 FLOOR PLAN**

SHEET NO.  
**A105**

PROJ. NO.  
017378.00

Order Plans