


MECHANICAL KEY NOTES:

1. HARD WIRED THERMOSTAT MOUNTED AT 48" A.F.F. COORDINATE ALL WIRING WITH ELECTRICAL CONTRACTOR.
2. EXHAUST DUCT FROM CENTRIFUGAL EXHAUST FAN ON ROOF ROUTED DOWN IN SHAFT OPENING. SEE SECTION DETAILS 2 THRU 6 ON SHEET M002 FOR MORE INFORMATION.
3. SUPPLY DUCT ROUTED FROM ROOFTOP MAU ON ROOF. SEE SECTION DETAIL 1 ON SHEET M002 FOR MORE INFORMATION.
4. PTHP TO BE MOUNTED IN WALL PER MANUFACTURER'S RECOMMENDATION. ROUTE CONDENSATE LINE FROM PTHP DOWN IN WALL AND DISCHARGE ON SPLASH BLOCK. SEE DETAILS 4 AND 5 ON SHEET M004 FOR MORE INFORMATION.
5. BOTTOM OF WALL CAP MINIMUM 9' A.F.F.
6. PTHP UNIT CONDENSATE PIPING TO BE ROUTED TO HUB DRAIN BENEATH UNIT.

**mcmilian
pazdan
smith**
ARCHITECTURE

CONSULTANT LOGO

DEVITA
ATLANTA CHARLOTTE GREENVILLE
RICHMOND
877.4.DEVITA • info@devitainc.com
Devita & Associates, Inc. Project: 17239
NC Firm License # C-0819
ELZ Checked By: DV

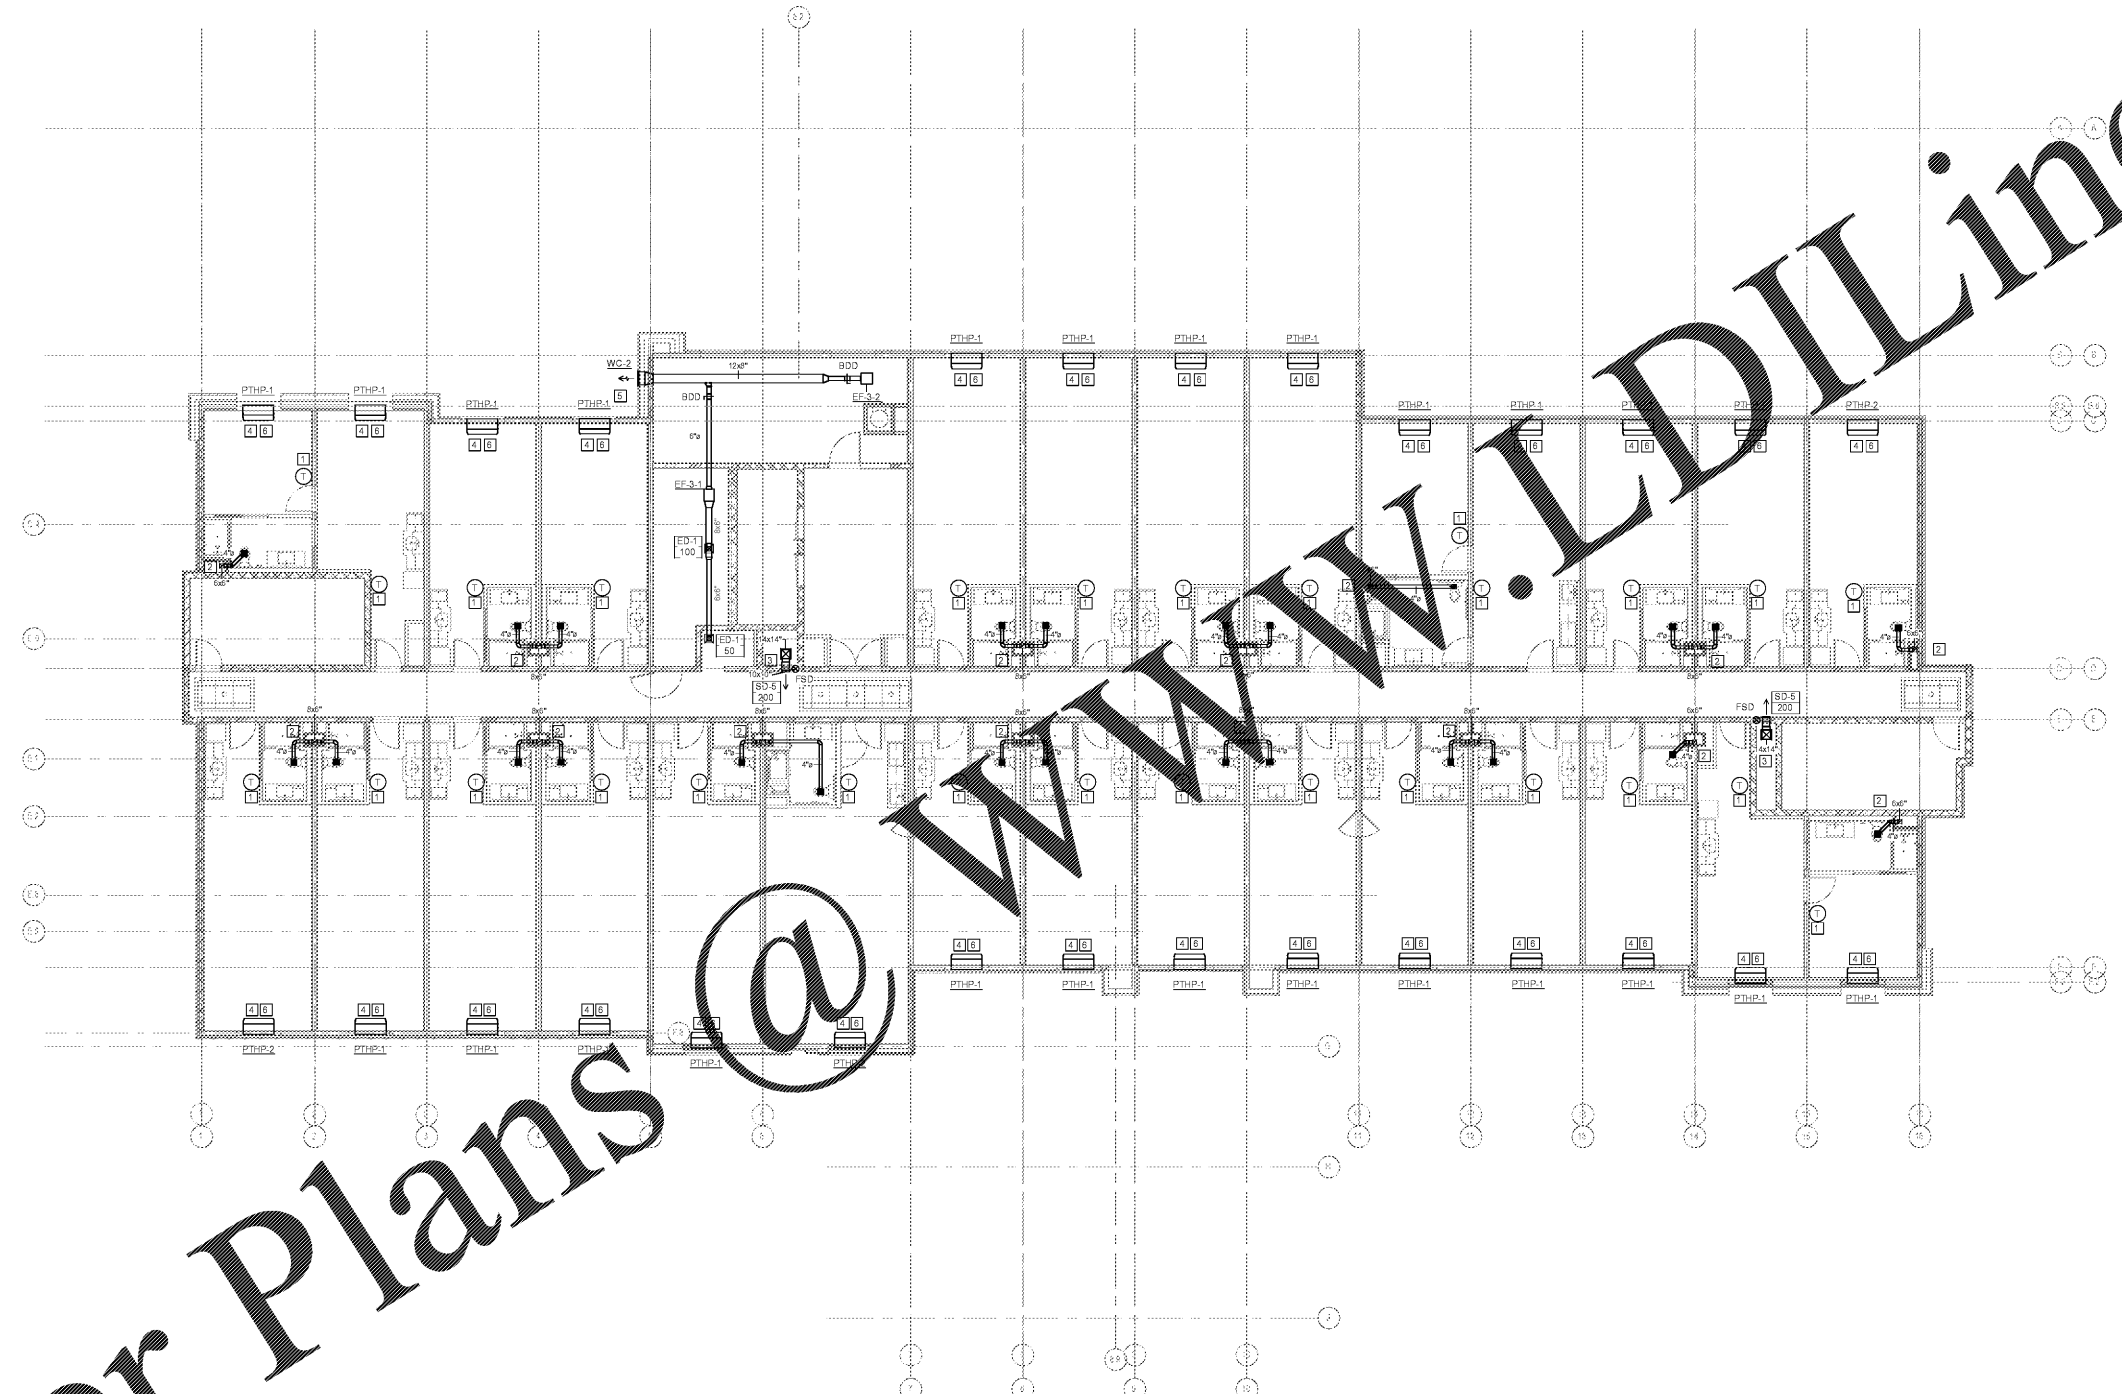

1 LEVEL 3 RCP FLOOR PLAN (HVAC)
M103 1/8" = 1'-0"

WINDSOR AUGHTRY
HOME2 ASHEVILLE
380 AIRPORT RD.
ASHEVILLE, NC 28704

SHEET ISSUE:
07/30/18
FOR CONSTRUCTION

Revisions		
Number	Description	Date

PRINCIPAL IN CHARGE:
PROJECT ARCHITECT:
DRAWN BY:
SHEET TITLE:
**LEVEL 3 FLOOR
PLAN - HVAC**

SHEET NO. PROJ. NO.
M103 017878.00

Order Plans @ www.wldline.com