





MECHANICAL KEY NOTES: □  
1. PROVIDE UV PROTECTIVE COATING/COVERING ON ALL ELASTOMERIC PIPE INSULATION WHERE EXPOSED TO SUNLIGHT

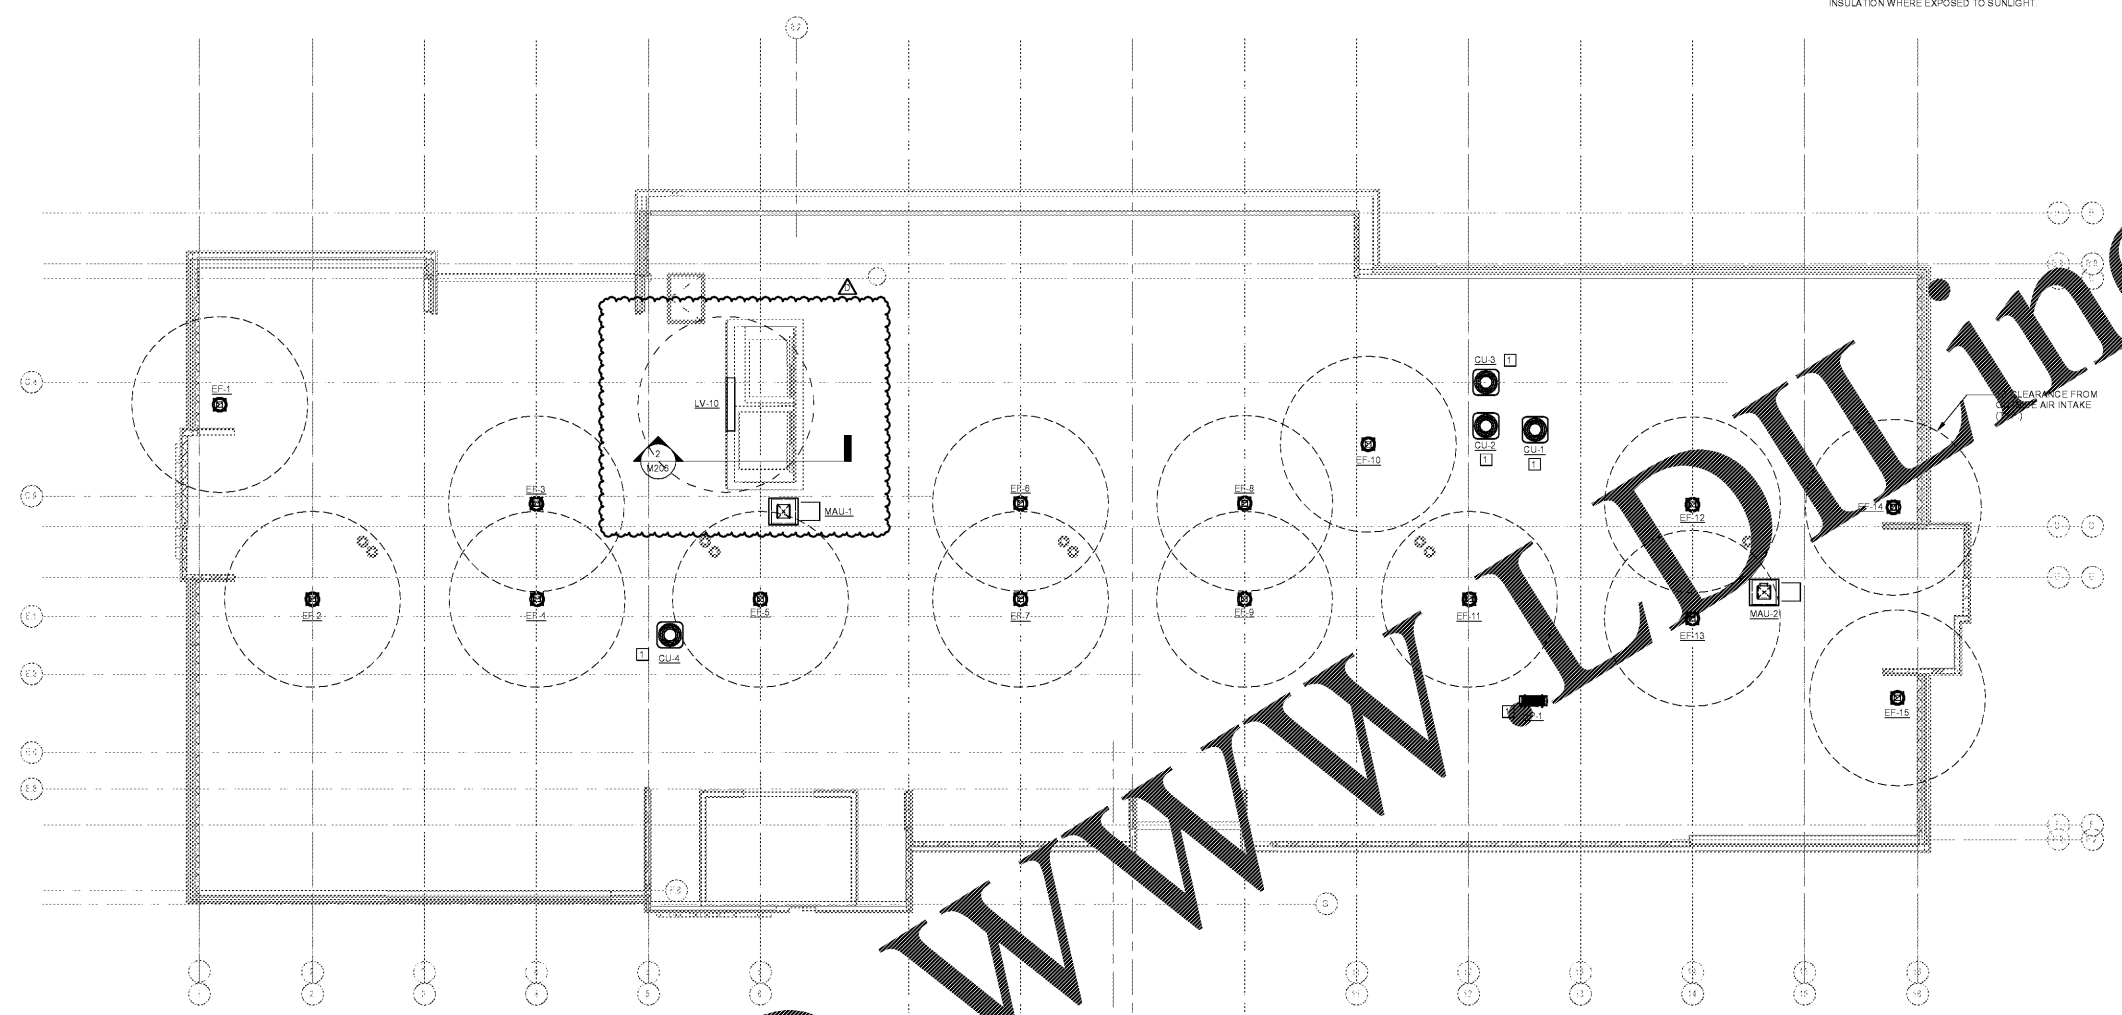

1 HVAC ROOF PLAN  
M206 1/8" = 1'-0"

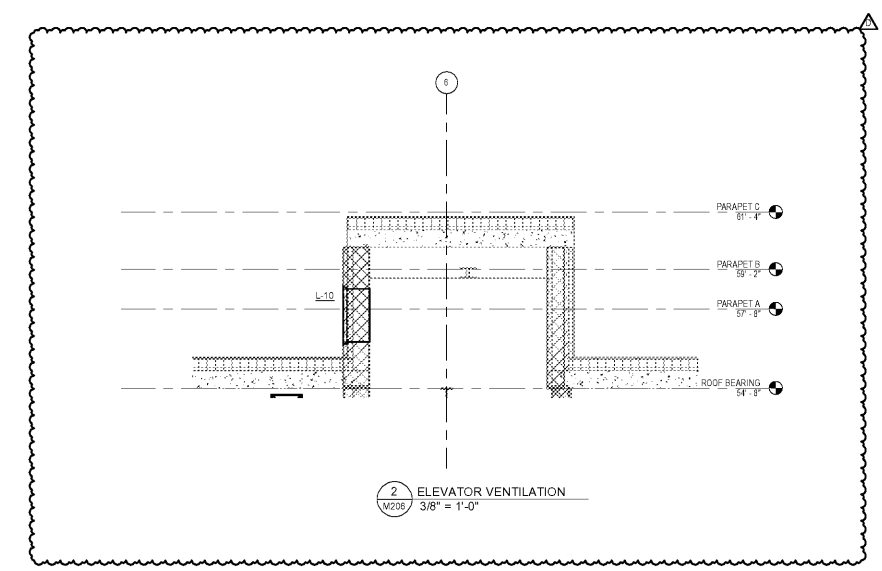

2 ELEVATOR VENTILATION  
M206 3/8" = 1'-0"

WINDSOR AUGHTRY  
HOME2 ASHEVILLE  
380 AIRPORT RD.  
ASHEVILLE, NC 28704

SHEET ISSUE:  
07/30/18  
FOR CONSTRUCTION

Revisions		
Number	Description	Date
D	Adjustment 4: SIG Question Response	10/02/18

PRINCIPAL IN CHARGE:  
PROJECT ARCHITECT:  
DRAWN BY:  
SHEET TITLE:  
OVERALL HVAC  
ROOF PLAN

SHEET NO. PROJ. NO.  
017878.00

M206

Order Plans @ [www.LDOnline.com](http://www.LDOnline.com)

www.LDOnline.com