


GENERAL NOTES:
 A. REFER TO SHEET E003 FOR SITE LIGHTING SPECIFICATION

- KEYED NOTES: ◆
- ROUTE CIRCUIT THROUGH LIGHTING CONTROLS. REFERS TO DETAILS ON SHEET E001.
 - GAS FIRE PIT. COORDINATE WITH CIVIL AND MANUFACTURER FOR EXACT LOCATION AND REQUIREMENTS.
 - LIGHTING FOR FLAG POLE. COORDINATE FLAG POLE LOCATION WITH G.C. PRIOR TO ROUGH-IN.
 - PROVIDE CONNECTION TO GENERATOR BLOCK HEATER AS REQUIRED. COORDINATE ROUTING IN FIELD. CONNECT TO CIRCUIT INDICATED.
 - PROVIDE CONNECTION TO BATTERY CHARGER BLOCK HEATER AS REQUIRED. COORDINATE ROUTING IN FIELD. CONNECT TO CIRCUIT INDICATED.
 - PROVIDE 1" CONDUIT FROM ATS TO GENERATOR FOR CONTROL WIRING.

mcmilian
 pazdan
 smith
 ARCHITECTURE

ATLANTA, CHARLOTTE, GREENVILLE
 877.4.DEVITA
 devita.com
 Devita & Associates, Inc. Project: 17239
 NC State License # C-0819
 MS Checked By: RAG

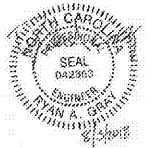

WINDSOR AUGHTRY

HOME2 ASHEVILLE

380 AIRPORT RD.
 ASHEVILLE, NC 28704


SHEET ISSUE
 07/30/18
 FOR CONSTRUCTION

Revisions

| Number | Description | Date |
|--------|-------------|------|
| | | |

PRINCIPAL IN CHARGE
 PROJECT ARCHITECT
 DRAWN BY
 SHEET TITLE
ELECTRICAL SITE PLAN

SHEET NO. PROJ. NO.
 E100 017378.00

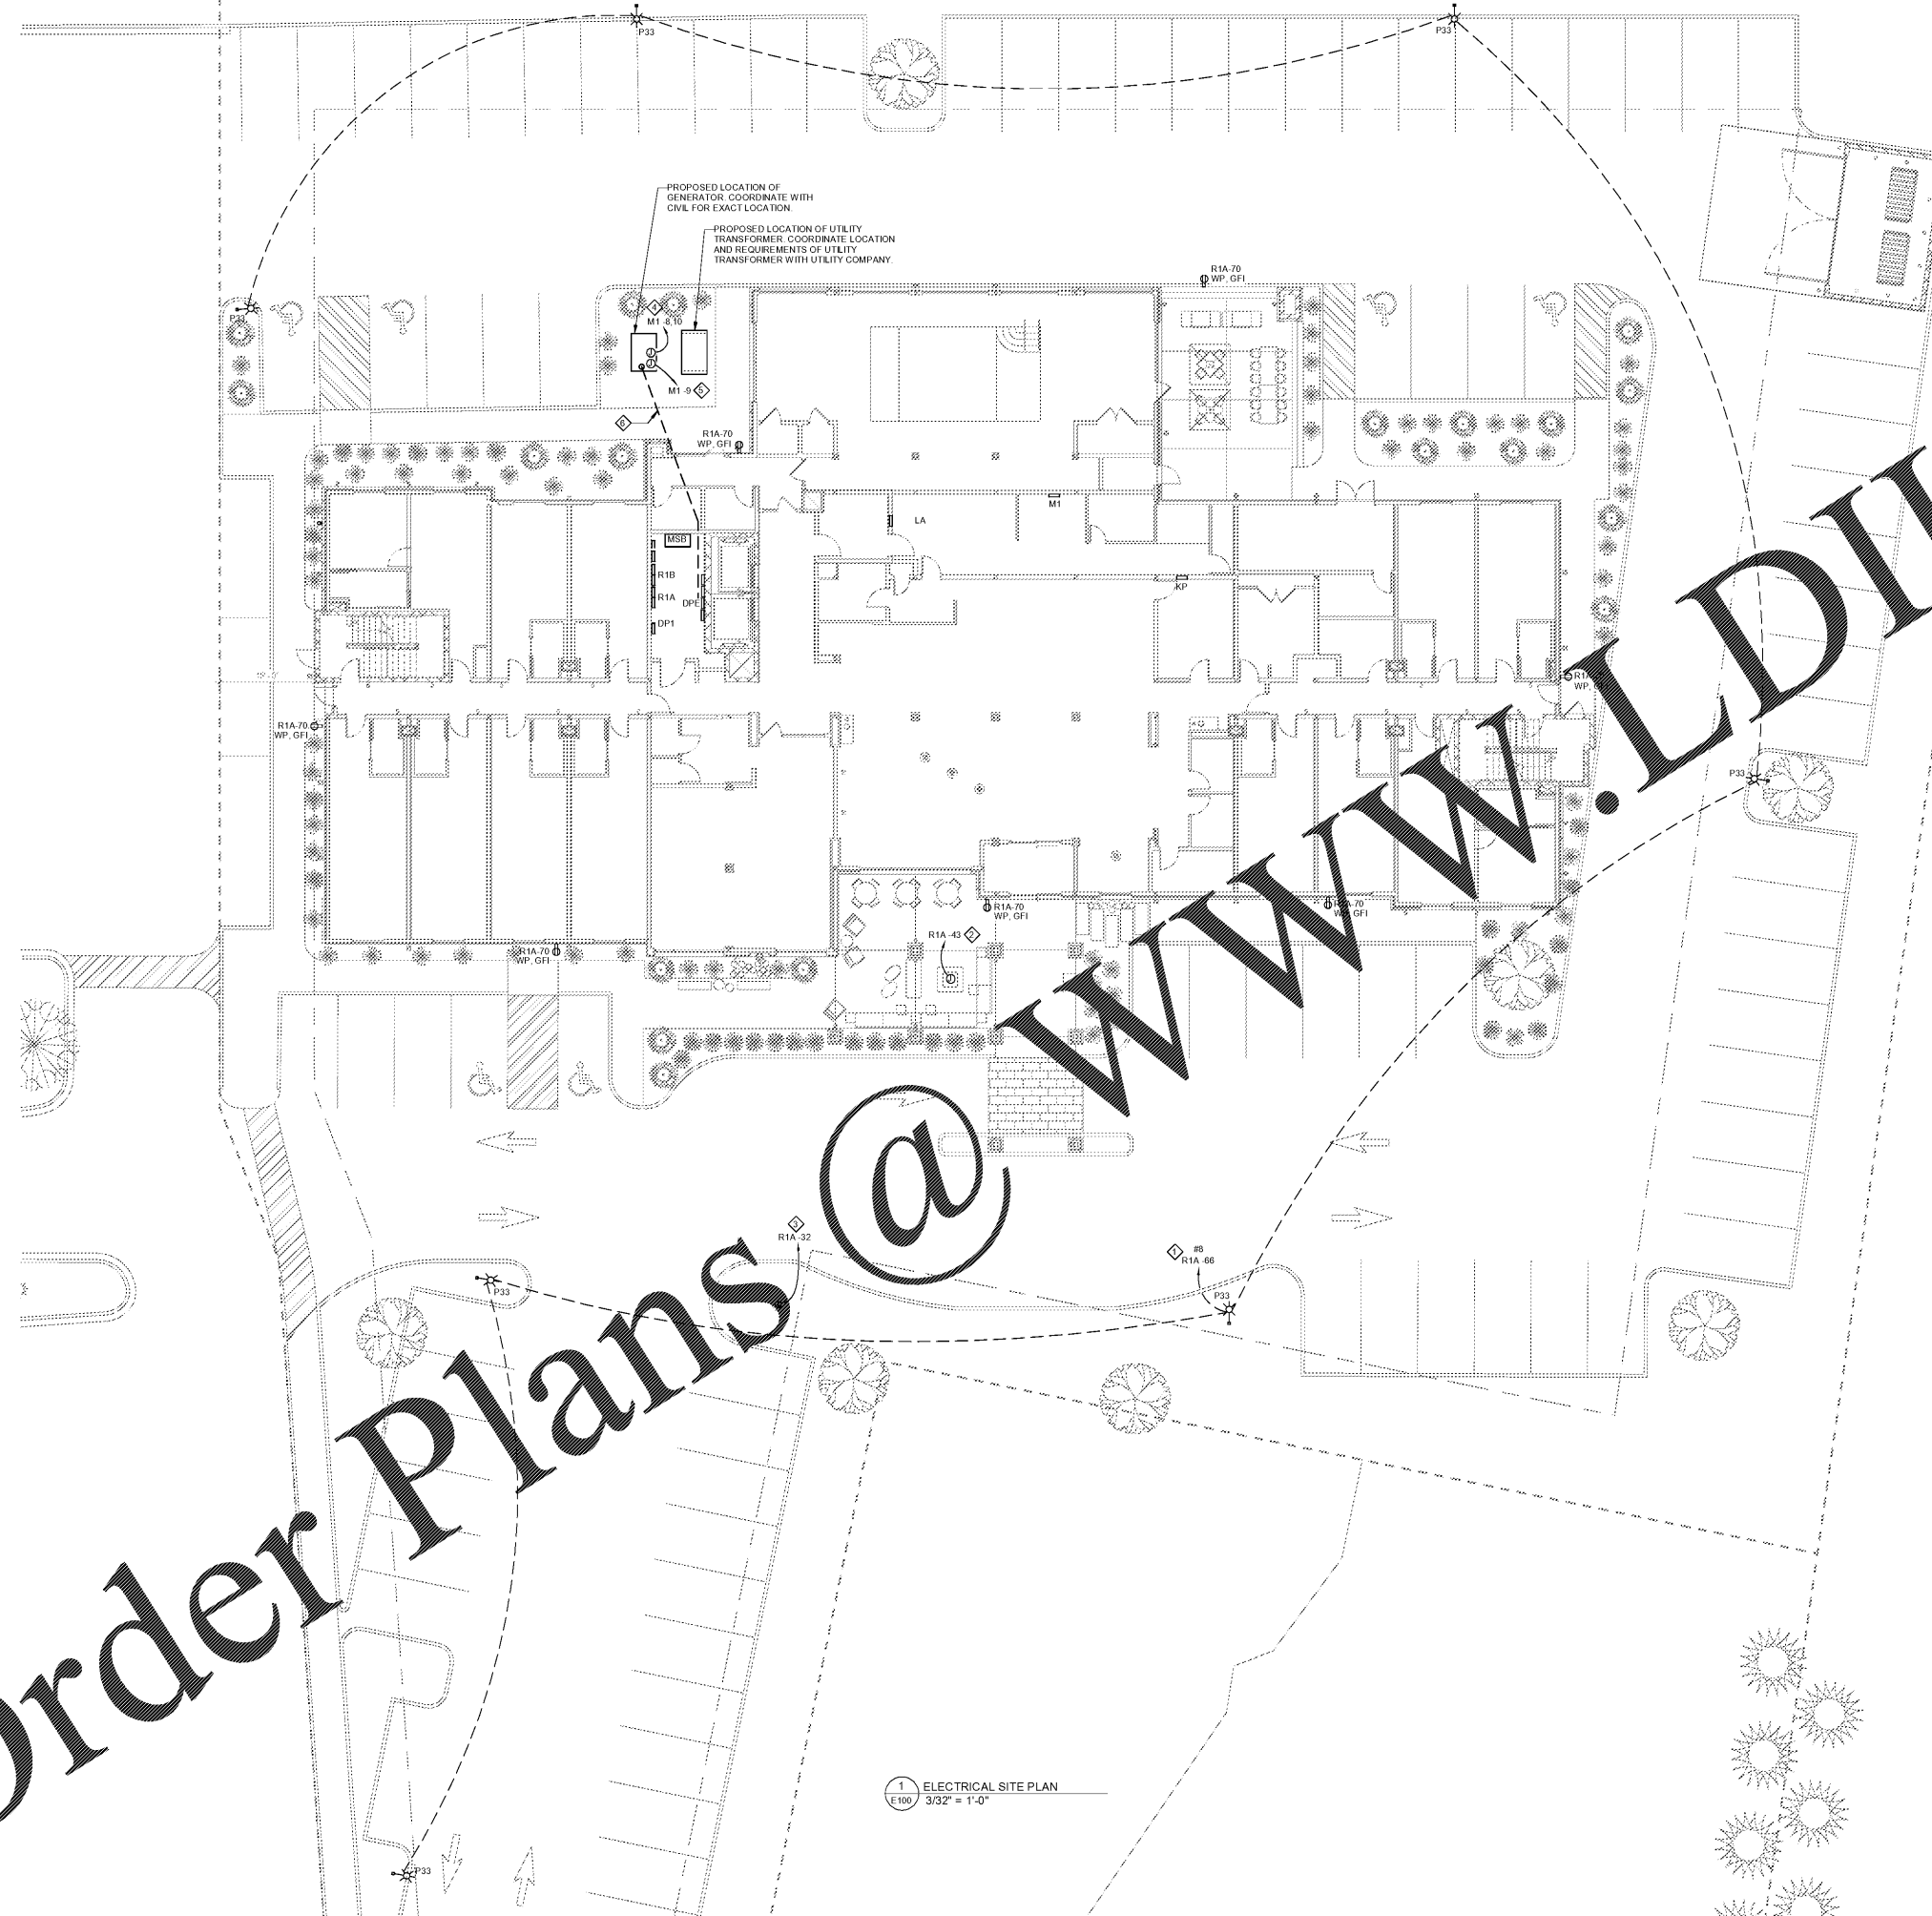

Order Plans @ www.LDILine.com

www.LDILine.com