


LOAD	PANEL	CKT
300		
PTHP-2 Q/Q 300	DP3	14,16
BATH Q/Q 300	R3B	1
MICROWAVE Q/Q 300	R3B	3
REFRIG Q/Q 300	R3B	5
LTSREC CKT 1 Q/Q 300	R3B	7
LTSREC CKT 2 Q/Q 300	R3B	9
DISHWASHER Q/Q 300	R3B	11
DISPOSAL Q/Q 300	R3B	13
301		
BATH KING 301	R3A	1
MICROWAVE KING 301	R3A	3
REFRIG KING 301	R3A	5
LTSREC CKT 1 KING 301	R3A	7
LTSREC CKT 2 KING 301	R3A	9
DISHWASHER KING 301	R3A	11
DISPOSAL KING 301	R3A	13
PTHP-1 KING 301 CKT 1	DP3	7,9
PTHP-1 KING 301 CKT 2	DP3	11,13
302		
PTHP-1 Q/Q 302	DP3	18,20
BATH Q/Q 302	R3B	15
MICROWAVE Q/Q 302	R3B	17
REFRIG Q/Q 302	R3B	19
LTSREC CKT 1 Q/Q 302	R3B	21
LTSREC CKT 2 Q/Q 302	R3B	23
DISHWASHER Q/Q 302	R3B	25
DISPOSAL Q/Q 302	R3B	27
303		
BATH QUEEN 303	R3A	15
MICROWAVE QUEEN 303	R3A	17
REFRIG QUEEN 303	R3A	19
LTSREC CKT 1 QUEEN 303	R3A	21
LTSREC CKT 2 QUEEN 303	R3A	23
DISHWASHER QUEEN 303	R3A	25
DISPOSAL QUEEN 303	R3A	27
PTHP-1 QUEEN 303	DP3	15,17
304		
PTHP-1 Q/Q 304	DP3	22,24
BATH Q/Q 304	R3B	29
MICROWAVE Q/Q 304	R3B	31
REFRIG Q/Q 304	R3B	33
LTSREC CKT 1 Q/Q 304	R3B	35
LTSREC CKT 2 Q/Q 304	R3B	37
DISHWASHER Q/Q 304	R3B	39
DISPOSAL Q/Q 304	R3B	41
305		
MICROWAVE QUEEN 305	R3A	31
REFRIG QUEEN 305	R3A	33
LTSREC CKT 1 QUEEN 305	R3A	35
LTSREC CKT 2 QUEEN 305	R3A	37
DISPOSAL QUEEN 305	R3A	41
DISHWASHER QUEEN 305	R3A	39
PTHP-1 QUEEN 305	DP3	19,21
BATH QUEEN 305	R3A	29
306		
PTHP-1 Q/Q 306	DP3	26,28
BATH Q/Q 306	R3B	43
MICROWAVE Q/Q 306	R3B	45
REFRIG Q/Q 306	R3B	47
LTSREC CKT 1 Q/Q 306	R3B	49
LTSREC CKT 2 Q/Q 306	R3B	51
DISHWASHER Q/Q 306	R3B	53
DISPOSAL Q/Q 306	R3B	55
308		
PTHP-1 Q/Q 308	DP3	50,52
BATH Q/Q 308	R3B	57
MICROWAVE Q/Q 308	R3B	59
REFRIG Q/Q 308	R3B	61
LTSREC CKT 1 Q/Q 308	R3B	63
LTSREC CKT 2 Q/Q 308	R3B	65
DISHWASHER Q/Q 308	R3B	67
DISPOSAL Q/Q 308	R3B	69
310		
BATH QUEEN 310	R3B	71
MICROWAVE QUEEN 310	R3B	73
REFRIG QUEEN 310	R3B	75
LTSREC CKT 1 QUEEN 310	R3B	77
LTSREC CKT 2 QUEEN 310	R3B	79
DISHWASHER QUEEN 310	R3B	81
DISPOSAL QUEEN ST 310	R3B	83
PTHP-2 QUEEN 310	DP3	84,86
311		
PTHP-1 Q/Q 311	DP3	23,25
BATH Q/Q 311	R3A	43
MICROWAVE Q/Q 311	R3A	45
REFRIG Q/Q 311	R3A	47
LTSREC CKT 1 Q/Q 311	R3A	49
LTSREC CKT 2 Q/Q 311	R3A	51
DISHWASHER Q/Q 311	R3A	53
DISPOSAL Q/Q 311	R3A	55
312		
PTHP-1 QUEEN 312	DP3	38,40
BATH QUEEN 312	R3B	2
MICROWAVE QUEEN 312	R3B	4
REFRIG QUEEN 312	R3B	6
LTSREC CKT 1 QUEEN 312	R3B	8
LTSREC CKT 2 QUEEN 312	R3B	10
DISHWASHER QUEEN 312	R3B	12
DISPOSAL QUEEN 312	R3B	14
313		
PTHP-1 Q/Q 313	DP3	27,29
BATH Q/Q 313	R3A	57
MICROWAVE Q/Q 313	R3A	59
REFRIG Q/Q 313	R3A	61
LTSREC CKT 1 Q/Q 313	R3A	63
LTSREC CKT 2 Q/Q 313	R3A	65
DISHWASHER Q/Q 313	R3A	67
DISPOSAL Q/Q 313	R3A	69
314		
MICROWAVE QUEEN 324	R3C	5
PTHP-1 QUEEN 314	DP3	44,46
BATH QUEEN 314	R3B	16
MICROWAVE QUEEN 314	R3B	18
REFRIG QUEEN 314	R3B	20
LTSREC CKT 1 QUEEN 314	R3B	22
LTSREC CKT 2 QUEEN 314	R3B	24
DISHWASHER QUEEN 314	R3B	26
DISPOSAL QUEEN 314	R3B	28
315		
PTHP-1 Q/Q 315	DP3	33
BATH Q/Q 315	R3A	43
MICROWAVE Q/Q 315	R3A	45
REFRIG Q/Q 315	R3A	47
LTSREC CKT 1 Q/Q 315	R3A	49
LTSREC CKT 2 Q/Q 315	R3A	51
DISHWASHER Q/Q 315	R3A	53
DISPOSAL Q/Q 315	R3A	55

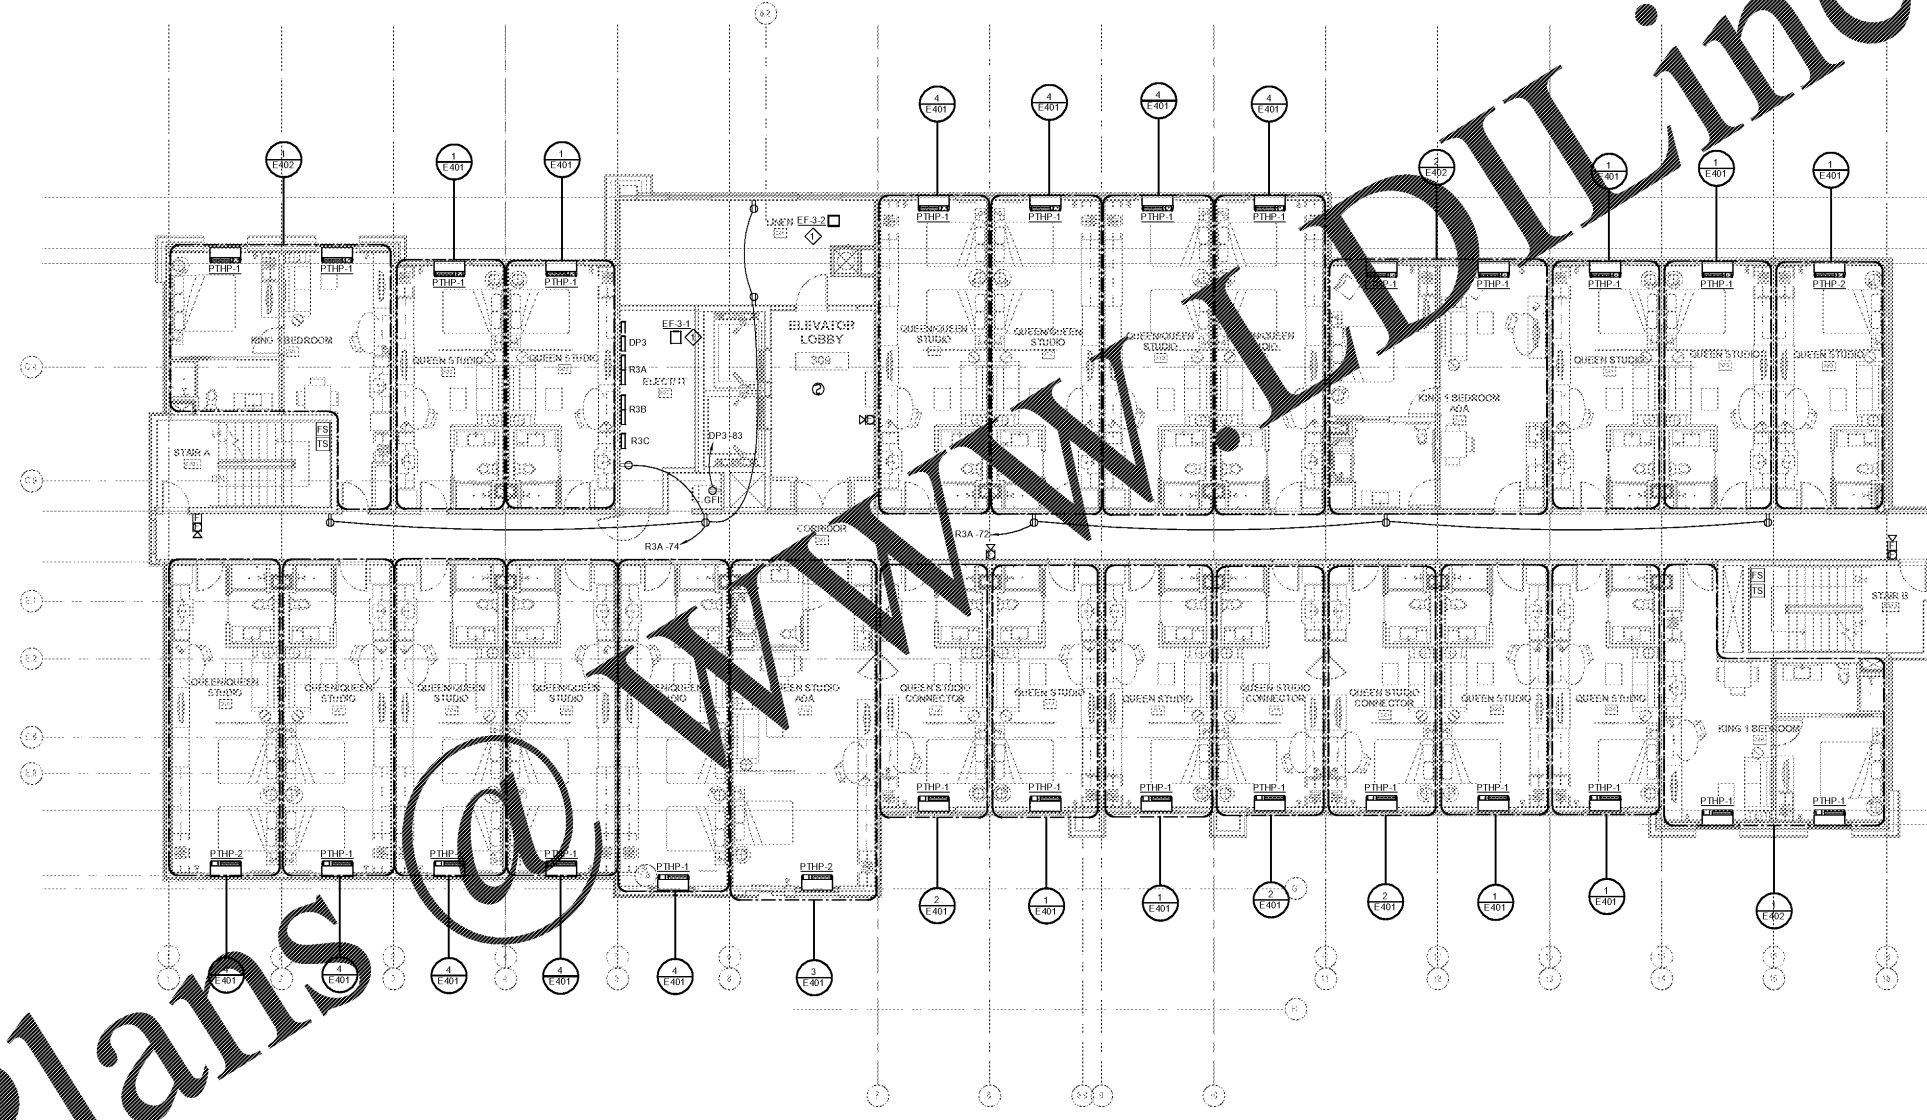

1 LEVEL 3 FLOOR PLAN - POWER  
E109 1/8" = 1'-0"

GENERAL NOTES:  
A. REFER TO MECHANICAL EQUIPMENT SCHEDULE ON SHEET E501 FOR CIRCUITING, FEEDER AND LOCAL DISCONNECT REQUIREMENTS FOR MECHANICAL EQUIPMENT.  
KEYED NOTES:   
1. EXHAUST FAN SHALL RUN 24/7.

mcmillan  
pazdan  
smith  
ARCHITECTURE

ATLANTA CHARLOTTE GREENVILLE  
877.4.DEVITA  
devitaandassociates.com  
Project: 17239  
NC State License # C-0819  
MS Checked By: RAG

SEAL  
042083  
RESIDENTIAL ARCHITECT  
STATE OF NORTH CAROLINA  
RAG

WINDSOR AUGHTRY  
HOMEZ ASHEVILLE  
380 AIRPORT RD.  
ASHEVILLE, NC 28704

SHEET ISSUE:  
07/30/18  
FOR CONSTRUCTION

Number	Description	Date

PRINCIPAL IN CHARGE  
PROJECT ARCHITECT  
DRAWN BY  
SHEET TITLE  
LEVEL 3 FLOOR  
PLAN - POWER

SHEET NO. PROJ. NO.  
017378.90

E103

Order Plans @ www.dline.com