


LOAD	PANEL	CKT
400		
P/THP-2 Q/Q 400	DP4	14,16
BATH Q/Q 400	R4B	1
MICROWAVE Q/Q 400	R4B	3
REFRIG Q/Q 400	R4B	5
LTS/REC CKT 1 Q/Q 400	R4B	7
LTS/REC CKT 2 Q/Q 400	R4B	9
DISHWASHER Q/Q 400	R4B	11
DISPOSAL Q/Q 400	R4B	13
401		
P/THP-1 KING 401 CKT 1	DP4	7,9
P/THP-1 KING 401 CKT 2	DP4	11,13
BATH KING 401	R4A	1
MICROWAVE KING 401	R4A	3
REFRIG KING 401	R4A	5
LTS/REC CKT 1 KING 401	R4A	7
LTS/REC CKT 2 KING 401	R4A	9
DISHWASHER KING 401	R4A	11
DISPOSAL KING 401	R4A	13
402		
P/THP-1 Q/Q 402	DP4	18,20
BATH Q/Q 402	R4B	15
MICROWAVE Q/Q 402	R4B	17
REFRIG Q/Q 402	R4B	19
LTS/REC CKT 1 Q/Q 402	R4B	21
LTS/REC CKT 2 Q/Q 402	R4B	23
DISHWASHER Q/Q 402	R4B	25
DISPOSAL Q/Q 402	R4B	27
403		
P/THP-1 QUEEN 403	DP4	15,17
BATH QUEEN 403	R4A	15
MICROWAVE QUEEN 403	R4A	17
REFRIG QUEEN 403	R4A	19
LTS/REC CKT 1 QUEEN 403	R4A	21
LTS/REC CKT 2 QUEEN 403	R4A	23
DISHWASHER QUEEN 403	R4A	25
DISPOSAL QUEEN 403	R4A	27
404		
P/THP-1 Q/Q 404	DP4	22,24
BATH Q/Q 404	R4B	29
MICROWAVE Q/Q 404	R4B	31
REFRIG Q/Q 404	R4B	33
LTS/REC CKT 1 Q/Q 404	R4B	35
LTS/REC CKT 2 Q/Q 404	R4B	37
DISHWASHER Q/Q 404	R4B	39
DISPOSAL Q/Q 404	R4B	41
405		
P/THP-1 QUEEN 405	DP4	19,21
BATH QUEEN 405	R4A	29
MICROWAVE QUEEN 405	R4A	31
REFRIG QUEEN 405	R4A	33
LTS/REC CKT 1 QUEEN 405	R4A	35
LTS/REC CKT 2 QUEEN 405	R4A	37
DISHWASHER QUEEN 405	R4A	39
DISPOSAL QUEEN 405	R4A	41
406		
P/THP-1 Q/Q 406	DP4	26,28
BATH Q/Q 406	R4B	43
MICROWAVE Q/Q 406	R4B	45
REFRIG Q/Q 406	R4B	47
LTS/REC CKT 1 Q/Q 406	R4B	49
LTS/REC CKT 2 Q/Q 406	R4B	51
DISHWASHER Q/Q 406	R4B	53
DISPOSAL Q/Q 406	R4B	55
408		
P/THP-1 Q/Q 408	DP4	30,32
BATH Q/Q 408	R4B	57
MICROWAVE Q/Q 408	R4B	59
REFRIG Q/Q 408	R4B	61
LTS/REC CKT 1 Q/Q 408	R4B	63
LTS/REC CKT 2 Q/Q 408	R4B	65
DISHWASHER Q/Q 408	R4B	67
DISPOSAL Q/Q 408	R4B	69
410		
P/THP-2 Q/Q 410	DP4	34,36
BATH Q/Q 410	R4B	71
LTS/REC CKT 1 Q/Q 410	R4B	73
LTS/REC CKT 2 Q/Q 410	R4B	75
DISHWASHER Q/Q 410	R4B	77
DISPOSAL Q/Q 410	R4B	79
411		
P/THP-1 Q/Q 411	DP4	23,25
BATH Q/Q 411	R4A	42
MICROWAVE Q/Q 411	R4A	44
REFRIG Q/Q 411	R4A	46
LTS/REC CKT 1 Q/Q 411	R4A	48
LTS/REC CKT 2 Q/Q 411	R4A	50
DISHWASHER Q/Q 411	R4A	52
DISPOSAL Q/Q 411	R4A	54
412		
P/THP-1 QUEEN 412	DP4	38,40
BATH QUEEN 412	R4B	2
MICROWAVE QUEEN 412	R4B	4
REFRIG QUEEN 412	R4B	6
LTS/REC CKT 1 QUEEN 412	R4B	8
LTS/REC CKT 2 QUEEN 412	R4B	10
DISHWASHER QUEEN 412	R4B	12
DISPOSAL QUEEN 412	R4B	14
413		
P/THP-1 Q/Q 413	DP4	27,29
BATH Q/Q 413	R4A	57
MICROWAVE Q/Q 413	R4A	59
REFRIG Q/Q 413	R4A	61
LTS/REC CKT 1 Q/Q 413	R4A	63
LTS/REC CKT 2 Q/Q 413	R4A	65
DISHWASHER Q/Q 413	R4A	67
DISPOSAL Q/Q 413	R4A	69
414		
P/THP-1 QUEEN 414	DP4	44,46
BATH QUEEN 414	R4B	16
MICROWAVE QUEEN 414	R4B	18
REFRIG QUEEN 414	R4B	20
LTS/REC CKT 1 QUEEN 414	R4B	22
LTS/REC CKT 2 QUEEN 414	R4B	24
DISHWASHER QUEEN 414	R4B	26
415		
P/THP-1 Q/Q 415	DP4	33
LTS/REC CKT 2 Q/Q 415	R4A	1
BATH Q/Q 415	R4A	3
MICROWAVE Q/Q 415	R4A	5
REFRIG Q/Q 415	R4A	7
LTS/REC CKT 1 Q/Q 415	R4A	9
LTS/REC CKT 2 Q/Q 415	R4A	11
DISHWASHER Q/Q 415	R4A	13
DISPOSAL Q/Q 415	R4A	15
416		
P/THP-1 QUEEN 416	DP4	48,50
BATH QUEEN 416	R4B	30
MICROWAVE QUEEN 416	R4B	32
REFRIG QUEEN 416	R4B	34
LTS/REC CKT 1 QUEEN 416	R4B	36
LTS/REC CKT 2 QUEEN 416	R4B	38
DISHWASHER QUEEN 416	R4B	40
DISPOSAL QUEEN 416	R4B	42
417		
P/THP-1 Q/Q 417	DP4	35,37
BATH Q/Q 417	R4A	7
MICROWAVE Q/Q 417	R4A	9
REFRIG Q/Q 417	R4A	11
LTS/REC CKT 1 Q/Q 417	R4A	13
LTS/REC CKT 2 Q/Q 417	R4A	15
DISHWASHER Q/Q 417	R4A	17
DISPOSAL Q/Q 417	R4A	19
418		
P/THP-1 QUEEN 418	DP4	52,54
BATH QUEEN 418	R4B	44
MICROWAVE QUEEN 418	R4B	46
REFRIG QUEEN 418	R4B	48
LTS/REC CKT 1 QUEEN 418	R4B	50
LTS/REC CKT 2 QUEEN 418	R4B	52
DISHWASHER QUEEN 418	R4B	54
DISPOSAL QUEEN 418	R4B	56
419		
P/THP-1 KING 419 CKT 1	DP4	39,41
P/THP-1 KING 419 CKT 2	DP4	43,45
BATH KING 419	R4A	16
MICROWAVE KING 419	R4A	18
REFRIG KING 419	R4A	20
LTS/REC CKT 1 KING 419	R4A	22
LTS/REC CKT 2 KING 419	R4A	24
DISHWASHER KING 419	R4A	26
DISPOSAL KING 419	R4A	28
420		
P/THP-1 QUEEN 420	DP4	56,58
BATH QUEEN 420	R4B	58
MICROWAVE QUEEN 420	R4B	60
REFRIG QUEEN 420	R4B	62
LTS/REC CKT 1 QUEEN 420	R4B	64
LTS/REC CKT 2 QUEEN 420	R4B	66
DISHWASHER QUEEN 420	R4B	68
DISPOSAL QUEEN 420	R4B	70
421		
P/THP-1 QUEEN 421	DP4	47,49
BATH QUEEN 421	R4A	30
MICROWAVE QUEEN 421	R4A	32
REFRIG QUEEN 421	R4A	34
LTS/REC CKT 1 QUEEN 421	R4A	36
LTS/REC CKT 2 QUEEN 421	R4A	38
DISHWASHER QUEEN 421	R4A	40
DISPOSAL QUEEN 421	R4A	42
422		
P/THP-1 QUEEN 422	DP4	60,62
BATH QUEEN STUDIO 422	R4B	72
MICROWAVE QUEEN STUDIO 422	R4B	74
REFRIG QUEEN STUDIO 422	R4B	76
LTS/REC CKT 1 QUEEN STUDIO 422	R4B	78
LTS/REC CKT 2 QUEEN STUDIO 422	R4B	80
DISHWASHER QUEEN STUDIO 422	R4B	82
DISPOSAL QUEEN STUDIO 422	R4B	84
423		
P/THP-1 QUEEN 423	DP4	61,63
BATH QUEEN 423	R4A	44
MICROWAVE QUEEN 423	R4A	46
REFRIG QUEEN 423	R4A	48
LTS/REC CKT 1 QUEEN 423	R4A	50
LTS/REC CKT 2 QUEEN 423	R4A	52
DISHWASHER QUEEN 423	R4A	54
DISPOSAL QUEEN 423	R4A	56
424		
P/THP-1 QUEEN 424	DP4	64,66
BATH QUEEN 424	R4C	1
MICROWAVE QUEEN 424	R4C	3
REFRIG QUEEN 424	R4C	5
LTS/REC CKT 1 QUEEN 424	R4C	7
LTS/REC CKT 2 QUEEN 424	R4C	9
DISHWASHER QUEEN 424	R4C	11
DISPOSAL QUEEN 424	R4C	13
425		
P/THP-2 QUEEN 425	DP4	65,67
BATH QUEEN 425	R4A	58
MICROWAVE QUEEN 425	R4A	60
REFRIG QUEEN 425	R4A	62
LTS/REC CKT 1 QUEEN 425	R4A	64
LTS/REC CKT 2 QUEEN 425	R4A	66
DISHWASHER QUEEN 425	R4A	68
DISPOSAL QUEEN 425	R4A	70
426		
P/THP-1 KING 426 CKT 1	DP4	68,70
P/THP-1 KING 426 CKT 2	DP4	72,74
BATH KING 426	R4C	2
MICROWAVE KING 426	R4C	4
REFRIG KING 426	R4C	6
LTS/REC CKT 1 KING 426	R4C	8
LTS/REC CKT 2 KING 426	R4C	10
DISHWASHER KING 426	R4C	12
DISPOSAL KING 426	R4C	14

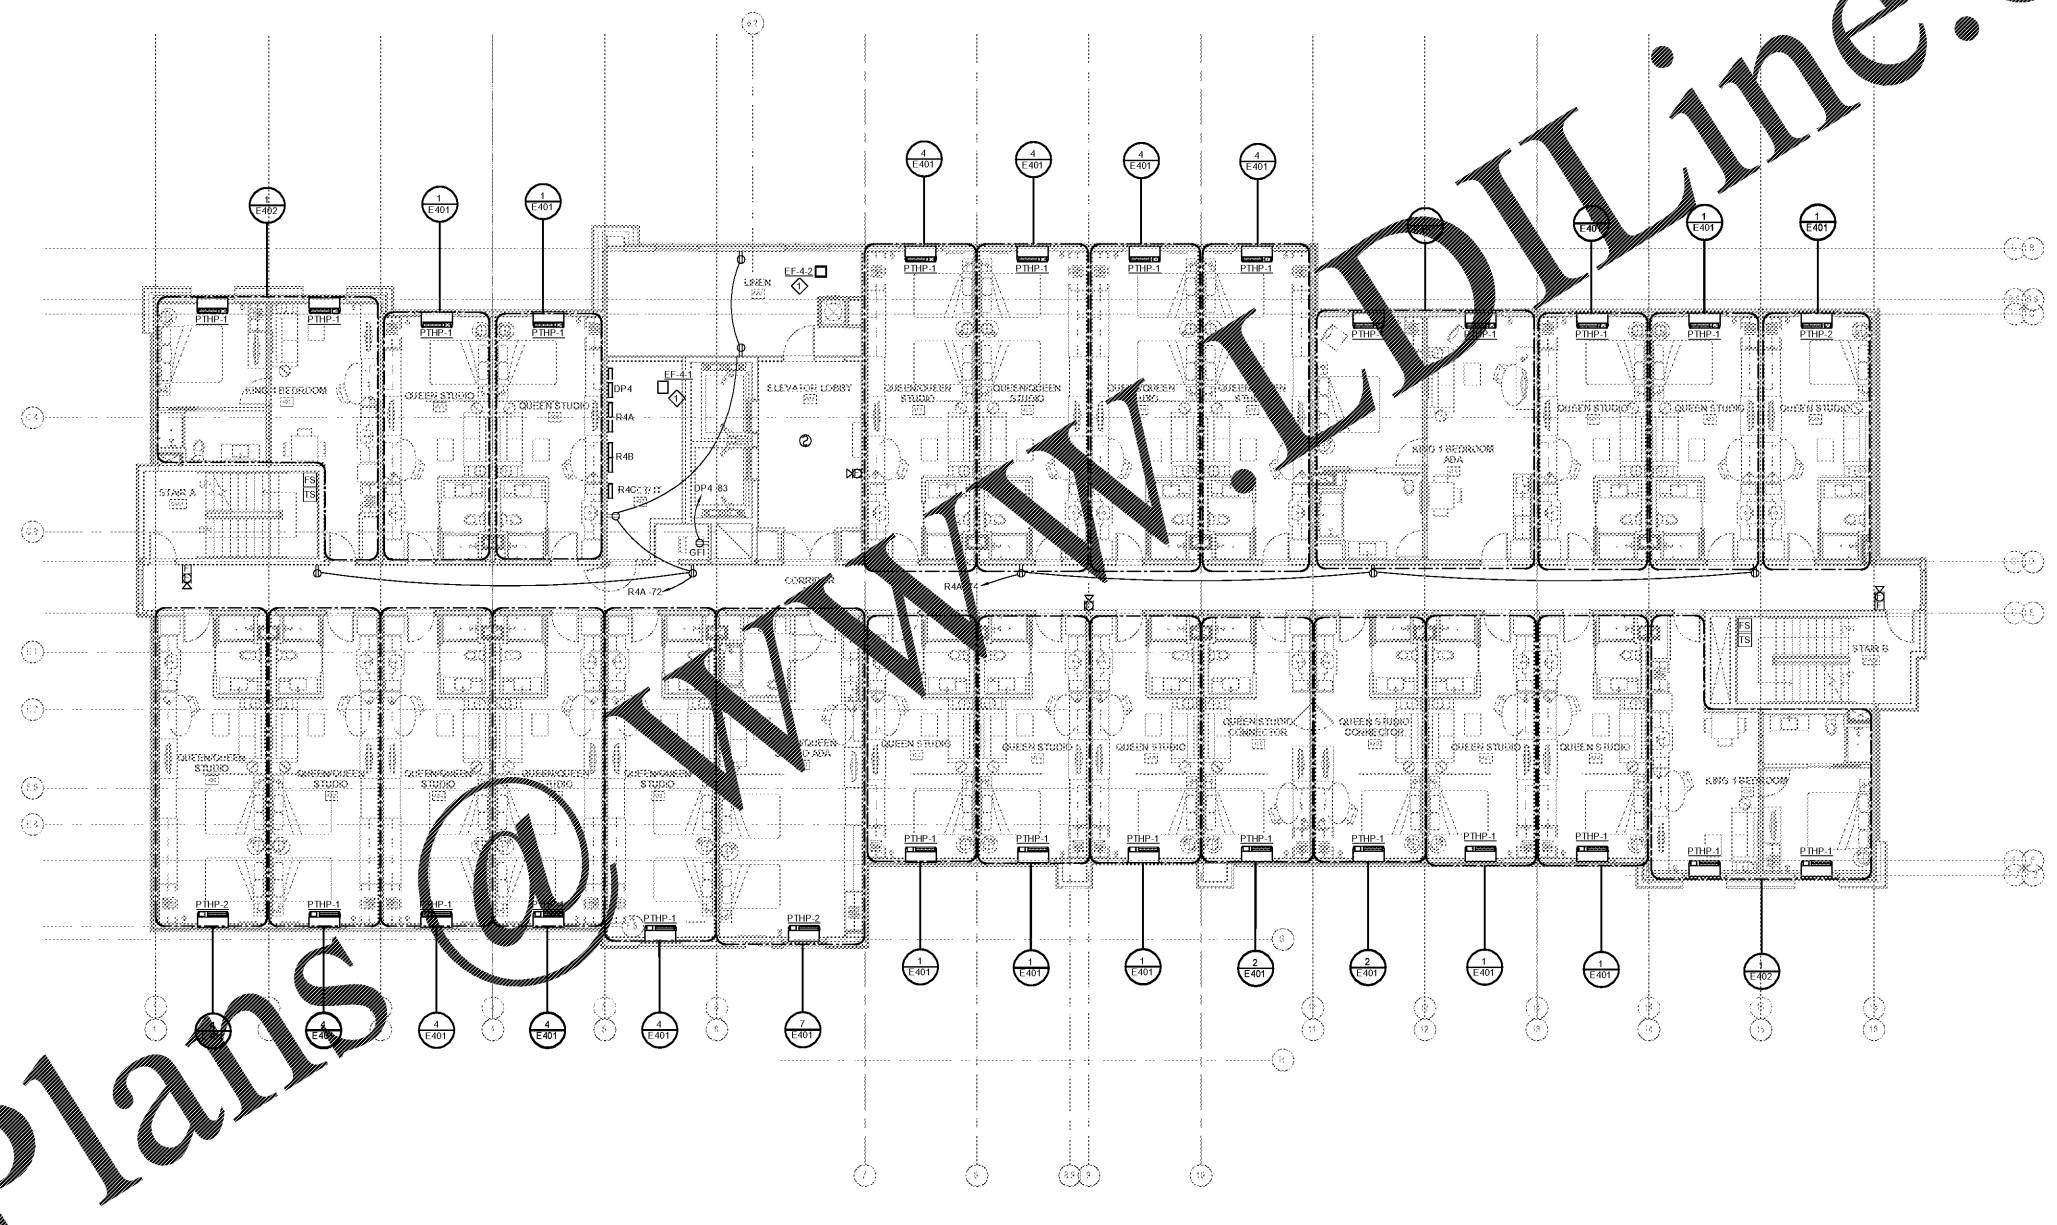

1 LEVEL 4 FLOOR PLAN - POWER
E104 1/8" = 1'-0"


GENERAL NOTES:
A. REFER TO MECHANICAL EQUIPMENT SCHEDULE ON SHEET E501 FOR CIRCUITING, FEEDER, AND LOCAL DISCONNECT REQUIREMENTS FOR MECHANICAL EQUIPMENT.

KEYED NOTES:

1. EXHAUST FAN SHALL RUN 24/7.

mcmillan
pazdan
smith
ARCHITECTURE

ATLANTA CHARLOTTE GREENVILLE
877.4.DEVITA
devita & associates, inc. Project: 17239
NC Perm License # C-0819
MS Checked By: RAG

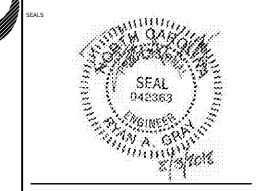

WINDOR AUGHTRY
HOME2 ASHEVILLE
380 AIRPORT RD.
ARDEEN, NC 28704

SHEET ISSUE
07/30/18
FOR CONSTRUCTION

Number	Revisions	Date

PRINCIPAL IN CHARGE
PROJECT ARCHITECT
DRAWN BY
SHEET TITLE
LEVEL 4 FLOOR
PLAN - POWER

SHEET NO. E104
PROJ NO. 01739.00