


LOAD	PANEL	CKT
500		
BATH Q/Q 500	R5B	1
MICROWAVE Q/Q 500	R5B	3
REFRIG Q/Q 500	R5B	5
LTS/REC CKT 1 Q/Q 500	R5B	7
LTS/REC CKT 2 Q/Q 500	R5B	9
DISHWASHER Q/Q 500	R5B	11
DISPOSAL Q/Q 500	R5B	13
PTHP-3 Q/Q 500	DPS	14.16
501		
BATH KING 501	R5A	1
MICROWAVE KING 501	R5A	3
REFRIG KING 501	R5A	5
LTS/REC CKT 1 KING 501	R5A	7
LTS/REC CKT 2 KING 501	R5A	9
DISHWASHER KING 501	R5A	11
DISPOSAL KING 501	R5A	13
PTHP-2 KING 501 CKT 1	DPS	13.73
PTHP-2 KING 501 CKT 2	DPS	11.13
502		
BATH Q/Q 502	R5B	15
MICROWAVE Q/Q 502	R5B	17
REFRIG Q/Q 502	R5B	19
LTS/REC CKT 1 Q/Q 502	R5B	21
LTS/REC CKT 2 Q/Q 502	R5B	23
DISHWASHER Q/Q 502	R5B	25
DISPOSAL Q/Q 502	R5B	27
PTHP-2 Q/Q 502	DPS	18.20
503		
BATH QUEEN 503	R5A	15
MICROWAVE QUEEN 503	R5A	17
REFRIG QUEEN 503	R5A	19
LTS/REC CKT 1 QUEEN 503	R5A	21
LTS/REC CKT 2 QUEEN 503	R5A	23
DISHWASHER QUEEN 503	R5A	25
DISPOSAL QUEEN 503	R5A	27
PTHP-2 QUEEN 503	DPS	15.17
504		
BATH Q/Q 504	R5B	29
MICROWAVE Q/Q 504	R5B	31
REFRIG Q/Q 504	R5B	33
LTS/REC CKT 1 Q/Q 504	R5B	35
LTS/REC CKT 2 Q/Q 504	R5B	37
DISHWASHER Q/Q 504	R5B	39
DISPOSAL Q/Q 504	R5B	41
PTHP-2 Q/Q 504	DPS	22.24
505		
BATH QUEEN 505	R5A	29
MICROWAVE QUEEN 505	R5A	31
REFRIG QUEEN 505	R5A	33
LTS/REC CKT 1 QUEEN 505	R5A	35
LTS/REC CKT 2 QUEEN 505	R5A	37
DISHWASHER QUEEN 505	R5A	39
DISPOSAL QUEEN 505	R5A	41
PTHP-2 QUEEN 505	DPS	19.21
506		
BATH Q/Q 506	R5B	43
MICROWAVE Q/Q 506	R5B	45
REFRIG Q/Q 506	R5B	47
LTS/REC CKT 1 Q/Q 506	R5B	49
LTS/REC CKT 2 Q/Q 506	R5B	51
DISHWASHER Q/Q 506	R5B	53
DISPOSAL Q/Q 506	R5B	55
PTHP-2 Q/Q 506	DPS	28.28
508		
BATH Q/Q 508	R5B	57
MICROWAVE Q/Q 508	R5B	59
REFRIG Q/Q 508	R5B	61
LTS/REC CKT 1 Q/Q 508	R5B	63
LTS/REC CKT 2 Q/Q 508	R5B	65
DISHWASHER Q/Q 508	R5B	67
DISPOSAL Q/Q 508	R5B	69
PTHP-2 Q/Q 508	DPS	30.32
510		
BATH QUEEN 510	R5B	71
MICROWAVE QUEEN 510	R5B	73
REFRIG QUEEN 510	R5B	75
LTS/REC CKT 1 QUEEN 510	R5B	77
LTS/REC CKT 2 QUEEN 510	R5B	79
DISHWASHER QUEEN 510	R5B	81
DISPOSAL QUEEN 510	R5B	83
PTHP-3 QUEEN 510	DPS	34.38
511		
BATH Q/Q 511	R5A	43
MICROWAVE Q/Q 511	R5A	45
REFRIG Q/Q 511	R5A	47
LTS/REC CKT 1 Q/Q 511	R5A	49
LTS/REC CKT 2 Q/Q 511	R5A	51
DISHWASHER Q/Q 511	R5A	53
DISPOSAL Q/Q 511	R5A	55
PTHP-2 Q/Q 511	DPS	23.25
512		
BATH QUEEN 512	R5B	2
MICROWAVE QUEEN 512	R5B	4
REFRIG QUEEN 512	R5B	6
LTS/REC CKT 1 QUEEN 512	R5B	8
LTS/REC CKT 2 QUEEN 512	R5B	10
DISHWASHER QUEEN 512	R5B	12
DISPOSAL QUEEN 512	R5B	14
PTHP-2 QUEEN 512	DPS	38.40
513		
BATH Q/Q 513	R5A	57
MICROWAVE Q/Q 513	R5A	59
REFRIG Q/Q 513	R5A	61
LTS/REC CKT 1 Q/Q 513	R5A	63
LTS/REC CKT 2 Q/Q 513	R5A	65
DISHWASHER Q/Q 513	R5A	67
DISPOSAL Q/Q 513	R5A	69
PTHP-2 Q/Q 513	DPS	27.29
514		
BATH QUEEN 514	R5B	16
MICROWAVE QUEEN 514	R5B	18
REFRIG QUEEN 514	R5B	20
LTS/REC CKT 1 QUEEN 514	R5B	22
LTS/REC CKT 2 QUEEN 514	R5B	24
DISHWASHER QUEEN 514	R5B	26
DISPOSAL QUEEN 514	R5B	28
PTHP-2 QUEEN 514	R5B	44.46
515		
BATH Q/Q 515	R5A	81
MICROWAVE Q/Q 515	R5A	83
REFRIG Q/Q 515	R5A	85
LTS/REC CKT 1 Q/Q 515	R5A	87
LTS/REC CKT 2 Q/Q 515	R5A	89
DISHWASHER Q/Q 515	R5A	91
DISPOSAL Q/Q 515	R5A	93
PTHP-2 Q/Q 515	DPS	31.33
516		
BATH QUEEN 516	R5B	30
MICROWAVE QUEEN 516	R5B	32
REFRIG QUEEN 516	R5B	34
LTS/REC CKT 1 QUEEN 516	R5B	36
LTS/REC CKT 2 QUEEN 516	R5B	38
DISHWASHER QUEEN 516	R5B	40
DISPOSAL QUEEN 516	R5B	42
PTHP-2 QUEEN 516	DPS	48.50
517		
BATH Q/Q 517	R5A	2
MICROWAVE Q/Q 517	R5A	4
REFRIG Q/Q 517	R5A	6
LTS/REC CKT 1 Q/Q 517	R5A	8
LTS/REC CKT 2 Q/Q 517	R5A	10
DISHWASHER Q/Q 517	R5A	12
DISPOSAL Q/Q 517	R5A	14
PTHP-2 Q/Q 517	DPS	35.37
518		
BATH QUEEN 518	R5B	44
MICROWAVE QUEEN 518	R5B	46
REFRIG QUEEN 518	R5B	48
LTS/REC CKT 1 QUEEN 518	R5B	50
LTS/REC CKT 2 QUEEN 518	R5B	52
DISHWASHER QUEEN 518	R5B	54
DISPOSAL QUEEN 518	R5B	56
PTHP-2 QUEEN 518	DPS	52.54
519		
BATH KING 519	R5A	16
MICROWAVE KING 519	R5A	18
REFRIG KING 519	R5A	20
LTS/REC CKT 1 KING 519	R5A	22
LTS/REC CKT 2 KING 519	R5A	24
DISHWASHER KING 519	R5A	26
DISPOSAL KING 519	R5A	28
PTHP-2 KING 519	DPS	39.41
PTHP-2 KING 519	DPS	42.46
520		
BATH QUEEN STUDIO 520	R5B	58
MICROWAVE QUEEN STUDIO 520	R5B	60
REFRIG QUEEN STUDIO 520	R5B	62
LTS/REC CKT 1 QUEEN STUDIO 520	R5B	64
LTS/REC CKT 2 QUEEN STUDIO 520	R5B	66
DISHWASHER QUEEN STUDIO 520	R5B	68
DISPOSAL QUEEN STUDIO 520	R5B	70
PTHP-2 QUEEN STUDIO 520	DPS	56.58
521		
BATH QUEEN 521	R5A	30
MICROWAVE QUEEN 521	R5A	32
REFRIG QUEEN 521	R5A	34
LTS/REC CKT 1 QUEEN 521	R5A	36
LTS/REC CKT 2 QUEEN 521	R5A	38
DISHWASHER QUEEN 521	R5A	40
DISPOSAL QUEEN 521	R5A	42
PTHP-2 QUEEN 521	DPS	47.49
522		
BATH QUEEN 522	R5B	72
MICROWAVE QUEEN 522	R5B	74
REFRIG QUEEN 522	R5B	76
LTS/REC CKT 1 QUEEN 522	R5B	78
LTS/REC CKT 2 QUEEN 522	R5B	80
DISHWASHER QUEEN 522	R5B	82
DISPOSAL QUEEN 522	R5B	84
PTHP-2 QUEEN 522	DPS	60.62
523		
BATH QUEEN 523	R5A	44
MICROWAVE QUEEN 523	R5A	46
REFRIG QUEEN 523	R5A	48
LTS/REC CKT 1 QUEEN 523	R5A	50
LTS/REC CKT 2 QUEEN 523	R5A	52
DISHWASHER QUEEN 523	R5A	54
DISPOSAL QUEEN 523	R5A	56
PTHP-2 QUEEN 523	DPS	51.53
524		
PTHP-2 QUEEN 524	DPS	64.66
BATH QUEEN 524	R5C	1
MICROWAVE QUEEN 524	R5C	3
REFRIG QUEEN 524	R5C	5
LTS/REC CKT 1 QUEEN 524	R5C	7
LTS/REC CKT 2 QUEEN 524	R5C	9
DISHWASHER QUEEN 524	R5C	11
DISPOSAL QUEEN 524	R5C	13
525		
BATH QUEEN 525	R5A	58
MICROWAVE QUEEN 525	R5A	60
REFRIG QUEEN 525	R5A	62
LTS/REC CKT 1 QUEEN 525	R5A	64
LTS/REC CKT 2 QUEEN 525	R5A	66
DISHWASHER QUEEN 525	R5A	68
DISPOSAL QUEEN 525	R5A	70
PTHP-3 QUEEN 525	DPS	55.57
526		
PTHP-2 KING 526 CKT 1	DPS	68.70
PTHP-2 KING 526 CKT 2	DPS	72.74
BATH KING 526	R5C	2
MICROWAVE KING 526	R5C	4
REFRIG KING 526	R5C	6
LTS/REC CKT 1 KING 526	R5C	8
LTS/REC CKT 2 KING 526	R5C	10
DISHWASHER KING 526	R5C	12
DISPOSAL KING 526	R5C	14

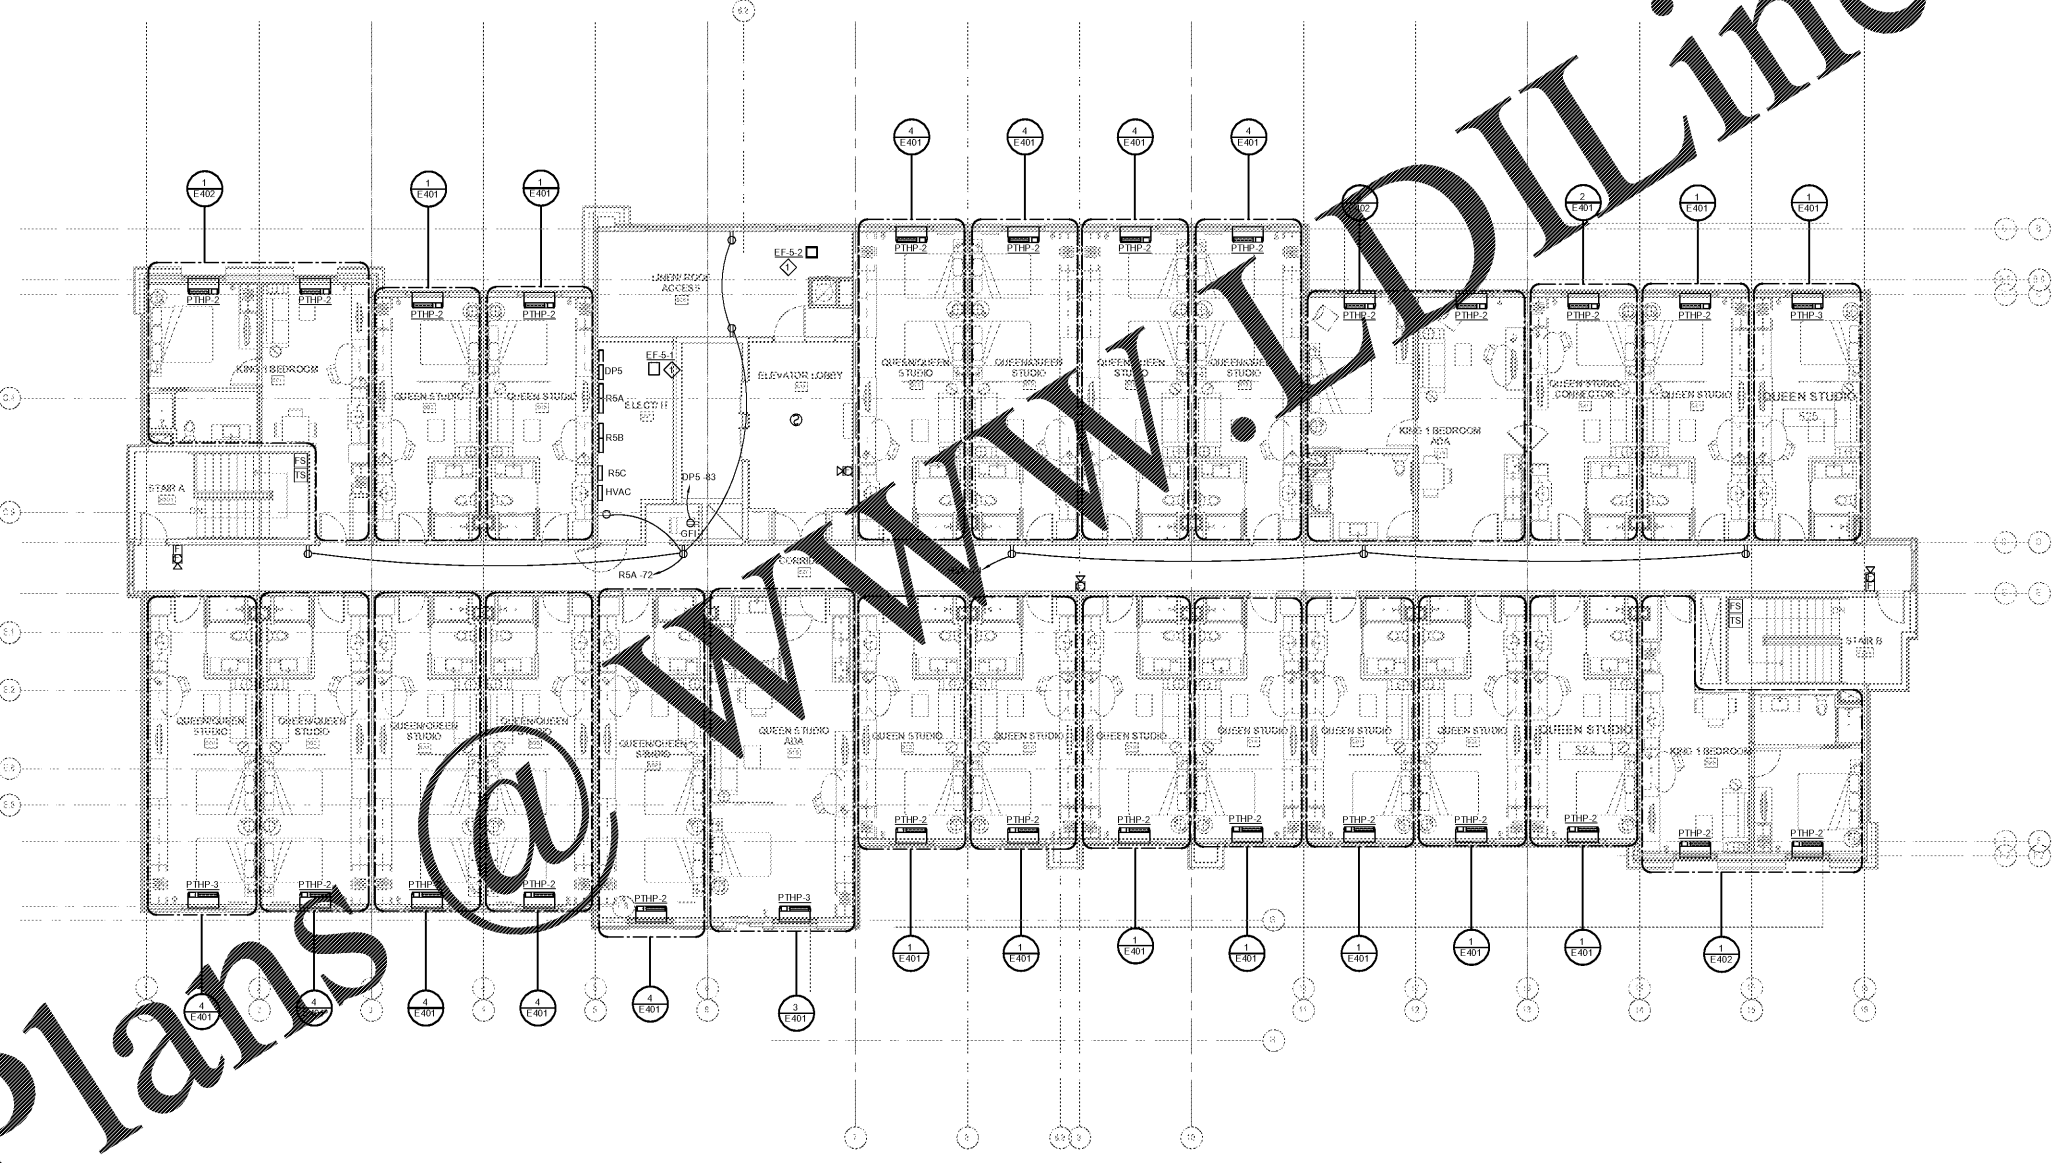

1 LEVEL 5 FLOOR PLAN - POWER
E105 1/8" = 1'-0"

GENERAL NOTES:
A. REFER TO MECHANICAL EQUIPMENT SCHEDULE ON SHEET E501 FOR CIRCUITING, FEEDER, AND LOCAL DISCONNECT REQUIREMENTS FOR MECHANICAL EQUIPMENT.
KEYED NOTES: ◊
1. EXHAUST FAN SHALL RUN 24/7.

mcmillan
pazdan
smith
ARCHITECTURE

877.4.DEVITA
DeVita & Associates, Inc. Project: 17239
NC Perm License # C-0819
MS Checked By: RAG

SEAL
042863
REGISTERED
ELECTRICAL ENGINEER
STATE OF NORTH CAROLINA
2/2/2018

WINDSOR AUGHTRY
HOME2 ASHEVILLE
380 AIRPORT RD.
ASHEVILLE, NC 28704

SHEET ISSUE
07/30/18
FOR CONSTRUCTION

Number	Description	Date

PRINCIPAL IN CHARGE
PROJECT ARCHITECT
DRAWN BY
SHEET TITLE
LEVEL 5 FLOOR
PLAN - POWER

SHEET NO. E105
PROJ NO. 01739.90

Order Plans @ www.DLine.com