


GENERAL NOTES:

- A. REFER TO MECHANICAL EQUIPMENT SCHEDULE ON SHEET E501 FOR CIRCUITING, FEEDER AND LOCAL DISCONNECT REQUIREMENTS FOR MECHANICAL EQUIPMENT.
- B. REFERENCE ARCHITECTURAL REFLECTED CEILING PLAN FOR EXACT FIXTURES LOCATION.

mcmilian
pazdan
smith
ARCHITECTURE

CONSULTANT LOGO
DEVITA
ATLANTA CHARLOTTE GREENVILLE
RICHMOND
877.4.DEVITA • info@devitainc.com
Devita & Associates, Inc. Project: 17239
NC State License # C-0819
MS Checked By: RAG

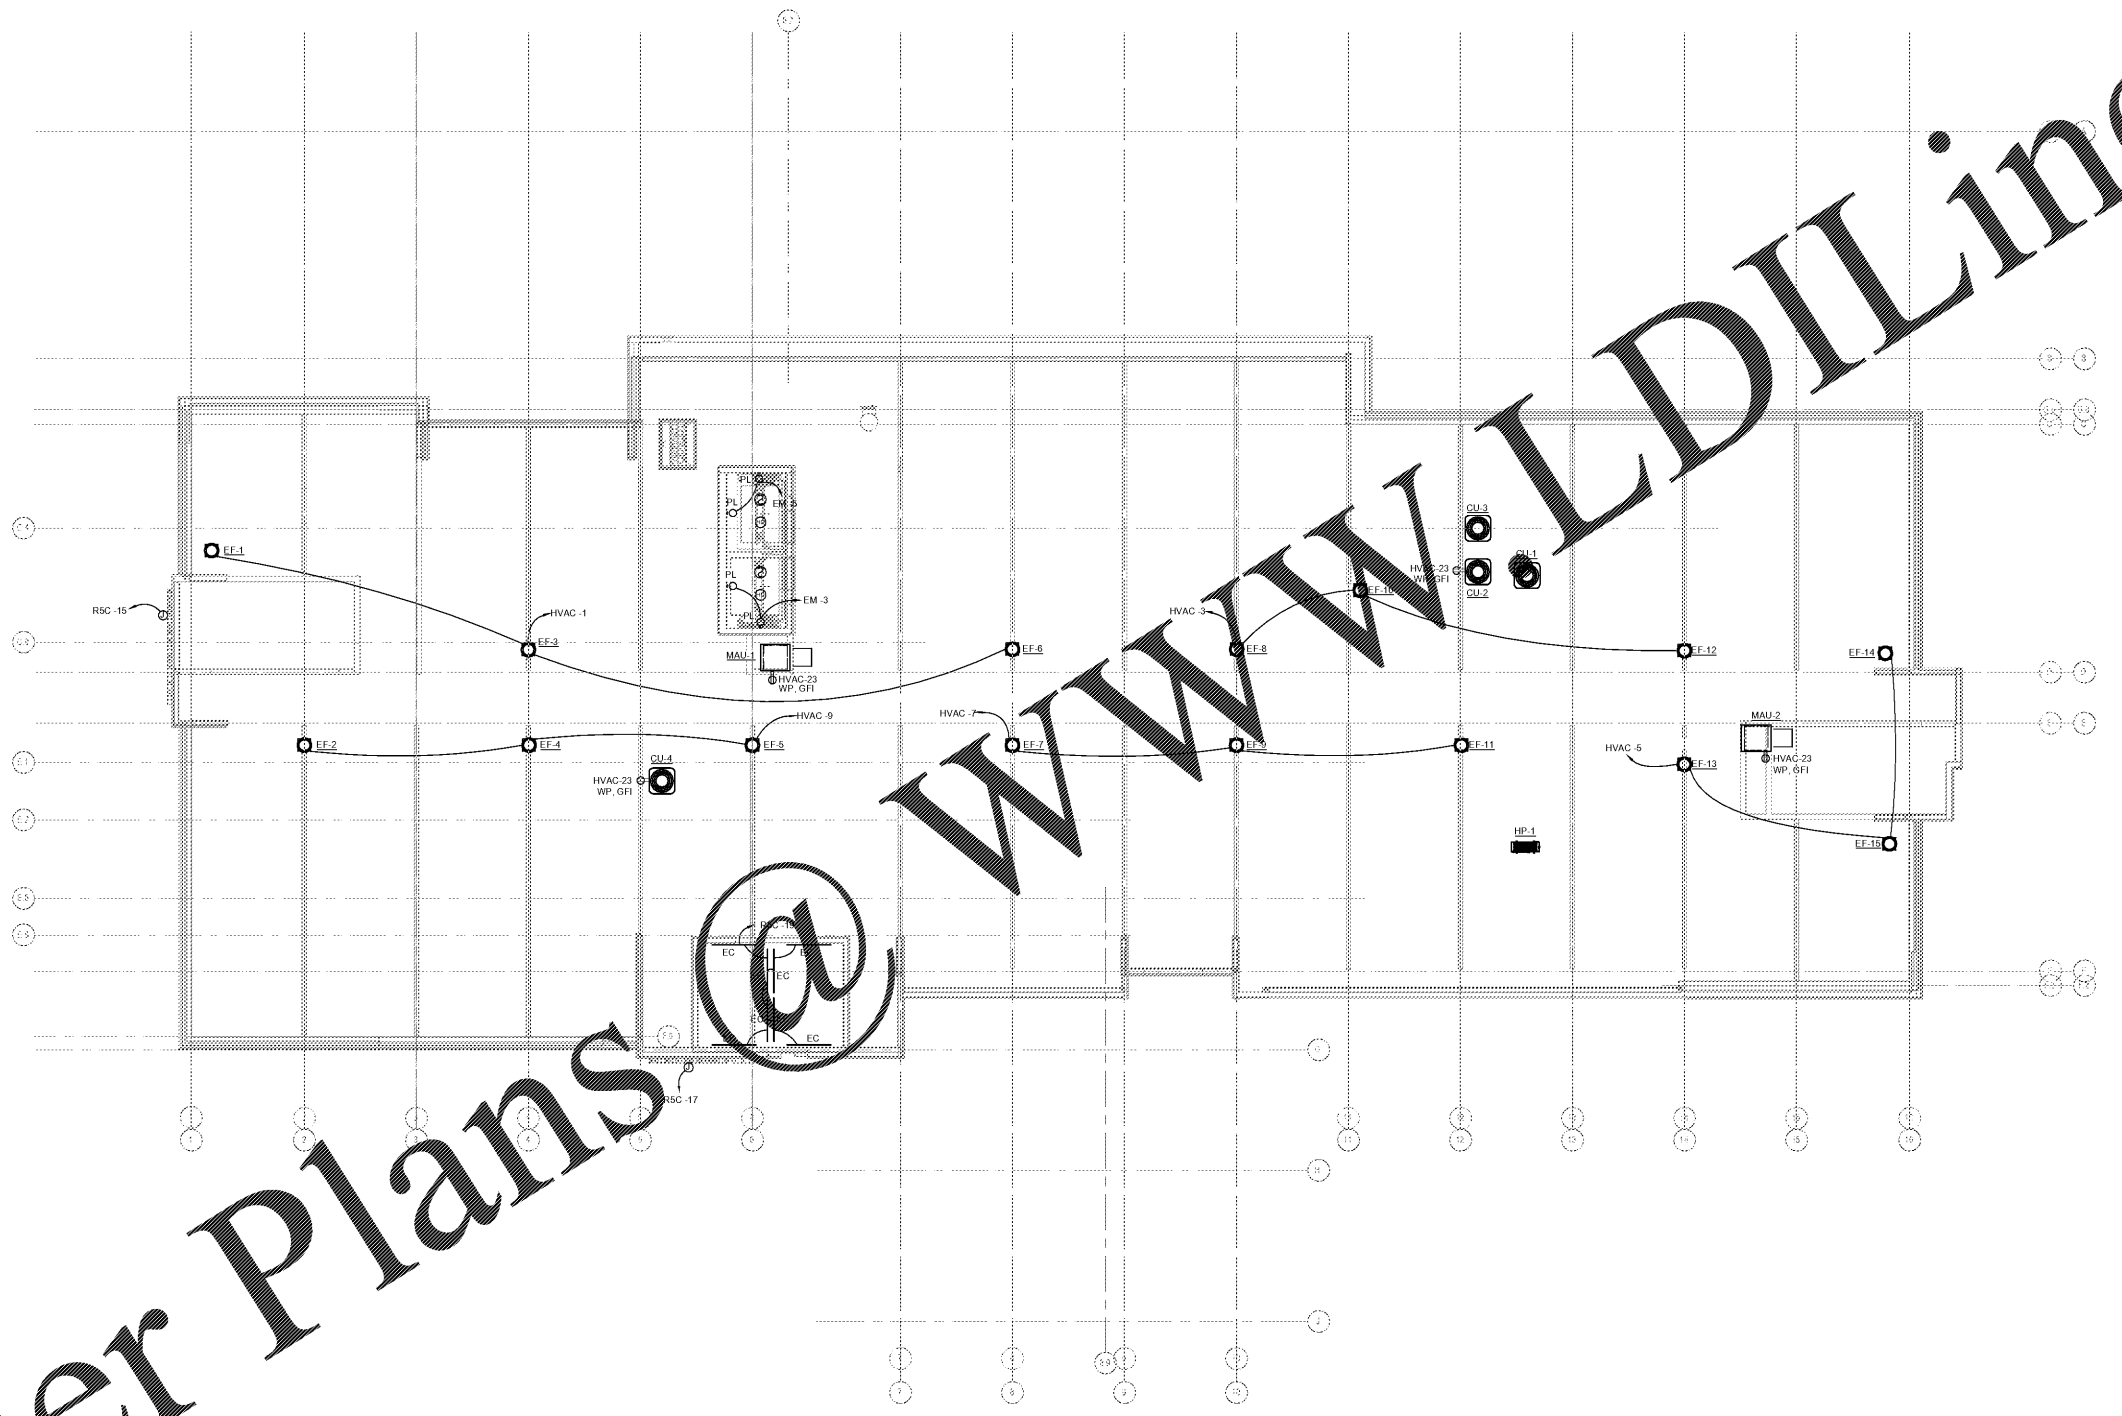

1 ELECTRICAL ROOF PLAN
E106 1/8" = 1'-0"

WINDSOR AUGHTRY
HOME2 ASHEVILLE
380 AIRPORT RD.
ASHEVILLE, NC 28704

SHEET ISSUE
07/30/18
FOR CONSTRUCTION


Revisions		
Number	Description	Date

PRINCIPAL IN CHARGE
PROJECT ARCHITECT
DRAWN BY
SHEET TITLE
**OVERALL
ELECTRICAL ROOF
PLAN**

SHEET NO. PROJ. NO.
E106 017378.00

E106

Order Plans @

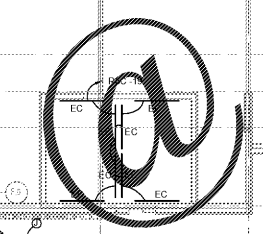

WWW.DILine.com