

GENERAL NOTES:



A. REFERENCE ARCHITECTURAL REFLECTED CEILING PLAN FOR EXACT FIXTURE LOCATIONS.

KEYED NOTES:

- 1. ROUTE CIRCUIT THROUGH LIGHTING CONTROLS. REFER TO DETAIL SE601 ON SHEET E801.
- 2. PROVIDE JUNCTION BOX FOR CONNECTION TO TYPE 'Q1' STRING LIGHTS. COORDINATE EXACT ROUGH IN REQUIREMENTS WITH ARCHITECT.

mcmilian
pazdan
smith
ARCHITECTURE

DEVITA
ATLANTA CHARLOTTE GREENVILLE
RICHMOND
877.4.DEVITA
devita.com
Devita & Associates, Inc. Project: 17239
NC State License # C-0819
MS Checked By: RAG

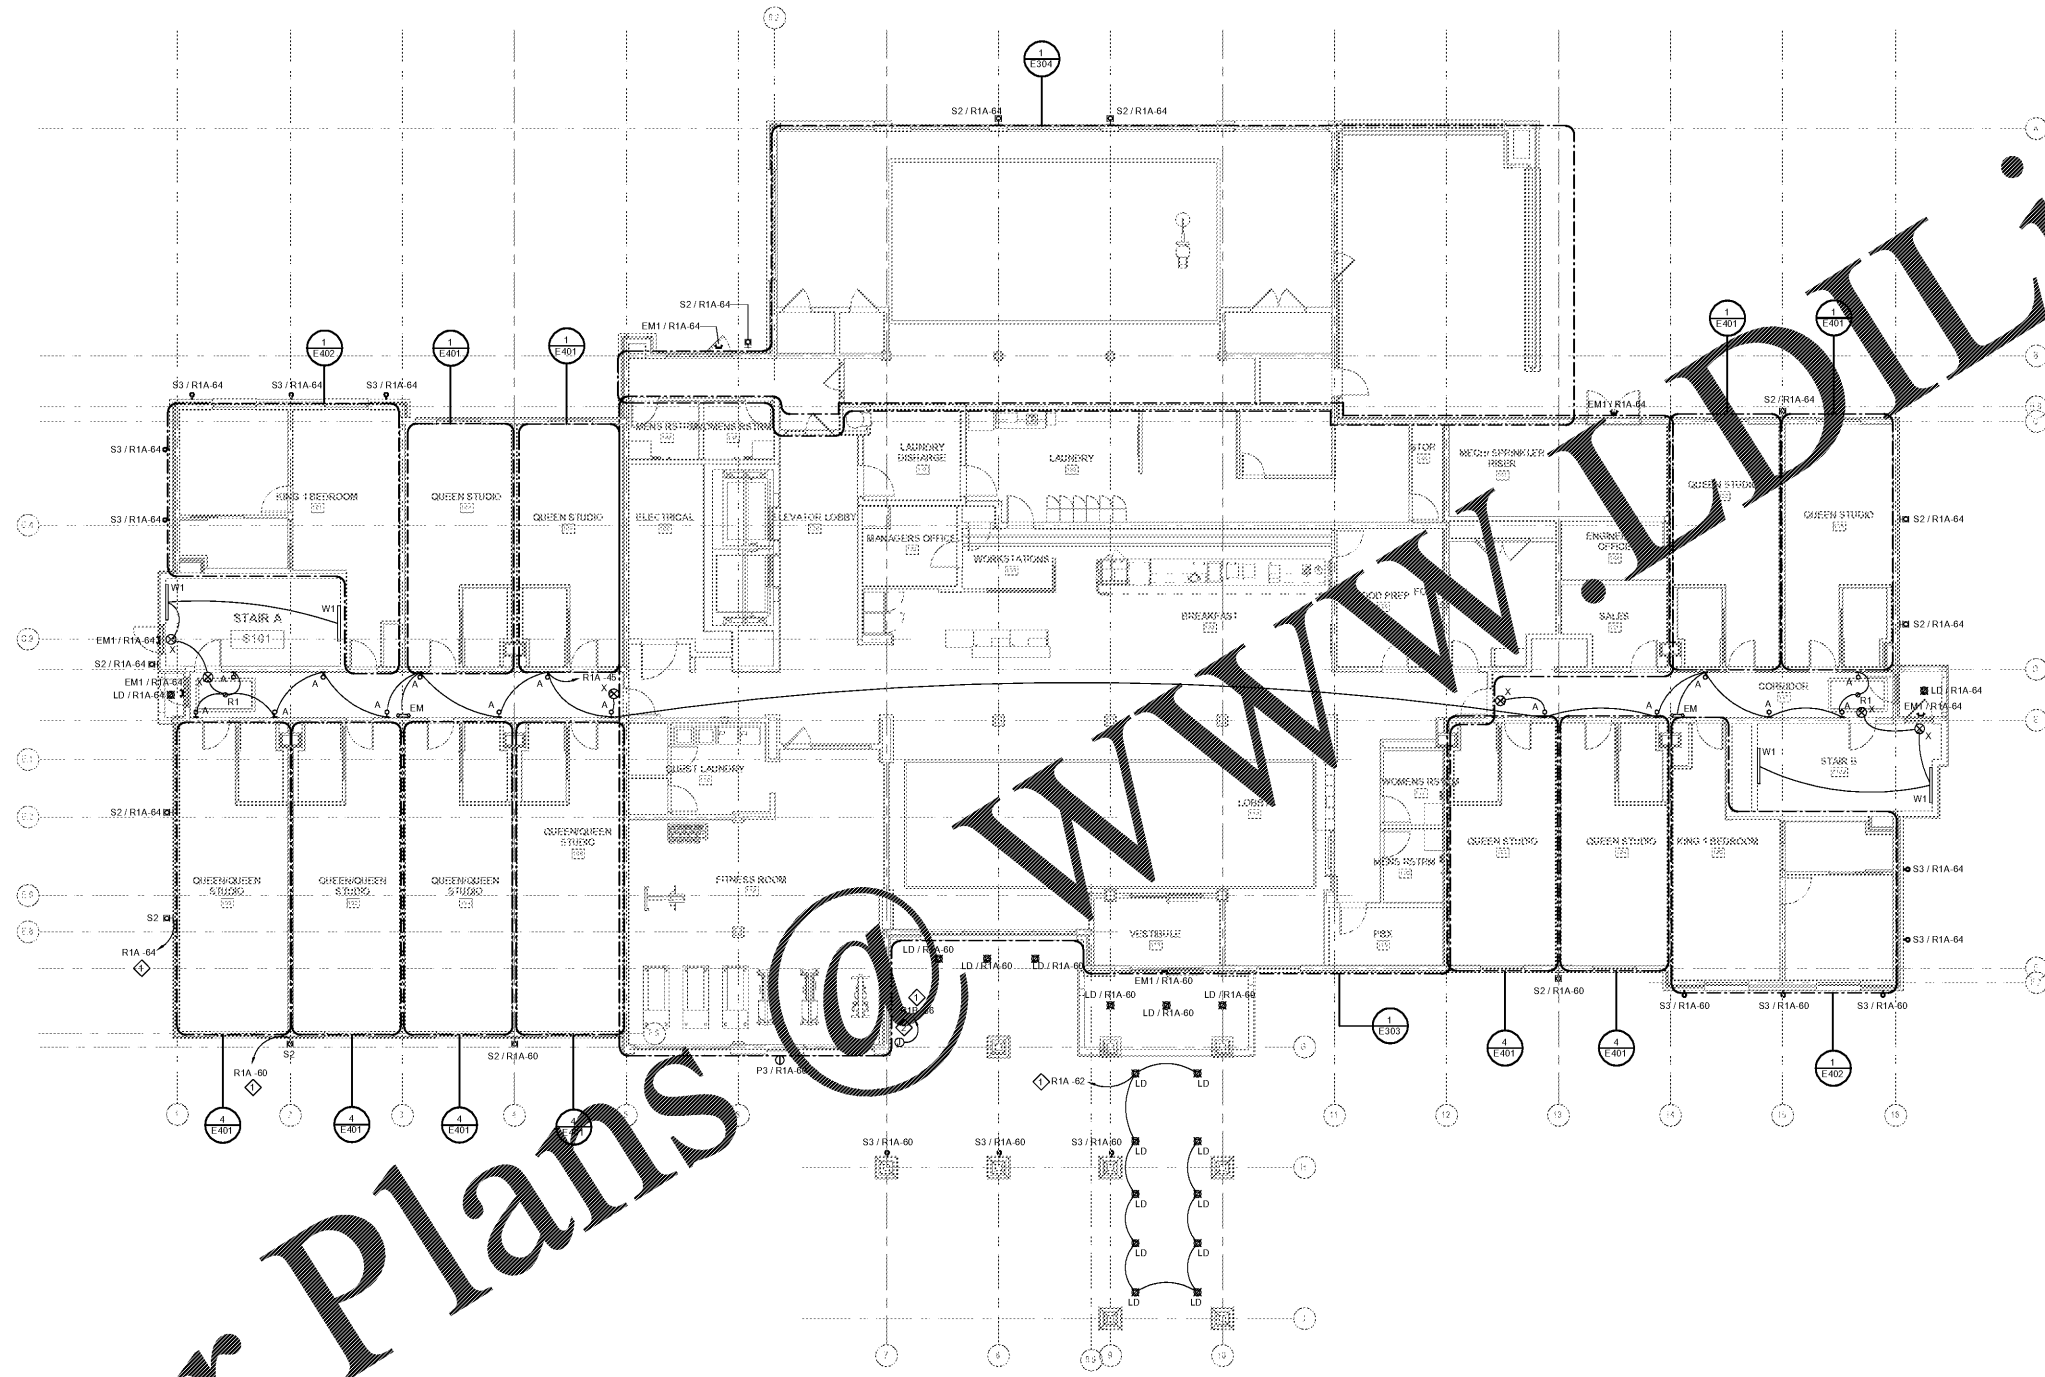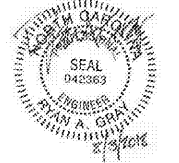

1 LEVEL 1 FLOOR PLAN - LIGHTING
1/8" = 1'-0"

Order Plans

WWW.LDLine.com

WINDSOR AUGHTRY
HOME2 ASHEVILLE
380 AIRPORT RD.
ASHEVILLE, NC 28704

SHEET ISSUE
07/30/18
FOR CONSTRUCTION

Revisions		
Number	Description	Date

PRINCIPAL IN CHARGE
PROJECT ARCHITECT
DRAWN BY
SHEET TITLE
LEVEL 1 FLOOR
PLAN - LIGHTING

SHEET NO. PROJ. NO.
E201 017378.00