



GENERAL NOTES:

A. REFERENCE ARCHITECTURAL REFLECTED CEILING PLAN FOR EXACT FIXTURE LOCATIONS

mcmilian
pazdan
smith
ARCHITECTURE

CONSULTANT LOG

DEVITA
ATLANTA CHARLOTTE GREENVILLE
RICHMOND
877.4.DEVITA
devita@devitainc.com
Devita & Associates, Inc. Project: 17239
NC State License # C-0819
MS Checked By: RAG

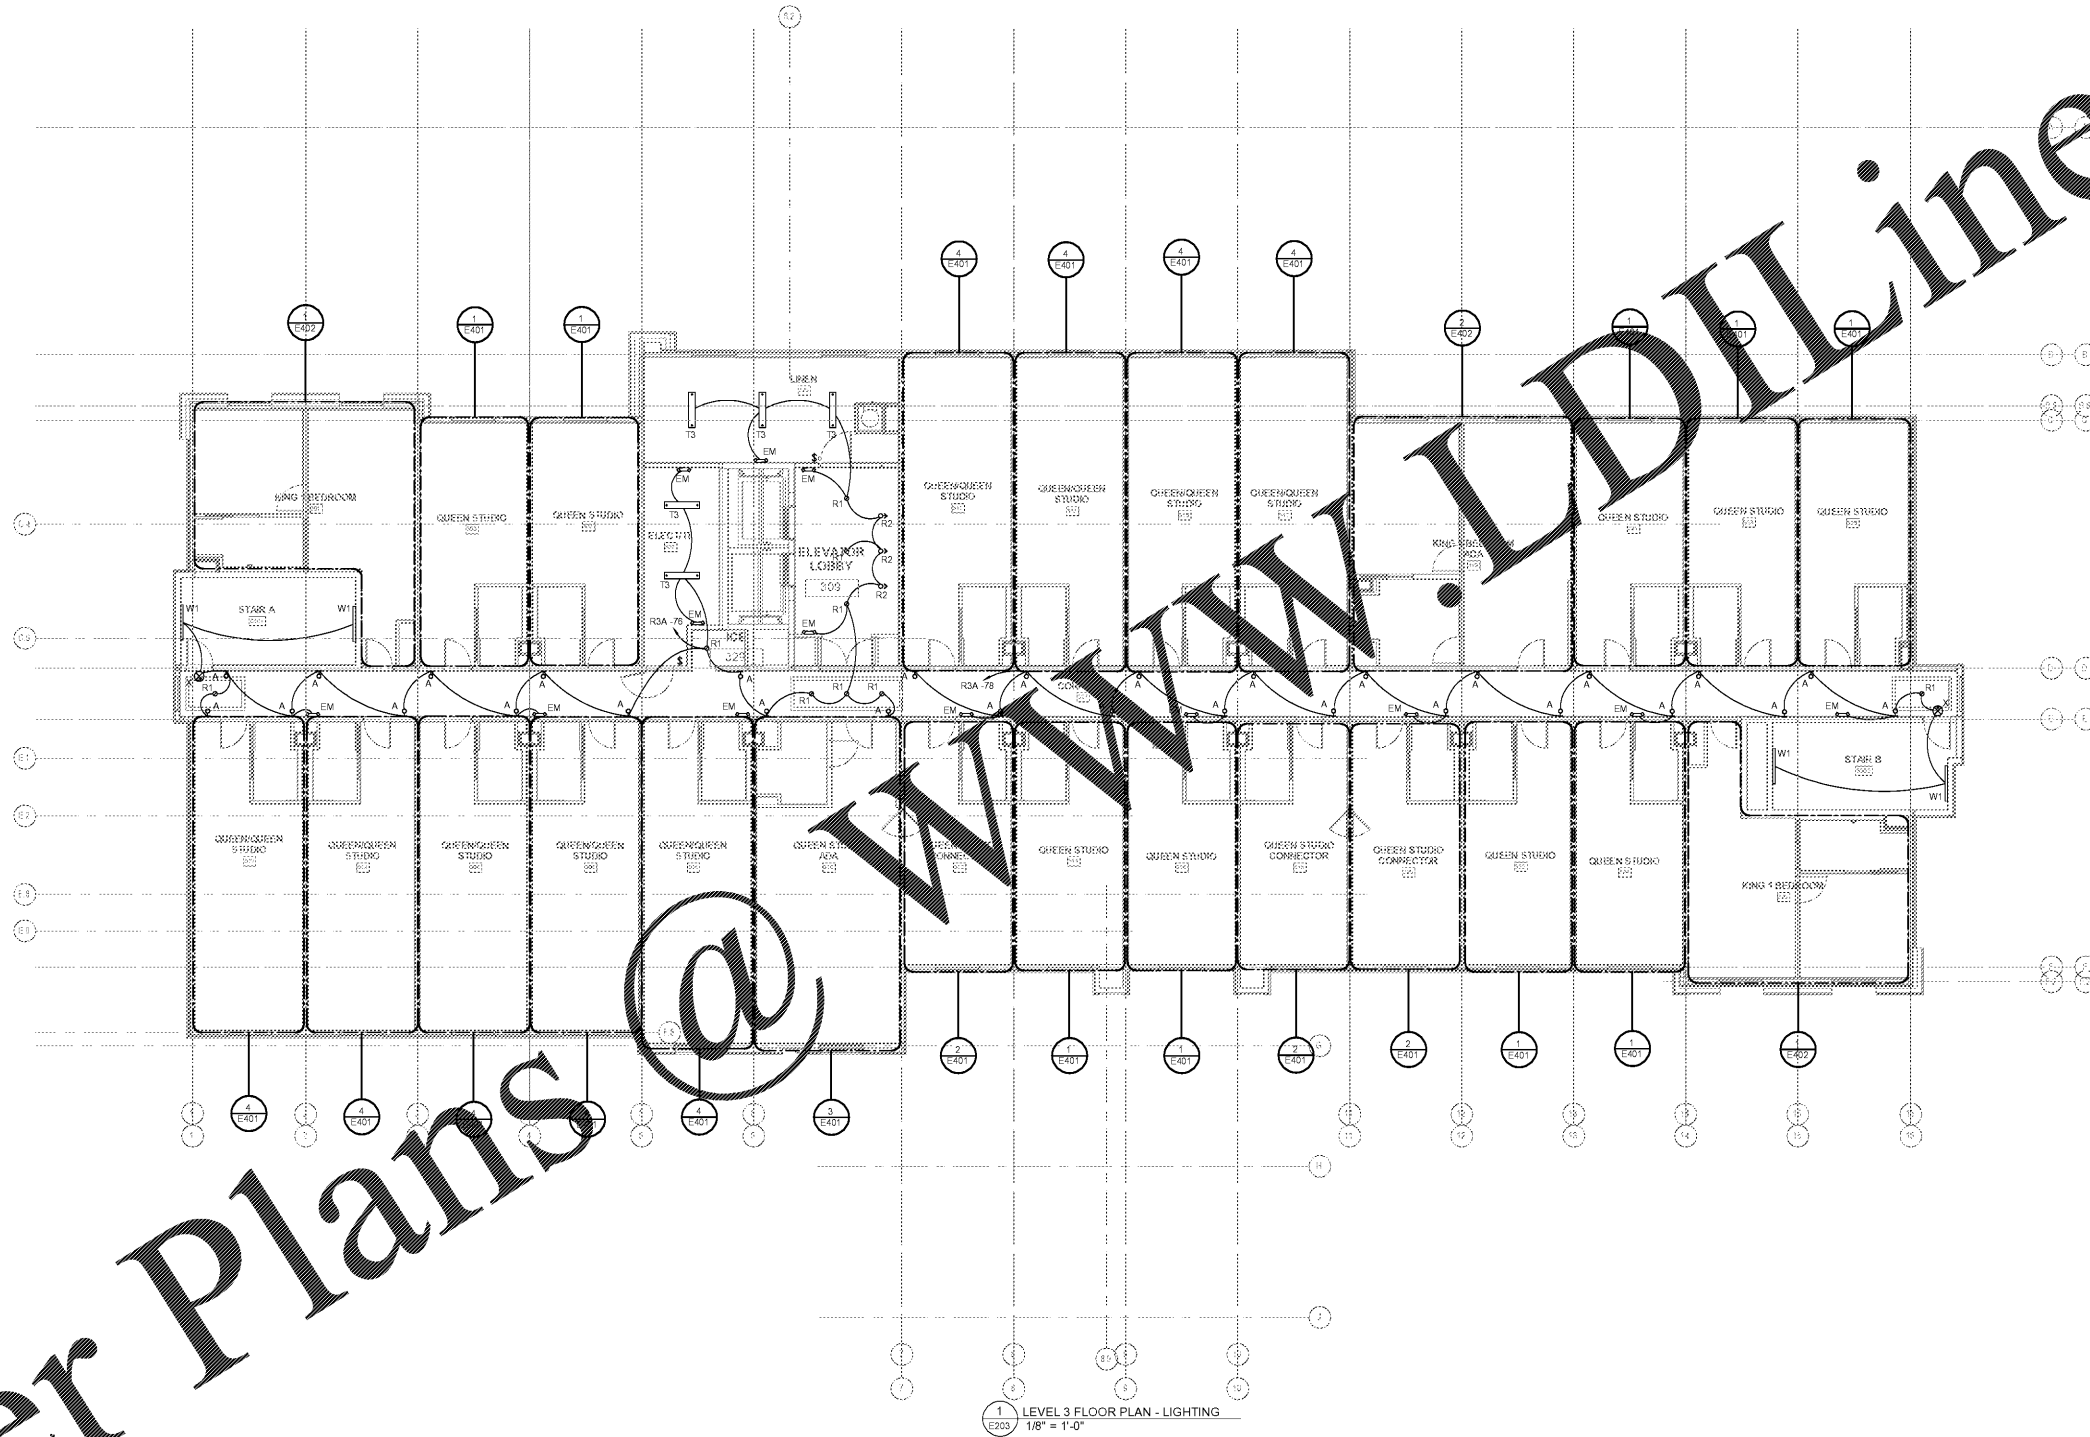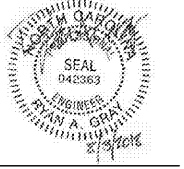

1 LEVEL 3 FLOOR PLAN - LIGHTING
E203 1/8" = 1'-0"

WINDSOR AUGHTRY

HOME2 ASHEVILLE

380 AIRPORT RD.
ASHEVILLE, NC 28704

SHEET ISSUE:
07/30/18
FOR CONSTRUCTION

Revisions		
Number	Description	Date

PRINCIPAL IN CHARGE:
PROJECT ARCHITECT:
DRAWN BY:
SHEET TITLE:
LEVEL 3 FLOOR
PLAN - LIGHTING

SHEET NO. PROJ. NO.
E203 017878.00

Order Plans @

WWW.LDLine.com