
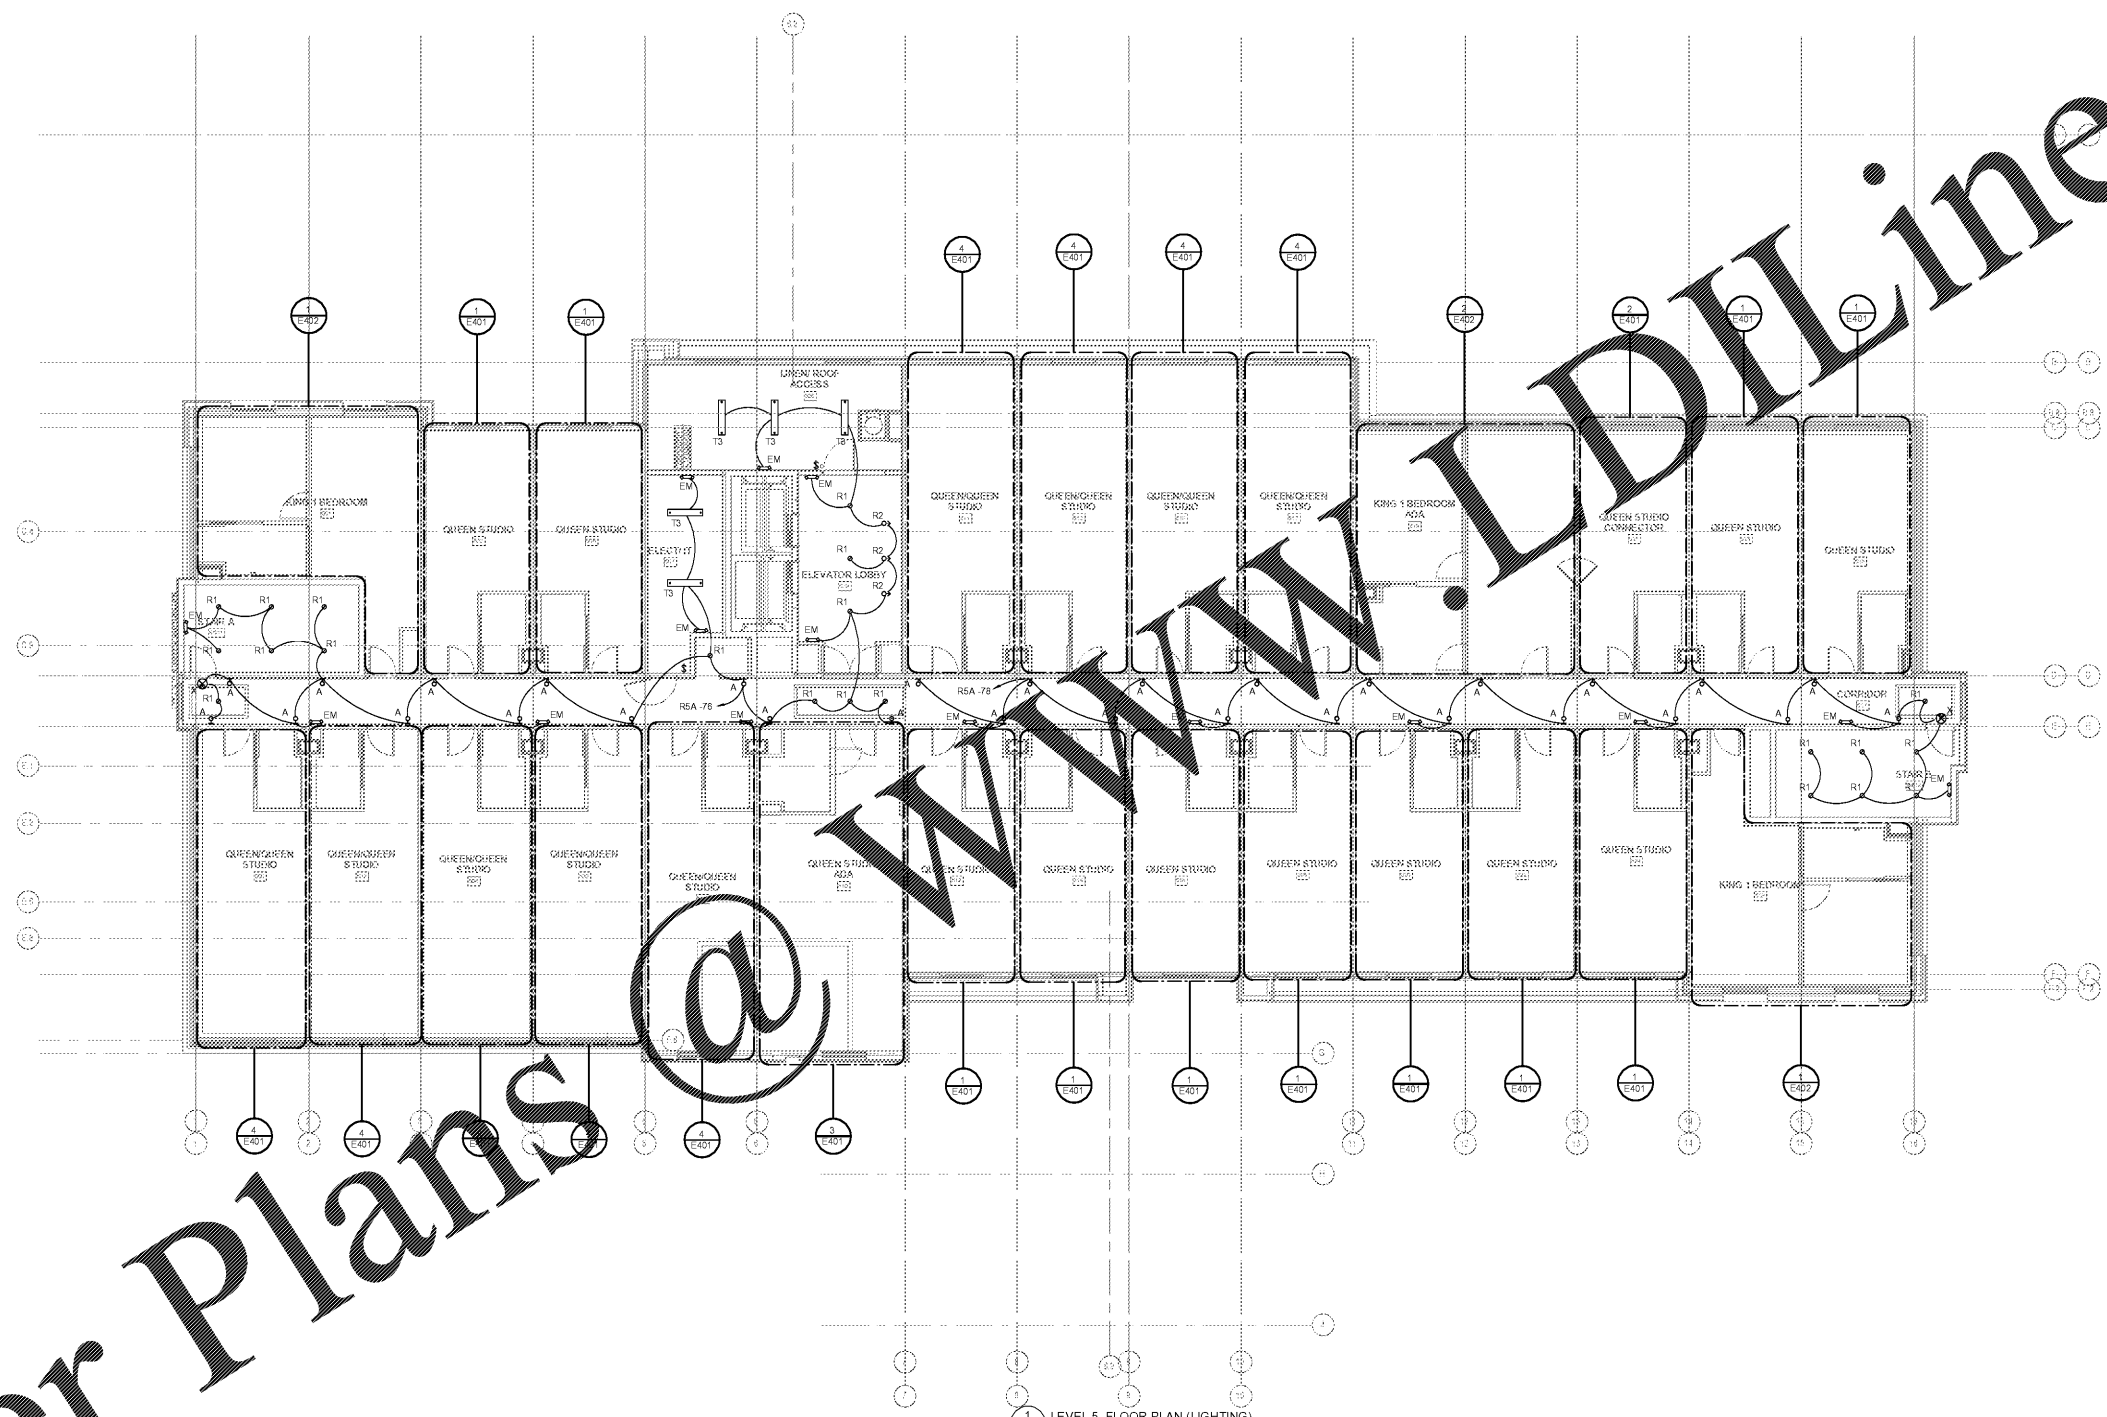


GENERAL NOTES:
 A REFERENCE ARCHITECTURAL REFLECTED CEILING PLAN FOR EXACT FIXTURE LOCATIONS

mcmilian
 pazdan
 smith
 ARCHITECTURE

CONSULTANT LOGO
DEVITA
 ATLANTA CHARLOTTE GREENVILLE
 RICHMOND
 877.4.DEVITA • info@devitainc.com
 Devita & Associates, Inc. Project: 17239
 NC Firm License # C-0819
 MS Checked By: RAG

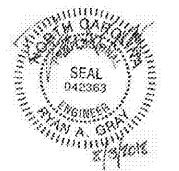

1 LEVEL 5 FLOOR PLAN (LIGHTING)
 E205
 1/8" = 1'-0"

WINDSOR AUGHTRY
 HOME2 ASHEVILLE
 380 AIRPORT RD.
 ASHEVILLE, NC 28704

SHEET ISSUE:
 07/30/18
 FOR CONSTRUCTION

Revisions		
Number	Description	Date

PRINCIPAL IN CHARGE:
 PROJECT ARCHITECT:
 DRAWN BY:
 SHEET TITLE:
**LEVEL 5 FLOOR
 PLAN - LIGHTING**

SHEET NO. PROJ. NO.
 E205 017878.00

Order Plans @

WWW.LDLINE.COM