



WINDSOR AUGHTRY

HOME2 ASHEVILLE

380 AIRPORT RD.
ARDEEN, NC 28704


SHEET ISSUE:
07/30/18
FOR CONSTRUCTION

Revisions		
Number	Description	Date

PRINCIPAL IN CHARGE:
PROJECT ARCHITECT:
DRAWN BY:
SHEET TITLE:
**UNDERGROUND
PIPING PLAN**

SHEET NO. PROJ. NO.
017878 00

P100

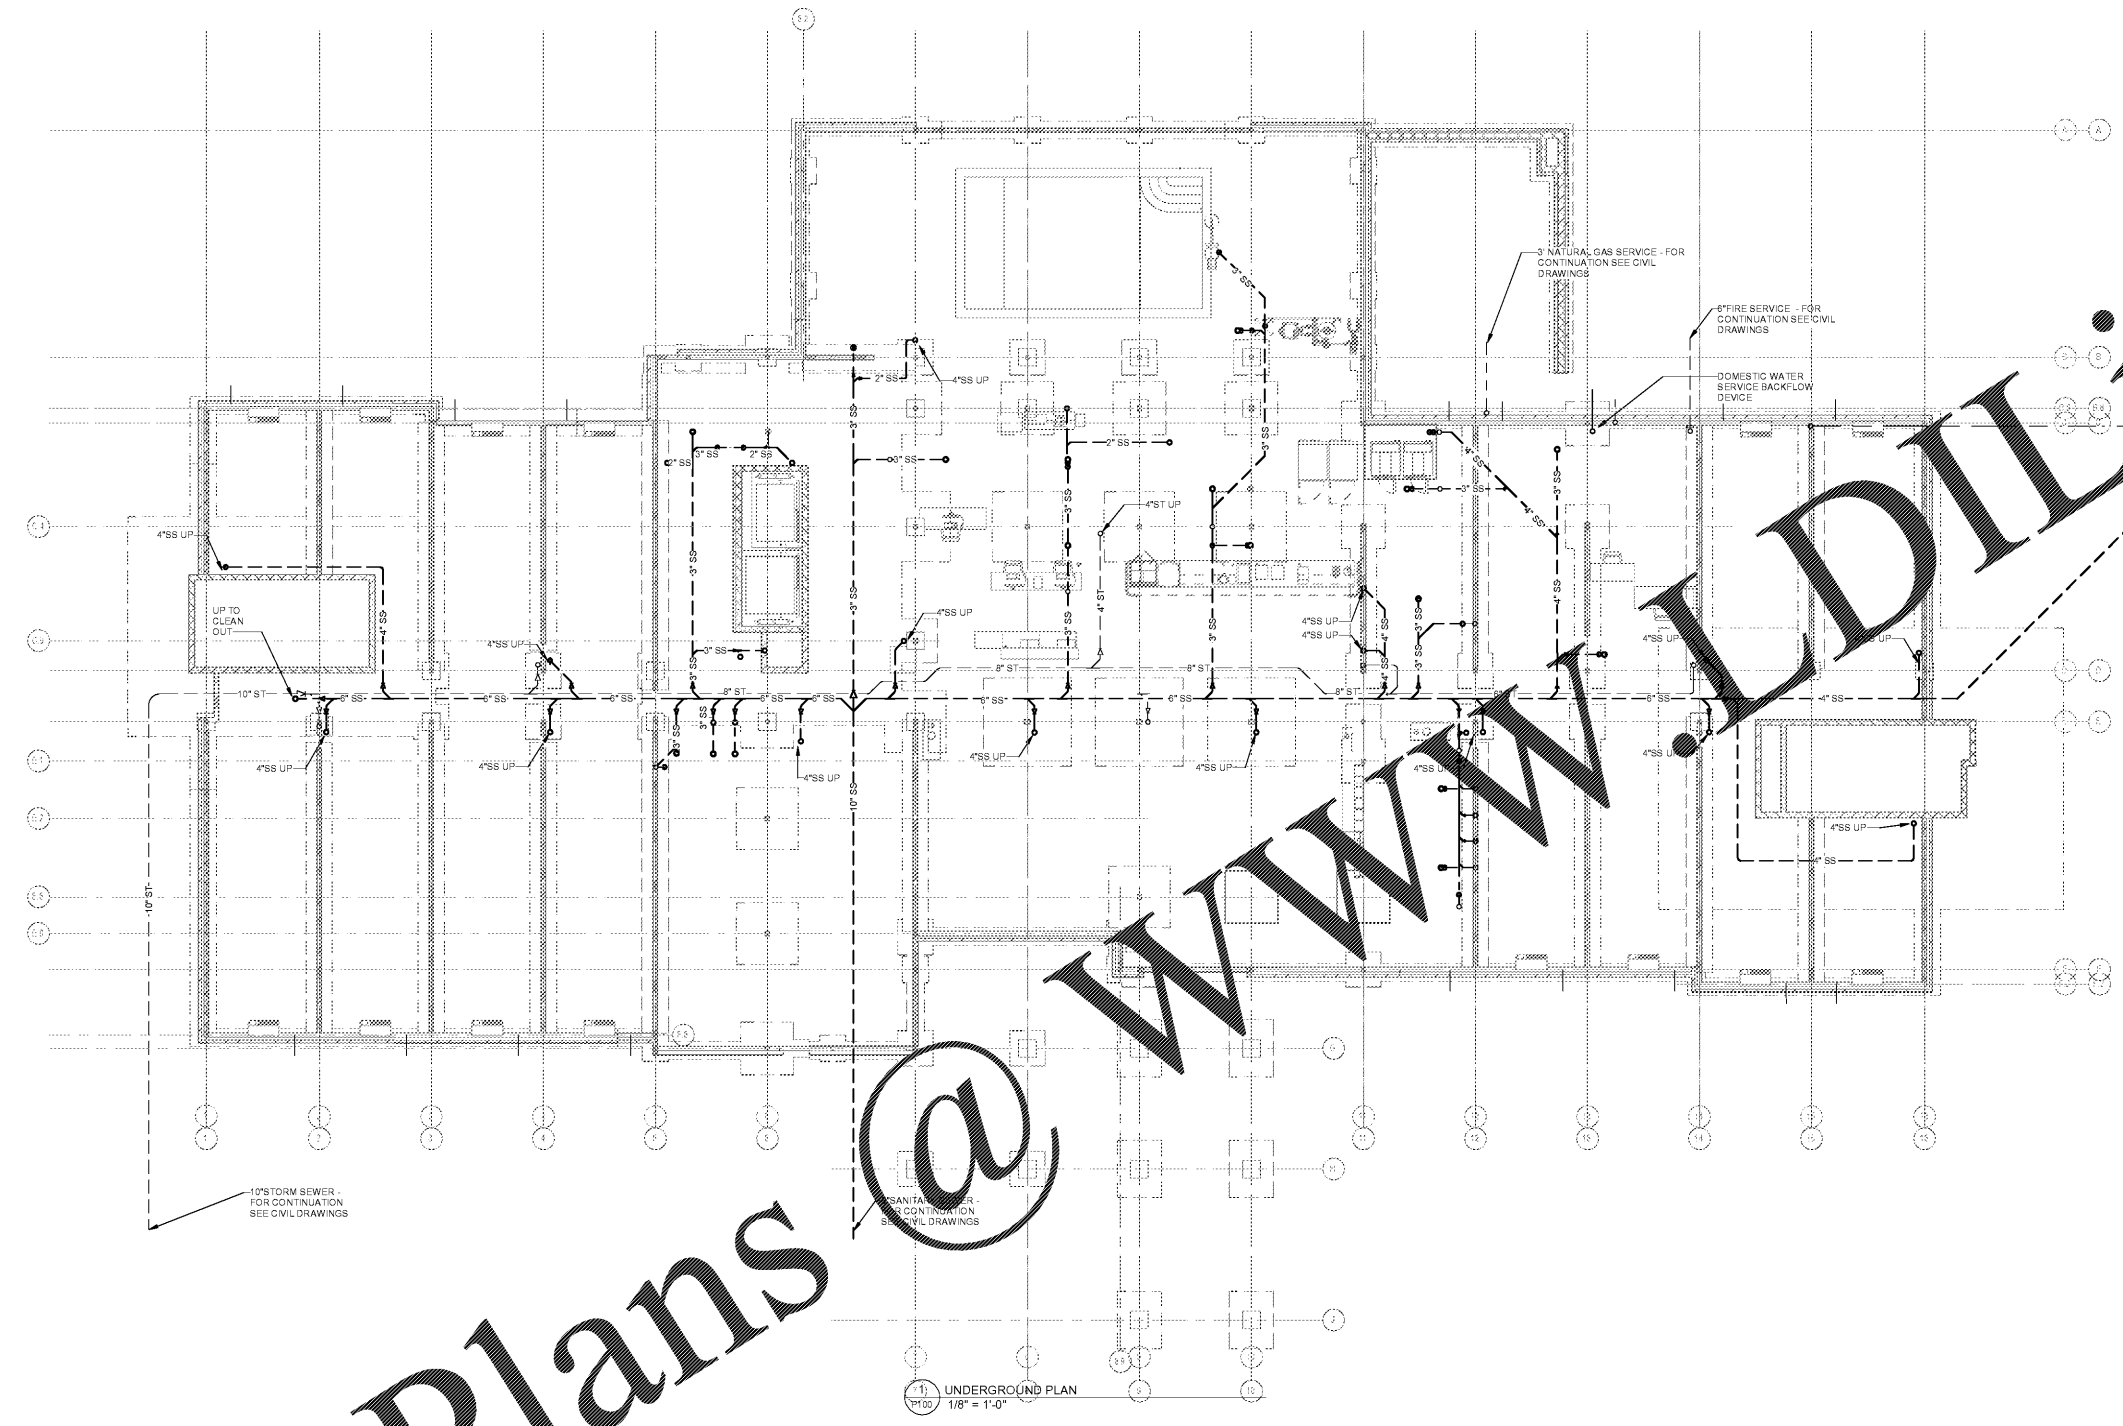

(1) UNDERGROUND PLAN
1/8" = 1'-0"

Order Plans @

WWW.DILine.com

AS SHOWN ON THESE DRAWINGS IS THE PROPERTY OF MCMILIAN PAZDAN SMITH ARCHITECTURE. NO PART OF THESE DRAWINGS IS TO BE REPRODUCED OR TRANSMITTED IN ANY FORM OR BY ANY MEANS, ELECTRONIC OR MECHANICAL, INCLUDING PHOTOCOPYING, RECORDING, OR BY ANY INFORMATION STORAGE AND RETRIEVAL SYSTEM, WITHOUT THE WRITTEN PERMISSION OF MCMILIAN PAZDAN SMITH ARCHITECTURE. ANY SUCH REPRODUCTION OR TRANSMISSION WITHOUT THE WRITTEN PERMISSION OF MCMILIAN PAZDAN SMITH ARCHITECTURE IS PROHIBITED. ALL RIGHTS ARE RESERVED.