




WINDSOR AUGHTRY
HOME2 ASHEVILLE
380 AIRPORT RD.
ASHEVILLE, NC 28704

SHEET ISSUE:
07/30/18
FOR CONSTRUCTION

Revisions		
Number	Description	Date

PRINCIPAL IN CHARGE:
PROJECT ARCHITECT:
DRAWN BY:
SHEET TITLE:
**OVERALL BUILDING
ROOF PLUMBING
PLAN**

SHEET NO. PROJ. NO.
P206 017878.00

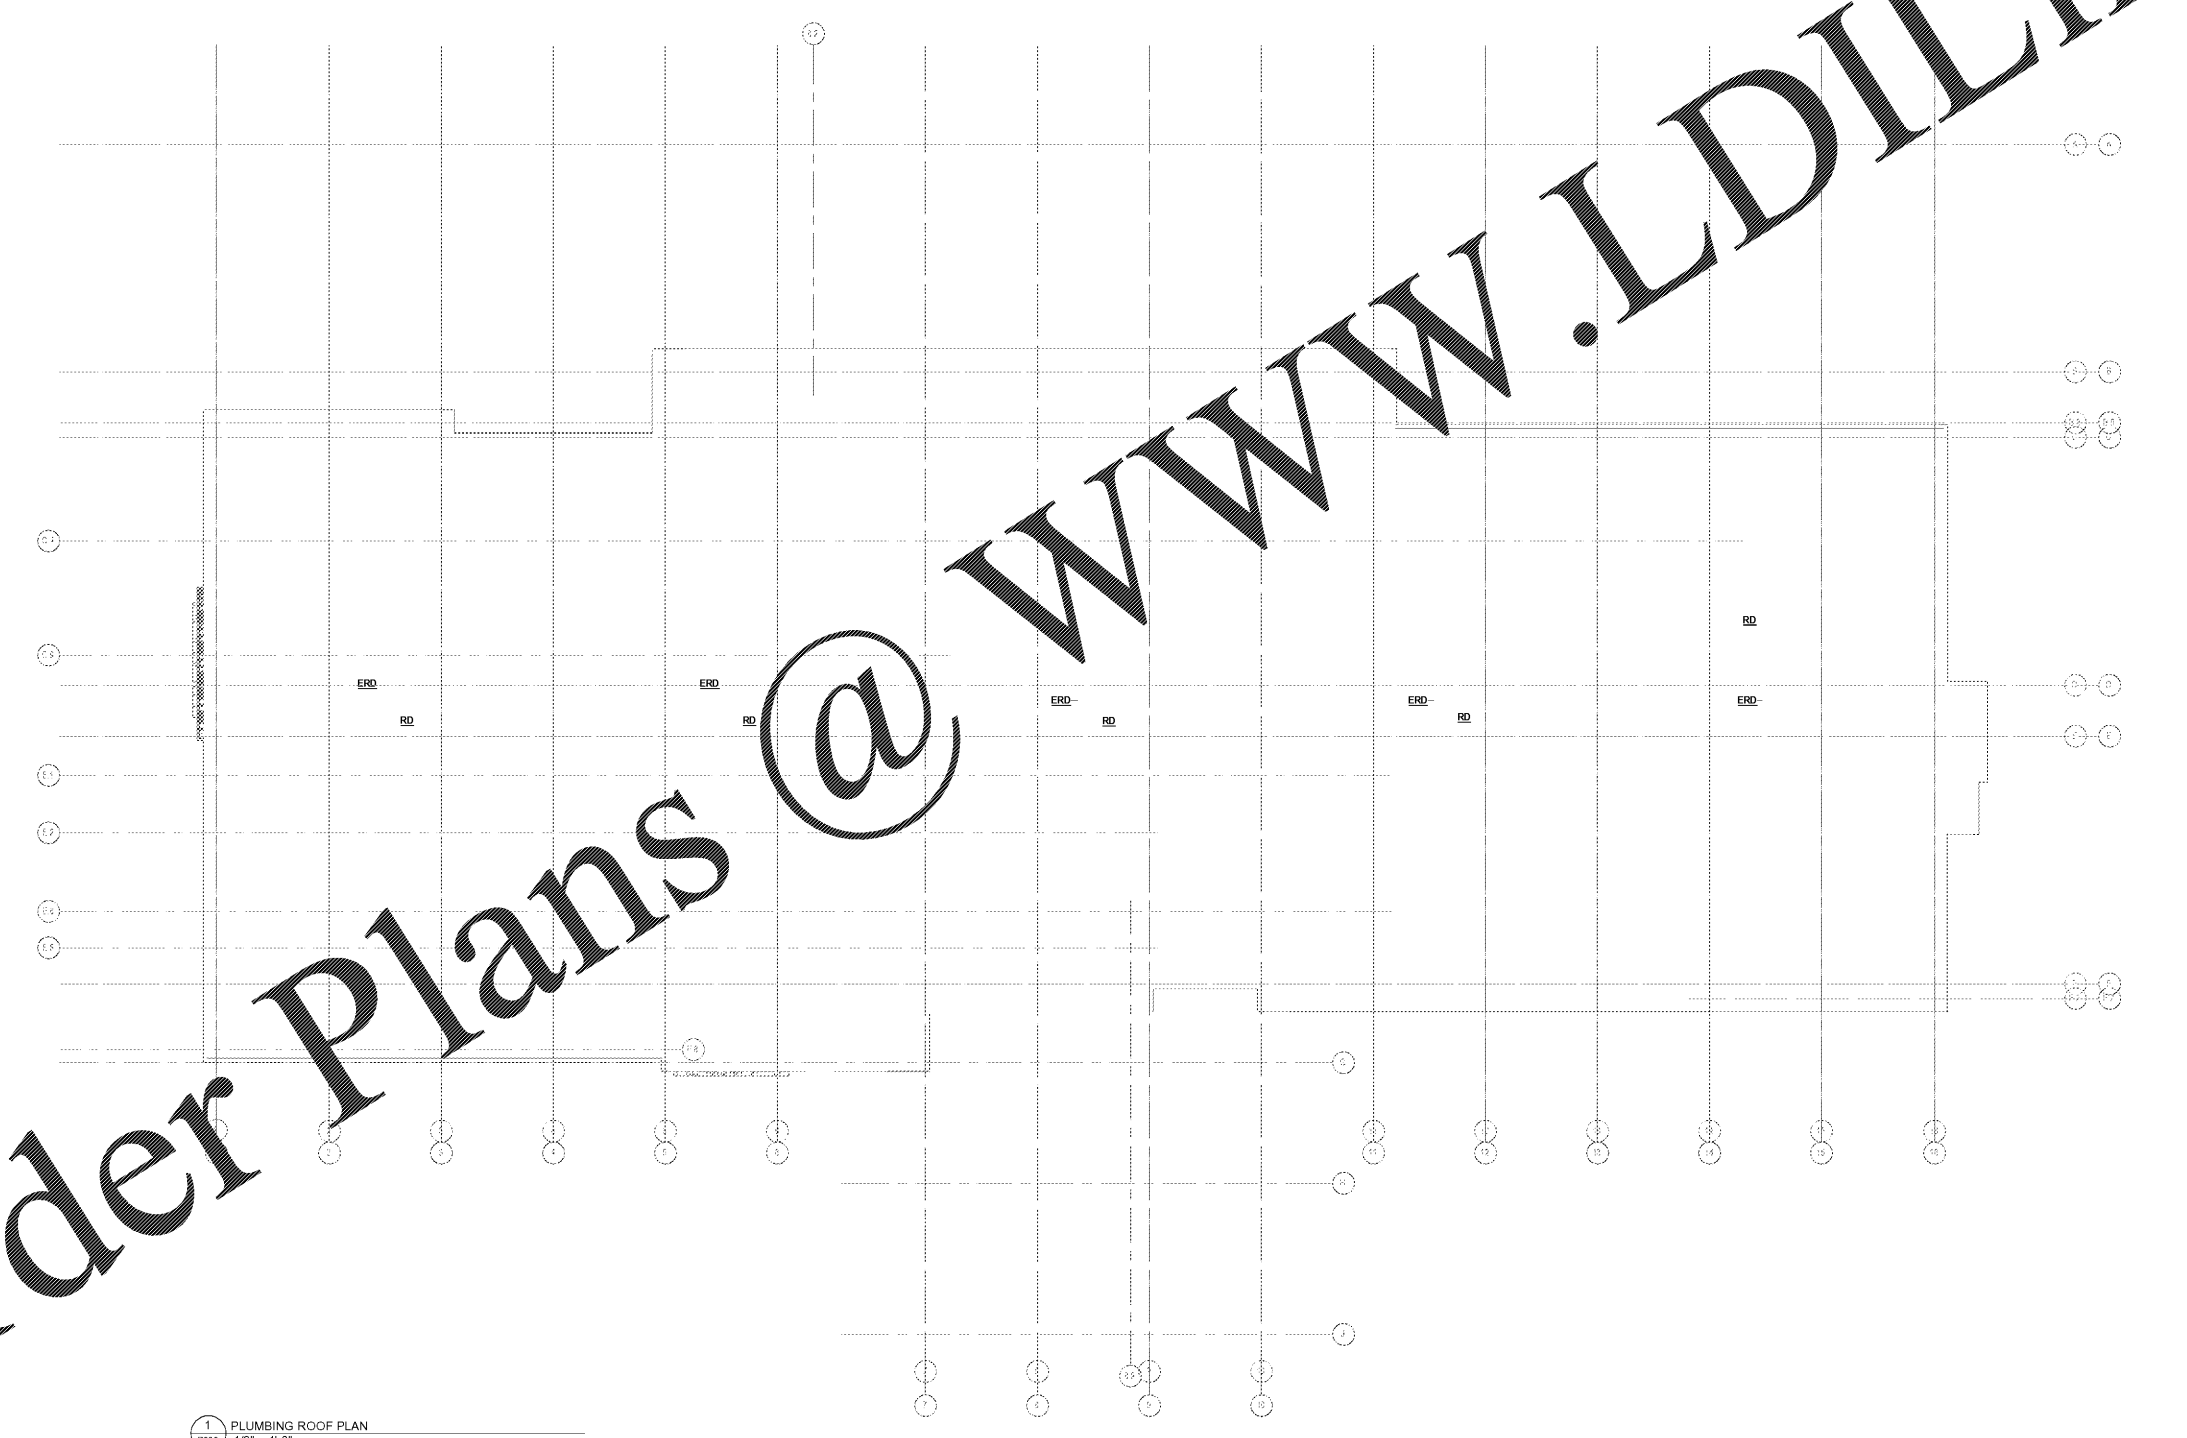

1 PLUMBING ROOF PLAN
P206 1/8" = 1'-0"

I hereby certify that I am a duly Licensed Professional Engineer in the State of North Carolina, License No. 037515, and that I am the author of the design shown on this drawing. I am not providing this drawing for any other project or for any other purpose. I am not providing this drawing for any other project or for any other purpose. I am not providing this drawing for any other project or for any other purpose.

Order Plans @ www.LDILine.com