


11/1/2018 3:27:08 PM

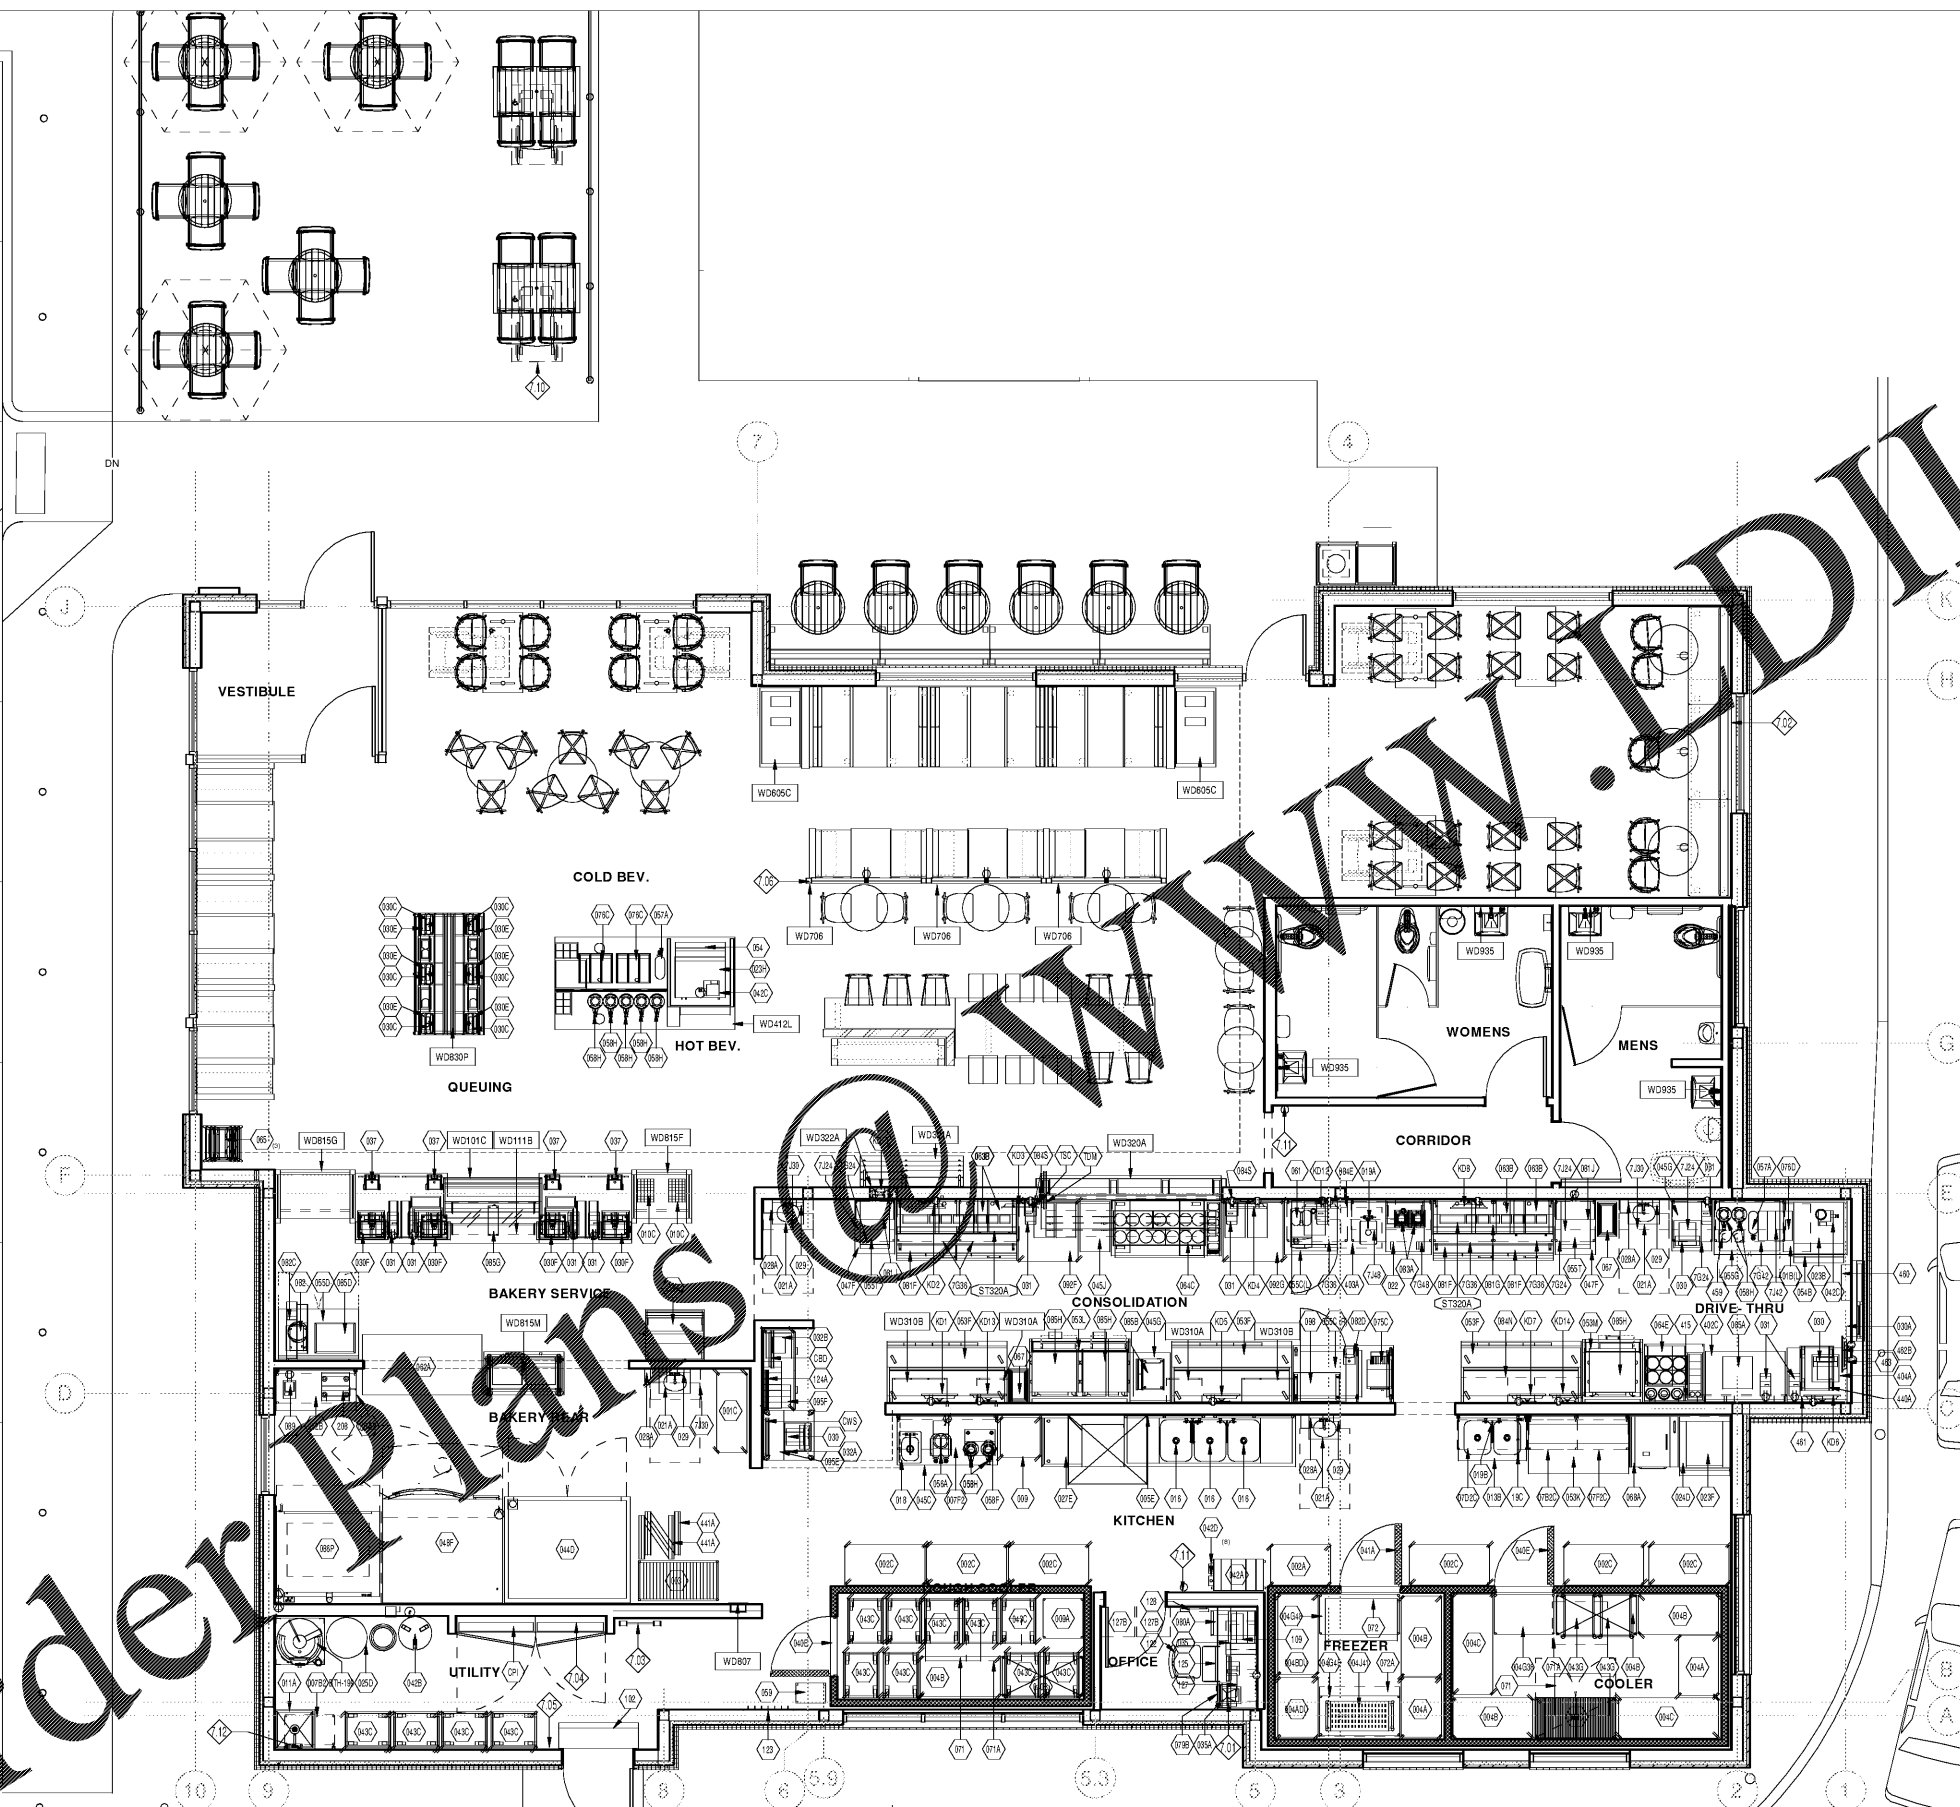

- ### KEYED NOTES
- 7.01 OFFICE SAFE TO BE INSTALLED FLUSH WITH THE FRONT OF THE DESK ON THE RIGHT HAND SIDE.
  - 7.02 FIRE SPRINKLER RISER LOCATION. FIRE SPRINKLER DESIGN PROVIDED BY OTHERS UNDER SEPARATE PERMIT.
  - 7.03 ALUMINUM ROOF LADDER
  - 7.04 CPI PANEL
  - 7.05 DETEX. SEE ELECTRICAL DRAWINGS
  - 7.06 DINING SCREEN WALL FURNITURE. REFER TO DETAILS SHEET A510 FOR SUPPORT TO STRUCTURE ABOVE DETAIL AND EQUIPMENT PLAN FOR SCREEN PLACEMENT LOCATION.
  - 7.10 ACCESSIBLE SEATING
  - 7.11 LOCATION OF APPROVED FIRE EXTINGUISHER RATED 2A-10BC LOCATE WITHIN 30' TRAVEL DISTANCE FROM LIQUE EXTINGUISHER.
  - 7.12 LOCATE MOP HOOKS THIS WALL. PROVIDE MINIMUM 6" CLEARANCE FROM ADJACENT SHELF.

- ### CUSTOM FINISH PACKAGE
- FURNITURE:**
- UPHOLSTERY: REFER TO PLAN TAGS
  - BOOTH TYPE: WOOD
  - COMMUNITY TABLE: PER PLAN
  - TABLE TOPS: PER PLAN
  - TABLE BASE TYPE: STANDARD
  - CHAIR TYPE: G4 PER PLAN
  - STOOL HEIGHT CHAIR: G4 PER PLAN
- TABLE SERVICE:**
- APPLICABLE TO THIS MARKET? YES
- CO2 MONITORING:**
- IS THIS REQUIRED? NO
- CAL13:**
- IS THIS REQUIRED? NO
- MILLWORK:**
- BAKERY FRONT PANELS: WD30
  - BREAD/BAGEL WALL: WD31
  - CHAIR RAIL/CAP: WD30
  - RPU UNIT FINISH: WD30
  - P2.0 WALL FINISH: WD33
- DESIGN NOTES:**

- ### EQUIPMENT PLAN LEGEND:
- XXX — ROOM NUMBER SYMBOL
  - XXXX — SIGNAGE IDENTIFICATION SYMBOL
  - XXXXX — EQUIPMENT IDENTIFICATION SYMBOL
  - STXXXX — STEEL IDENTIFICATION SYMBOL
  - WDXXXX — WOOD IDENTIFICATION SYMBOL
  - REL — RELOCATION INDICATION SYMBOL
  - FURXXX — FURNITURE IDENTIFICATION SYMBOL
  - 101 — DOOR NUMBER SYMBOL
  - 7 — FABRIC DESIGNATION SYMBOL

Bakery-Cafe: **#6119**

SYSTEM: G4 (A700)

Project Title:

whoo.com


p.o. box 14,2116  
coral gables, florida  
33114,2116  
v. 305.445.3100  
f. 305.259.3986  
license number: AA26002436

Professional Seal:

architect of record: William F. Arthur  
License Number: AR0012074

Project Title:

**Bakery Cafe #6119**  
6351 MANATEE AVE W,  
BRADENTON, FL 34209

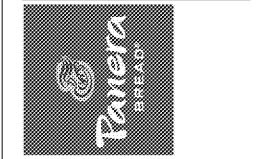

These plans and specifications are the exclusive property of WFA Design. Any reproduction, modification, distribution, and/or use of these materials (or any portion thereof) without WFA Design's prior written consent is strictly prohibited.

No.	Description	Date

### FLOOR PLAN EQUIPMENT

Project Number: #6119 Sheet Number: **A700**

Drawn By: MMH/NH

Issue Date: 09.30.18

DFM: DM: CPM: J.R. D.C. R.K.

1 FLOOR PLAN - EQUIPMENT PLAN  
1/4" = 1'-0"

Order Plans @ [whoo.com](mailto:whoo.com)

WHOO.COM