


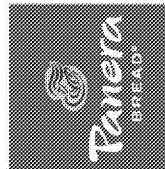

Engineering Consultant

Bakery Cafe #6119
 6351 MANATEE AVE. W,
 BRADENTON, FL 34209


ISSUE FOR REVIEW



NO.	DESCRIPTION	DATE

PLUMBING DETAILS

Project Number: _____ Sheet Number: _____
 Drawn: CLL Checked: GSH
 Issue Date: 10/01/18
 DPM: _____ DM: _____ CPM: _____
 BS: _____ DM: _____ ME: _____

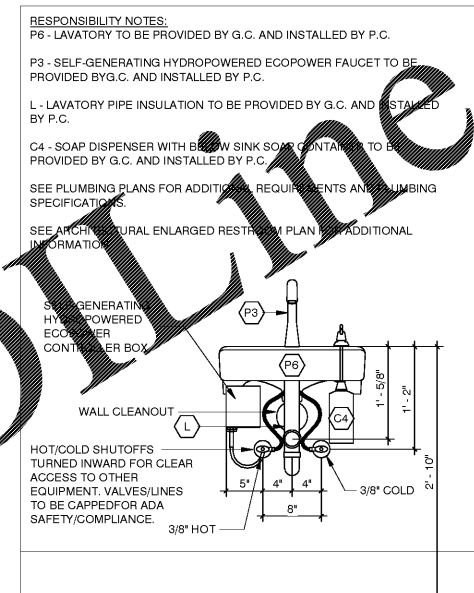

4 LAVATORY DETAIL
 SCALE: 1/4" = 1'-0"

DBM SERIES SUPPORT BASE WITH RISER ROD & CLAMP


- Base with 1/2"-16 threaded rod and B3198H clamp - see chart for height, width and length
- 100% recycled rubber. UV resistant.
- Load Rating** 50 lbs. (Ø.22KN) (Ultimate Load)*
- Dura-Blok™ DBM-Series pipe/tubing support is designed for support of single piping systems where elevation adjustment is needed. The Dura-Blok is UV resistant and suitable for installation on any type of roofing material or other flat surfaces.

Part No.	Clamp Part No.†	Block -Height x Width x Length In.	Height** Min.-Max. (mm)	Wt./Each Lbs. (kg)
DBM-1/2CT	B3198HCT-1/2	4" x 6" x 4.8" (101.6 x 152.4 x 121.9)	9.69"-11.19" (246.1-284.2)	2.75 (1.25)
DBM-3/4CT	B3198HCT-3/4	4" x 6" x 4.8" (101.6 x 152.4 x 121.9)	9.84"-11.34" (249.9-288.0)	2.76 (1.25)
DBM-1CT	B3198HCT-1	4" x 6" x 4.8" (101.6 x 152.4 x 121.9)	9.95"-11.45" (252.7-290.5)	2.84 (1.29)
DBM-1 1/4CT	B3198HCT-1 1/4	4" x 6" x 4.8" (101.6 x 152.4 x 121.9)	10.13"-11.63" (257.3-295.4)	2.95 (1.34)
DBM-1 1/2CT	B3198HCT-1 1/2	4" x 6" x 4.8" (101.6 x 152.4 x 121.9)	10.28"-11.78" (261.1-299.2)	2.96 (1.34)
DBM-2CT	B3198HCT-2	4" x 6" x 4.8" (101.6 x 152.4 x 121.9)	10.53"-12.03" (267.4-305.5)	3.03 (1.37)
DBM-1/2	B3198H-1/2	4" x 6" x 4.8" (101.6 x 152.4 x 121.9)	9.86"-11.36" (250.4-288.5)	2.78 (1.26)
DBM-3/4	B3198H-3/4	4" x 6" x 4.8" (101.6 x 152.4 x 121.9)	10.06"-11.56" (255.5-293.6)	2.84 (1.29)
DBM-1	B3198H-1	4" x 6" x 4.8" (101.6 x 152.4 x 121.9)	10.14"-11.64" (257.5-295.6)	2.86 (1.30)
DBM-1 1/4	B3198H-1 1/4	4" x 6" x 4.8" (101.6 x 152.4 x 121.9)	10.25"-11.75" (260.3-298.4)	2.94 (1.33)
DBM-1 1/2	B3198H-1 1/2	4" x 6" x 4.8" (101.6 x 152.4 x 121.9)	10.42"-11.92" (264.6-302.7)	2.99 (1.35)
DBM-2	B3198H-2	4" x 6" x 4.8" (101.6 x 152.4 x 121.9)	10.66"-12.16" (270.7-308.6)	3.10 (1.39)

† See Pipe Hanger Catalog for dimensions and specifications. ** From bottom of rubber block to center of pipe/tubing.


* General Note: Consult roofing manufacturer or engineer for proper load capacity. The weakest point may be the insulation located beneath the rubber mounting.

5 CONDENSATE LINE ROOF SUPPORT
 SCALE: 6" = 1'-0"

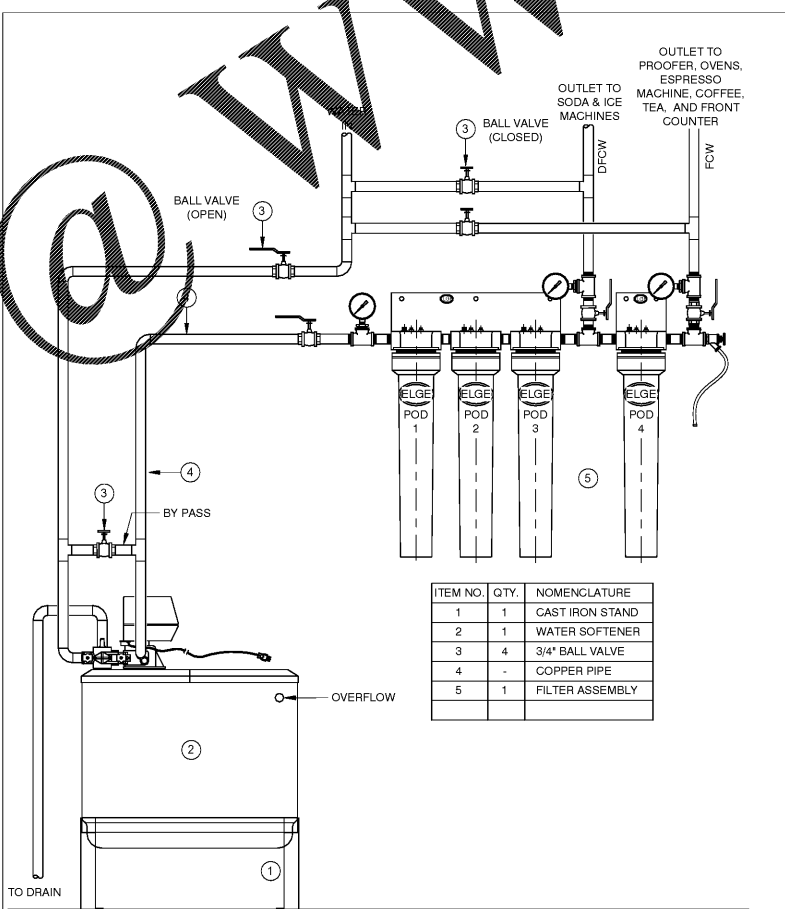


2 WATER FILTER SYSTEM DETAIL (ALTERNATE)
 SCALE: NTS


ALTERNATE WATER FILTER SYSTEM OPTION. VERIFY WATER FILTER TO BE PROVIDED WITH CONSTRUCTION MANAGER

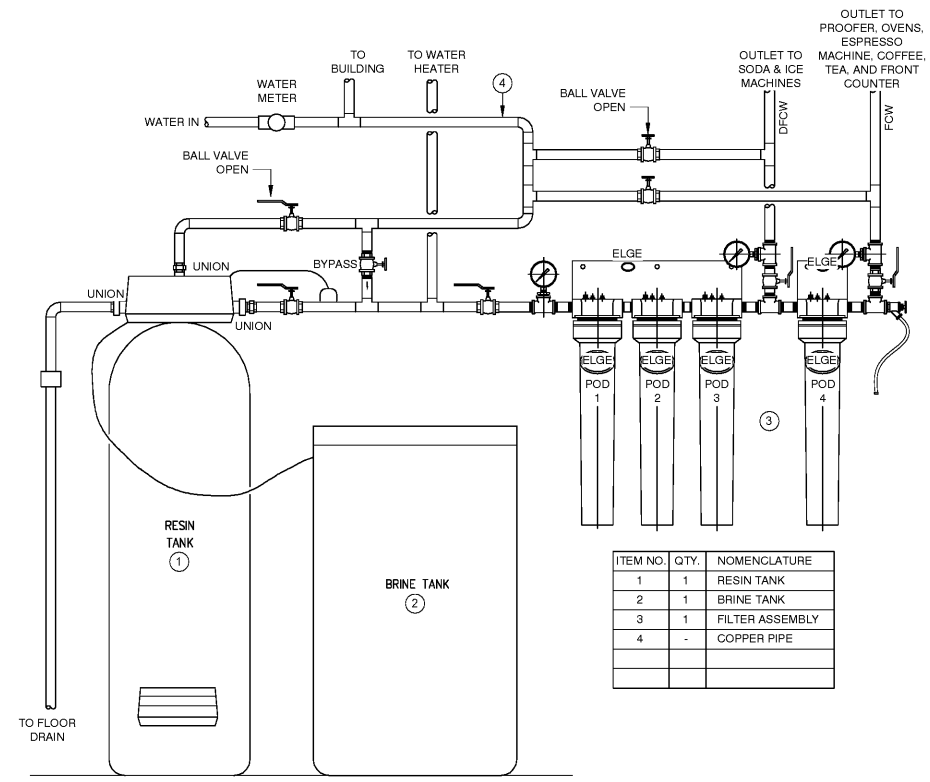

6 WATER FILTER SYSTEM DETAIL
 SCALE: NTS

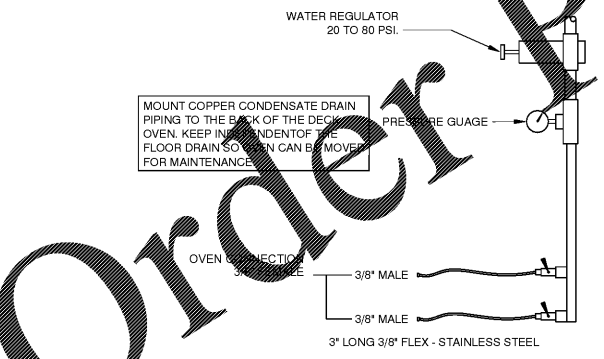

3 2 DECK OVEN WATER SUPPLY DETAIL
 SCALE: NTS

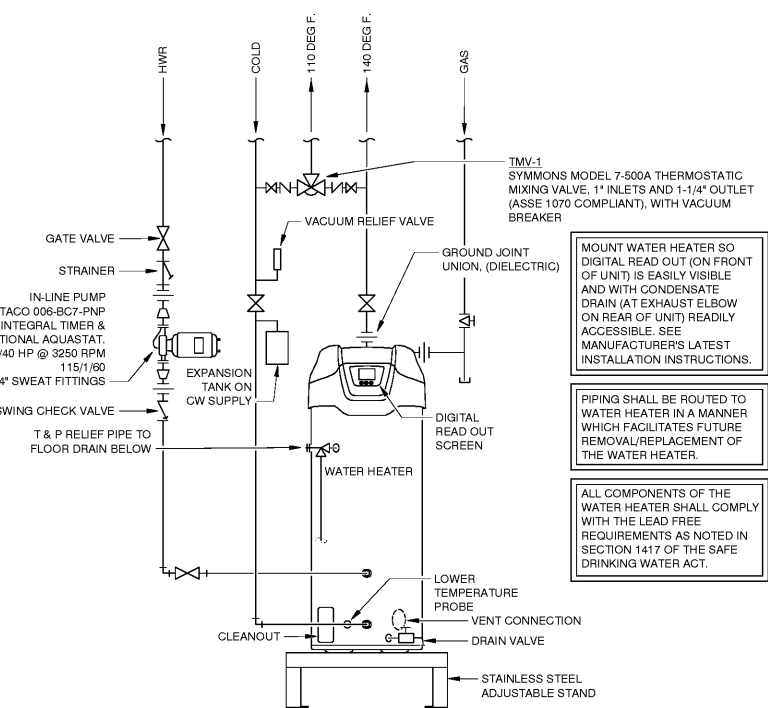

1 WATER HEATER DETAIL
 SCALE: NTS

Order Plans