


Order Plans @

WWW.LDILine.com

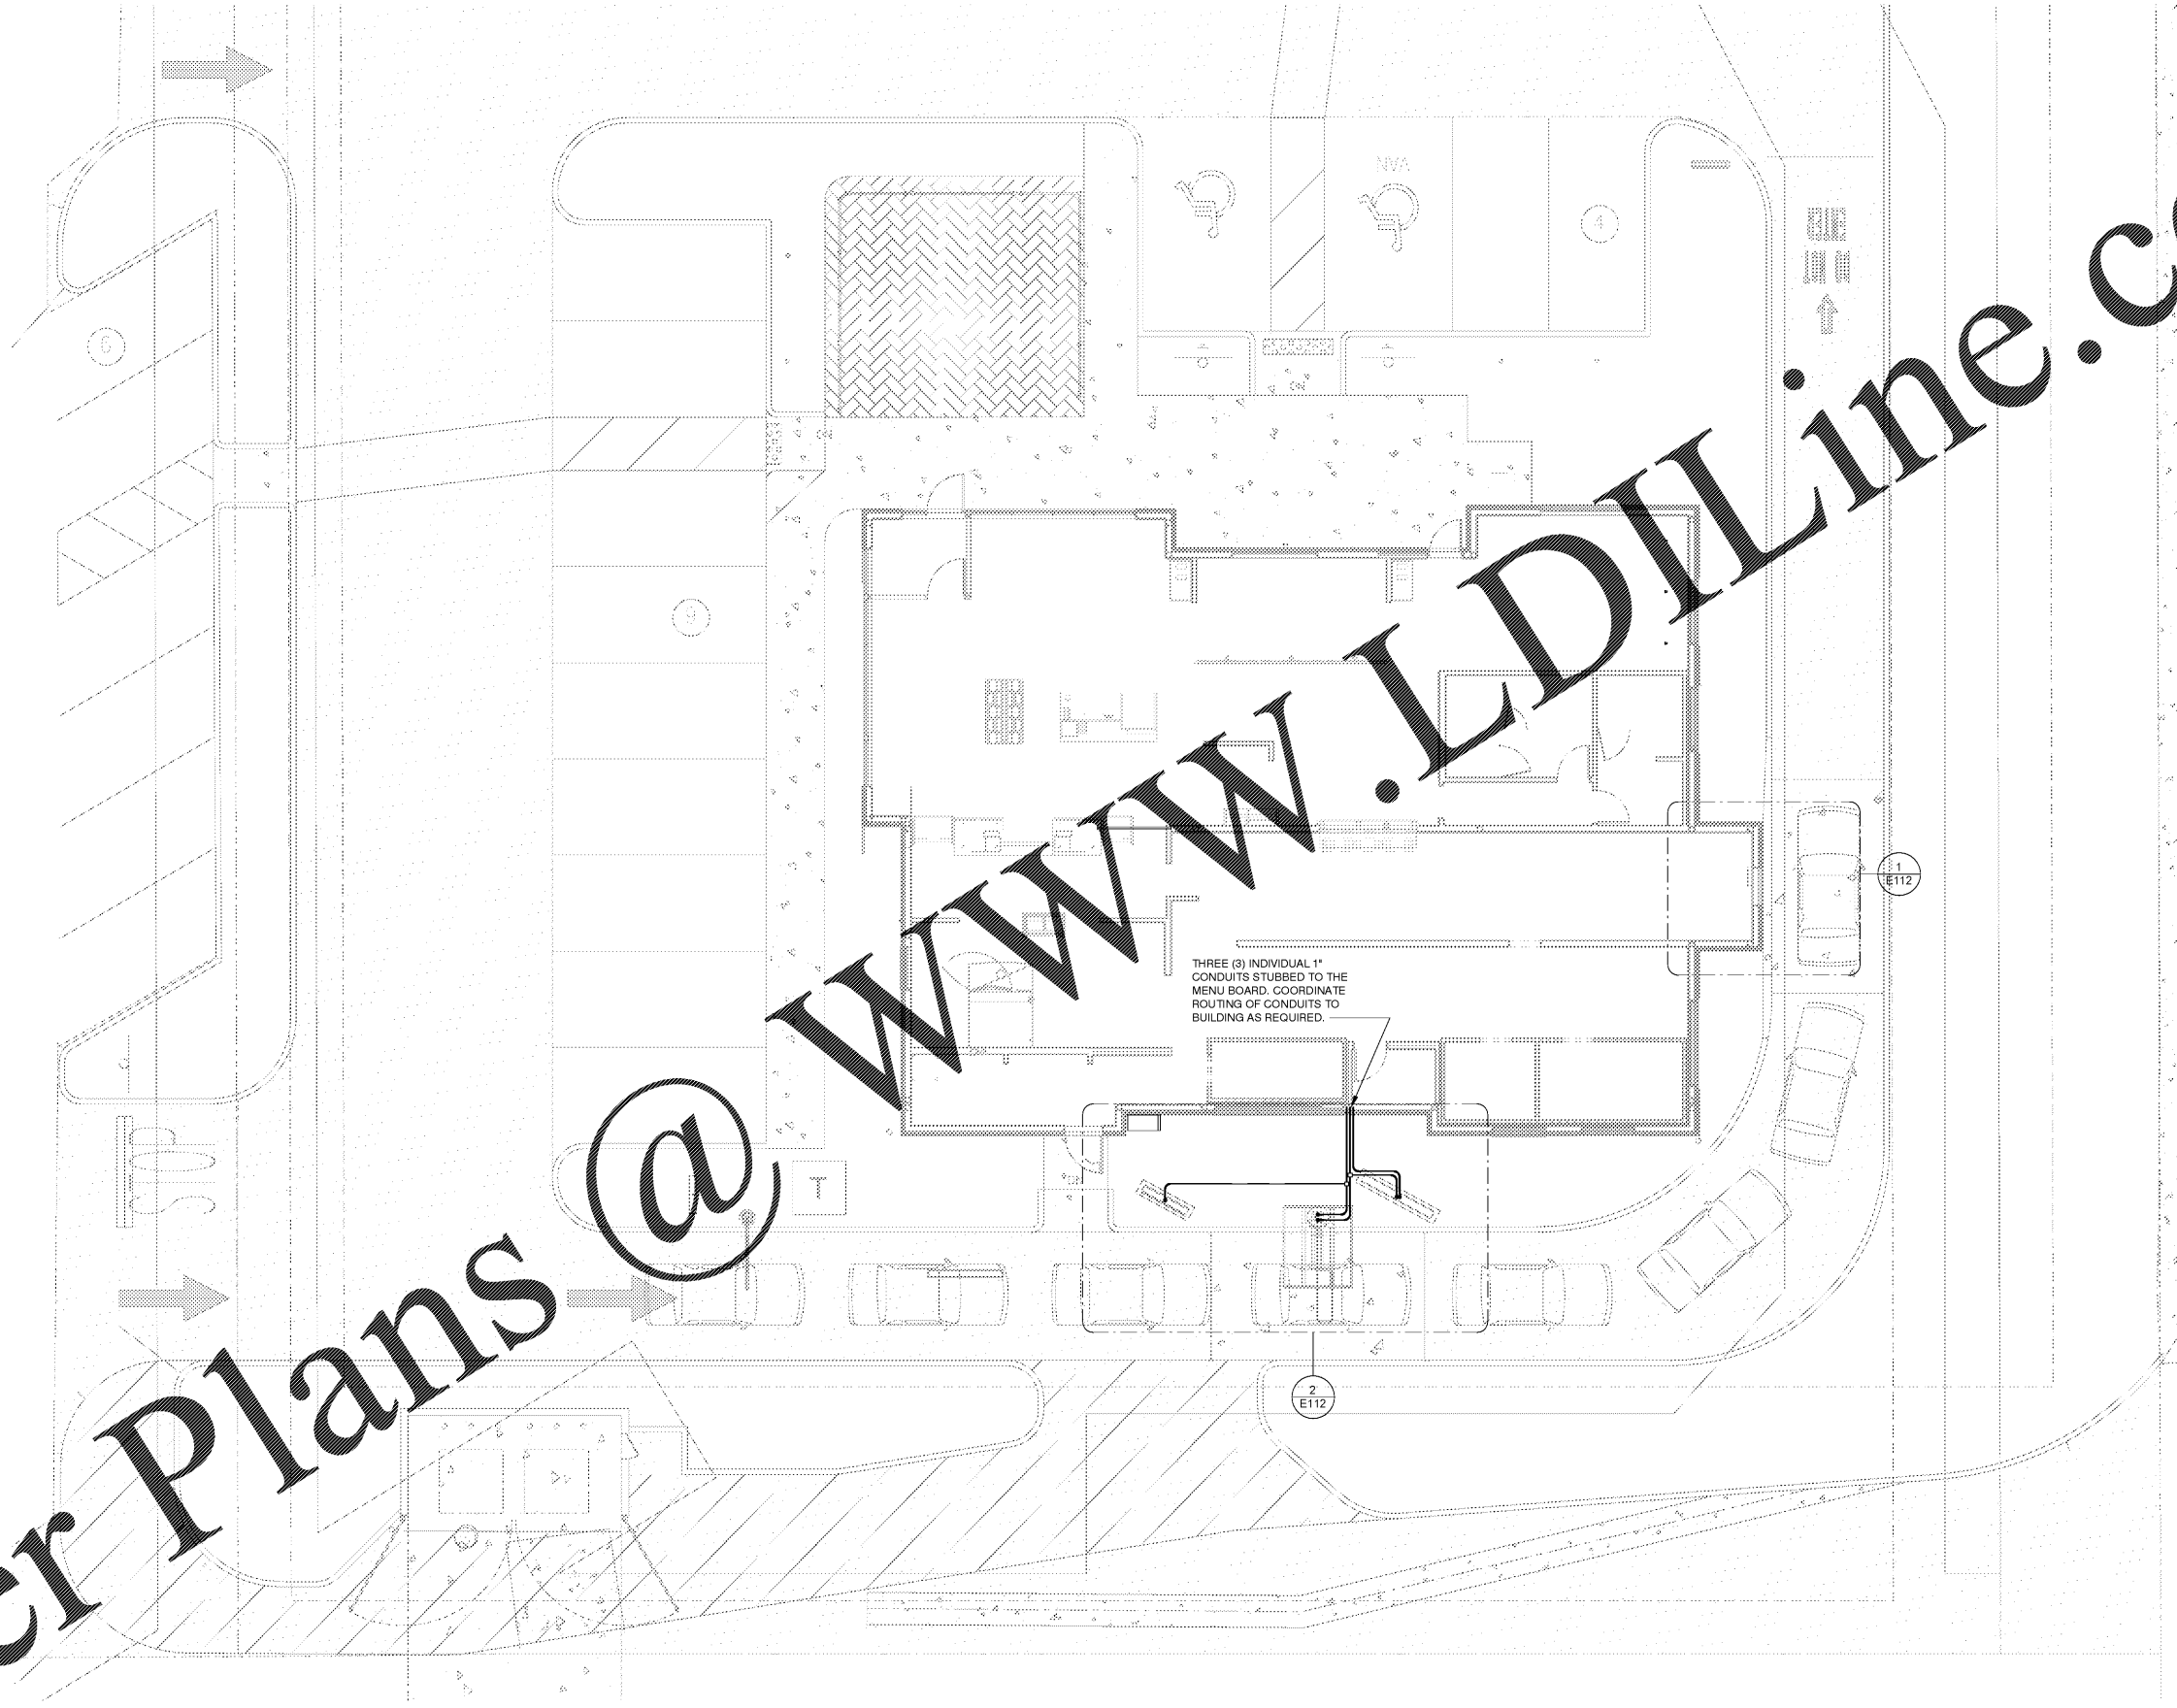

THREE (3) INDIVIDUAL 1" CONDUITS STUBBED TO THE MENU BOARD. COORDINATE ROUTING OF CONDUITS TO BUILDING AS REQUIRED.

1 ELECTRICAL DRIVE-THRU SITE PLAN
1/8" = 1'-0"



NOTE:
SEE ARCHITECTURAL SITE PLAN FOR ADDITIONAL INFORMATION ON FIXTURE LOCATIONS.
SEE SHEET E112 FOR ENLARGED PLAN OF DRIVE THRU
VERIFY SITE LIGHTING REQUIREMENTS WITH CIVIL PLANS AND EXTERIOR LIGHTING DESIGN. PROVIDE POWER AS REQUIRED FROM PANEL LP AND MARK CIRCUITS TO BE CONNECTED TO EXTERIOR TIME CLOCK.




William J. Akers
383 Manatee Ave. W.
St. Louis, MO 63119
Phone (314) 772-1782
Fax (314) 772-1783

Engineering Consultant

ISSUE FOR REVIEW

Bakery Cafe #6119
6351 MANATEE AVE. W,
BRADENTON, FL 34209

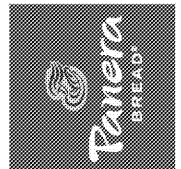

| NO. | DESCRIPTION | DATE |
|-----|-------------|------|
| | | |
| | | |
ELECTRICAL DRIVE THRU SITE PLAN

Project Number: 449-18
Sheet Number: **E111**
Drawn: CJS
Checked: NJD
Issue Date: 10/01/18
DPM: DM: CPM:
BS: DM: ME: