




Engineering Consultant

William J. Akers
383 Maplewood
St. Louis, MO 63119
Phone (314) 772-1782
Fax (314) 577-2504

Bakery Cafe #6119

**6351 MANATEE AVE. W,
BRADENTON, FL 34209**

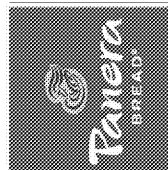


NO.	DESCRIPTION	DATE

ELECTRICAL ENLARGED SITE PLANS


Project Number: 449-18 Sheet Number: **E112**
 Drawn: CJS Checked: NJD
 Issue Date: 10/01/18
 DPM: DM: CPM
 BS: DM: ME

Order Plans @ www.LDOnline.com

www.LDOnline.com

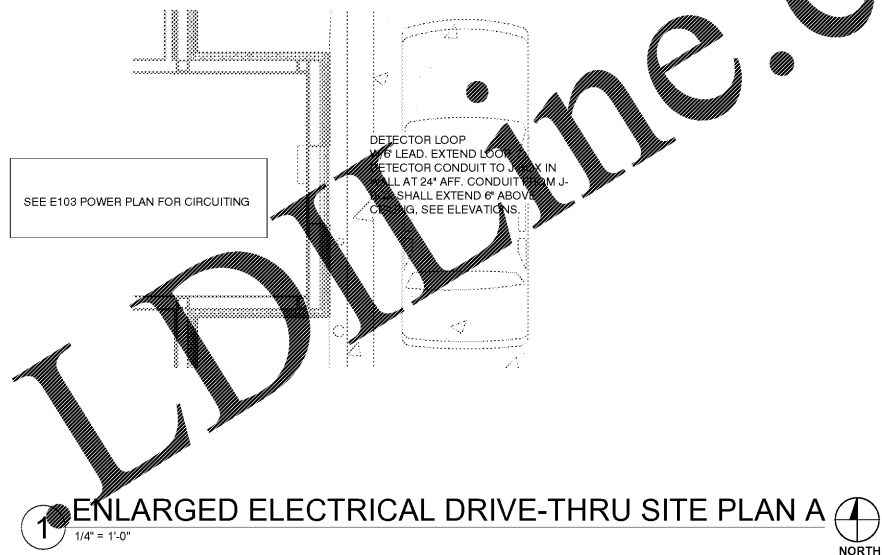

1 ENLARGED ELECTRICAL DRIVE-THRU SITE PLAN A
1/4" = 1'-0" NORTH

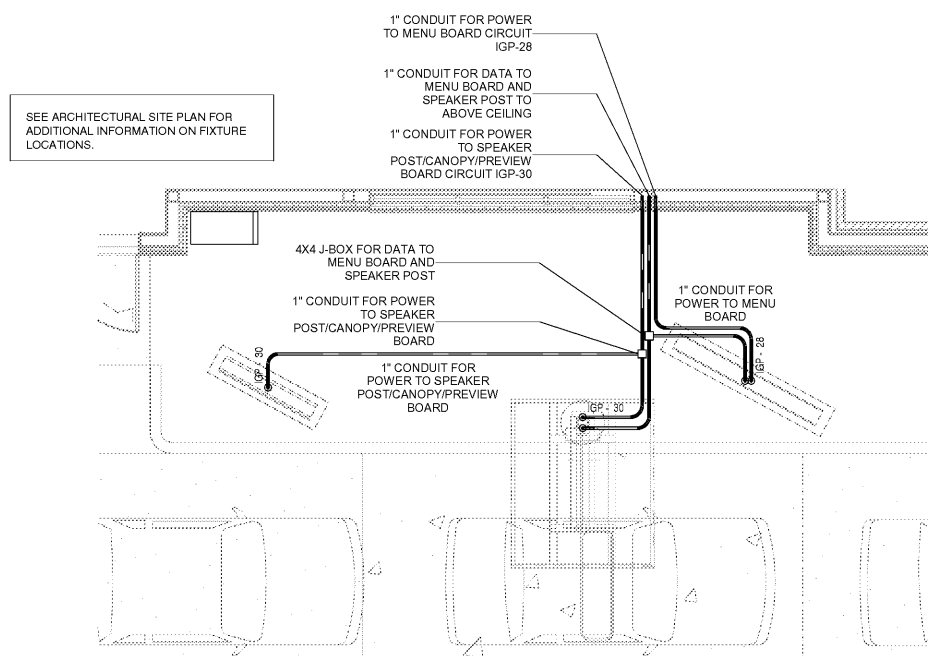

2 ENLARGED ELECTRICAL DRIVE-THRU SITE PLAN B
1/4" = 1'-0" NORTH