
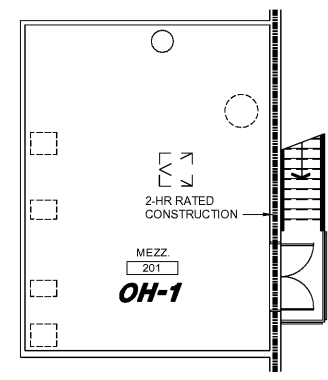


CONSTRUCTION NOTES:
① - 6"Ø INCOMING FIRE PROTECTION SERVICE. BFP, FDC, AND PIV LOCATED OUTSIDE BUILDING. SEE CIVIL DRAWINGS FOR CONTINUATION.
② - 6"Ø SERVICE ENTRANCE. 4"Ø RISER. (SEE FIRE SPRINKLER RISER SCHEMATIC 1/F-001)


1980
 Architects • Engineers • Interior Architects
JOHNSON, LASCOBOR & ASSOCIATES, P.C.
 1001 W. MARKET ST., SUITE 100 • MT. PLEASANT, SC 29566
 TEL: (706) 724-5756 • TEL: (843) 619-4656
 FAX: (706) 724-3935
 WWW.THEJLAGROUP.COM

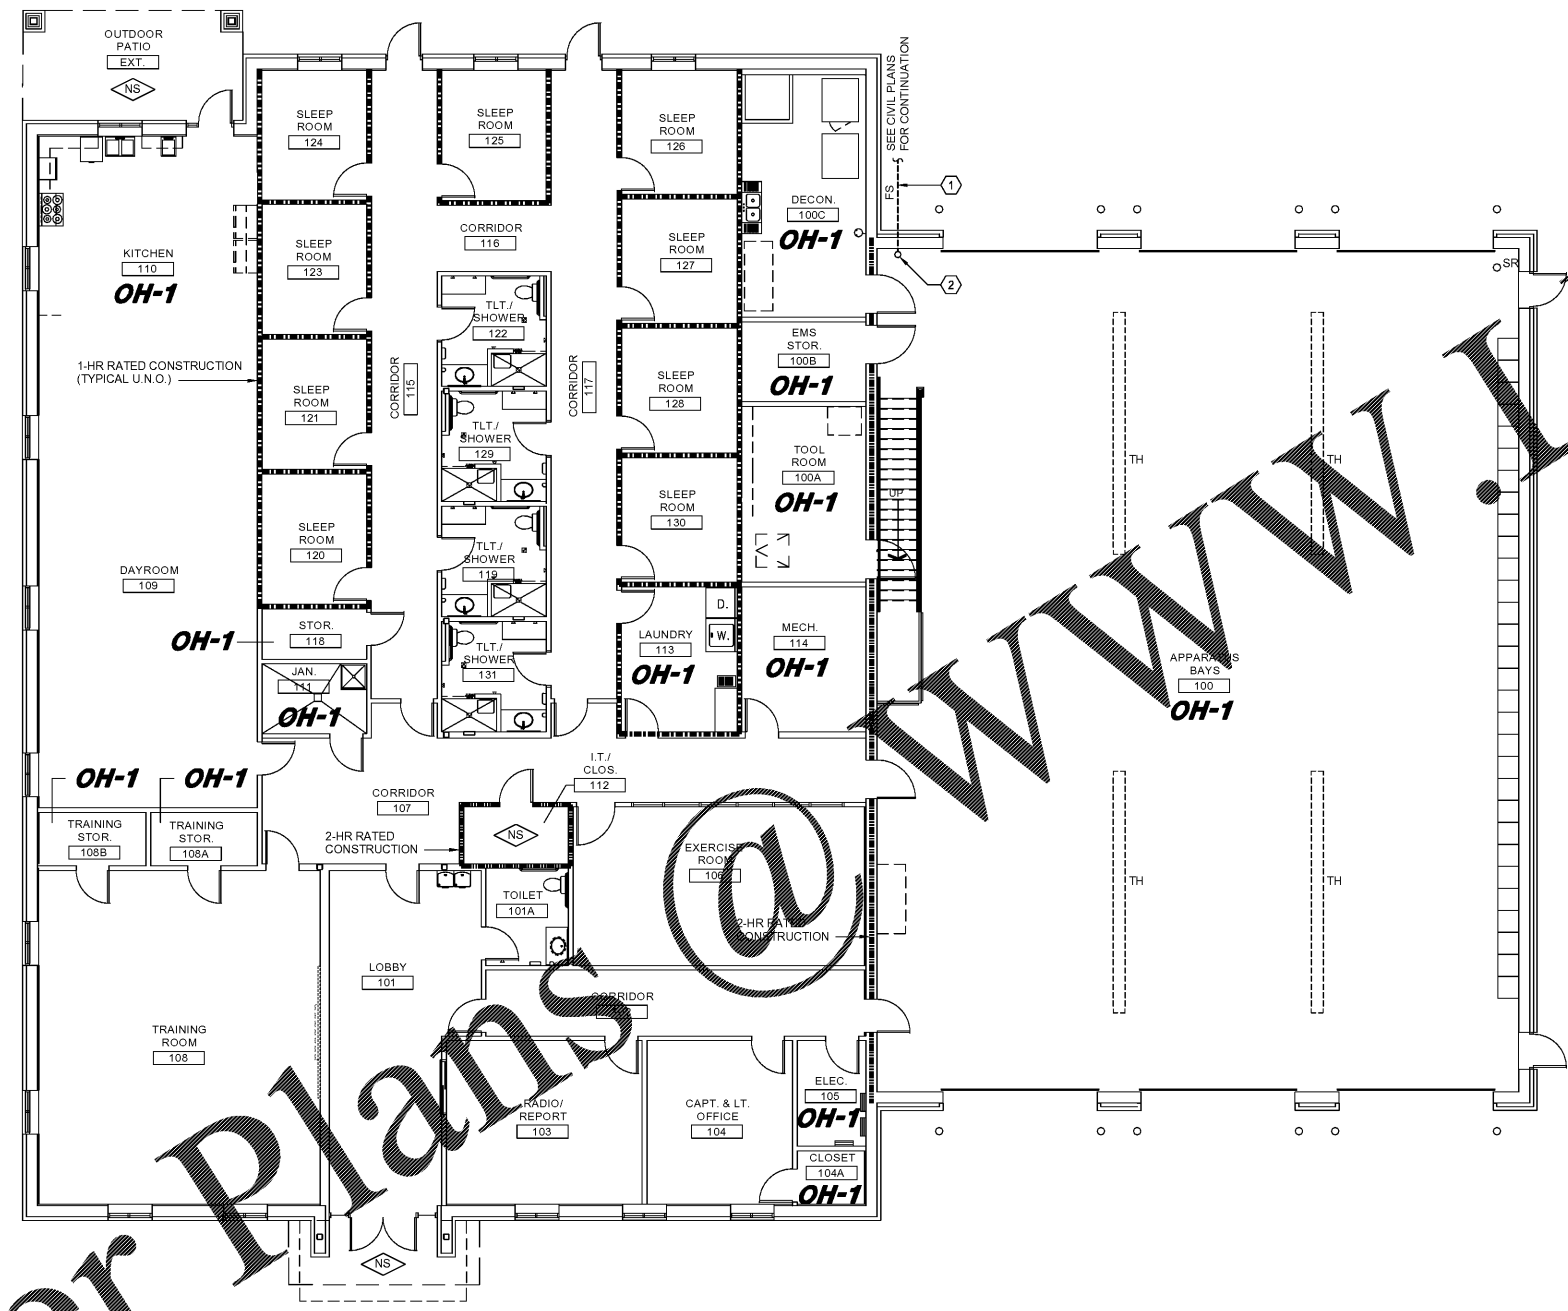

② MEZZANINE FIRE PROTECTION PLAN
SCALE: 1/8" = 1'-0"

NOTE:
ALL AREAS SHALL BE CONSIDERED LIGHT HAZARD UNLESS NOTED OTHERWISE.
① FIRE PROTECTION PLAN
SCALE: 1/8" = 1'-0"

CLIENT: AUGUSTA, GA
 535 TELFAIR STREET, AUGUSTA, GA 30901
 PROJECT NAME: **FIRE STATION #2**
 PROJECT LOCATION: 928 TELFAIR ST., AUGUSTA, GA 30901

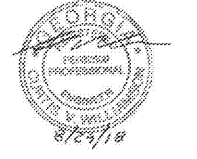


REV	DATE	BY	DESCRIPTION
0	08/29/18	CVW	ISSUED FOR PERMITTING

PROJECT NO. 3042.1604
 DRAWN BY: WBR
 CHECKED BY: CVW
 DATE: 10/18/17

FIRE PROTECTION PLANS

 SCALE: AS NOTED
 DRAWING NO. **F-101** REV. **0**



3042.1604-01-FIRE PROTECTION PLANS (REV. 10/18/17) (SHEET 1 OF 1)

This document is the property of Johnson, Lascobor & Associates, P.C. The unauthorized reproduction, copying or otherwise use of this document is strictly prohibited and any infringement thereupon may be subject to legal action.

Order Plans @

WWW.LDLine.com