


HVAC CONSTRUCTION NOTES:

- ① - 4"Ø TYPE B VENT UP THRU ROOF TO VENT CAP.
- ② - PROVIDE GREASE DUCT CLEANOUT(S) WITH A 12"x12" OPENING ON THE VERTICAL SIDE OF THE HORIZONTAL GREASE DUCT, PER IMC 2012.
- ③ - 16/16 EA DUCT UP TO KEF-1 ON ROOF.
- ④ - 12/12 OA DUCT UP TO KSF-1 ON ROOF.
- ⑤ - SEE 2/M-101 FOR CONTINUATION.
- ⑥ - SEE 1/M-101 FOR CONTINUATION.
- ⑦ - PROVIDE CONCENTRIC VENTING UP THRU ROOF PER MANUFACTURER'S RECOMMENDATION FOR NEW WATER HEATER VENTS. SEE PLUMBING DRAWINGS FOR MANUFACTURER AND MODEL NO.

1980
Architects • Engineers • Interior Architects
JOHNSON, LASCOBOR & ASSOCIATES, P.C.
1000 W. MARKET ST., SUITE 1000, AUGUSTA, GA 30901
TEL: (706) 724-5756 • TEL: (843) 619-4656
FAX: (706) 724-3935
WWW.THEJLAGROUP.COM


CLIENT: AUGUSTA, GA
PROJECT NAME: 535 TELFAIR STREET, AUGUSTA, GA 30901
PROJECT LOCATION: 928 TELFAIR ST., AUGUSTA, GA 30901

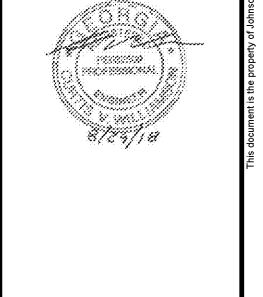


REV	DATE	BY	DESCRIPTION
0	08/29/18	CVW	ISSUED FOR PERMITTING

PROJECT NO. 3042.1604
DRAWN BY: MNB
CHECKED BY: CVW
DATE: 10/18/17
SHEET TITLE: HVAC PLAN

SCALE: AS NOTED
DRAWING NO. M-101
REV. 0

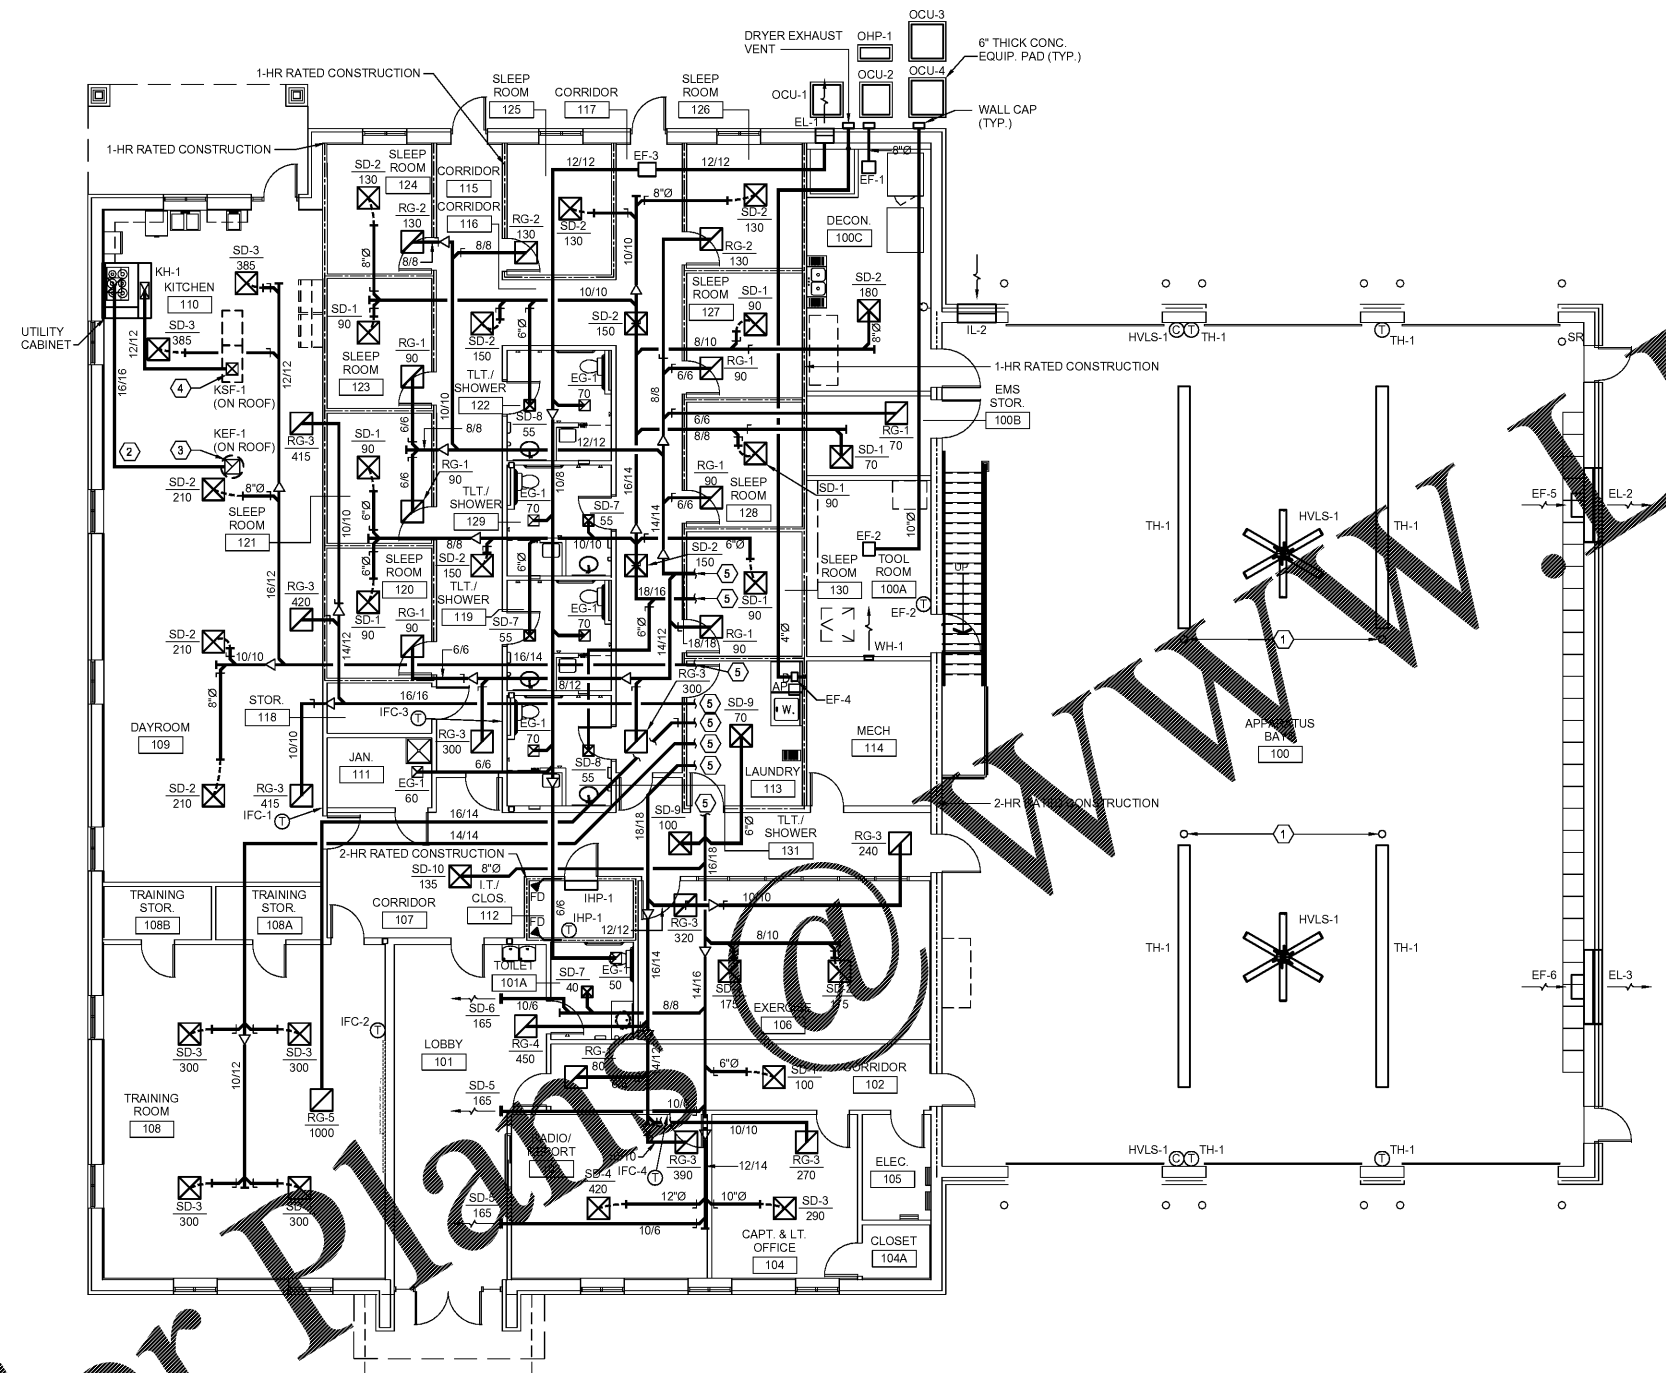

① HVAC PLAN
M-101
SCALE: 1/8" = 1'-0"

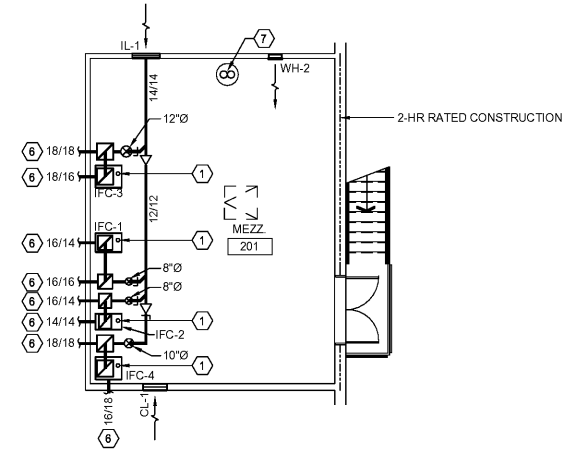

② MEZZANINE HVAC PLAN
M-101
SCALE: 1/8" = 1'-0"

FIRE DAMPER NOTE:
FIRE DAMPERS ARE NOT REQUIRED TO BE INSTALLED AT DUCTS THAT PENETRATE 1-HR RATED FIRE PARTITIONS, PER 2012 IMC, SECTION 607.5.3. EXCEPTION 4. DUCTS AT SUCH WALL PENETRATIONS SHALL COMPLY FULLY WITH REQUIREMENTS OF EXCEPTION 4.

