



Order Plans

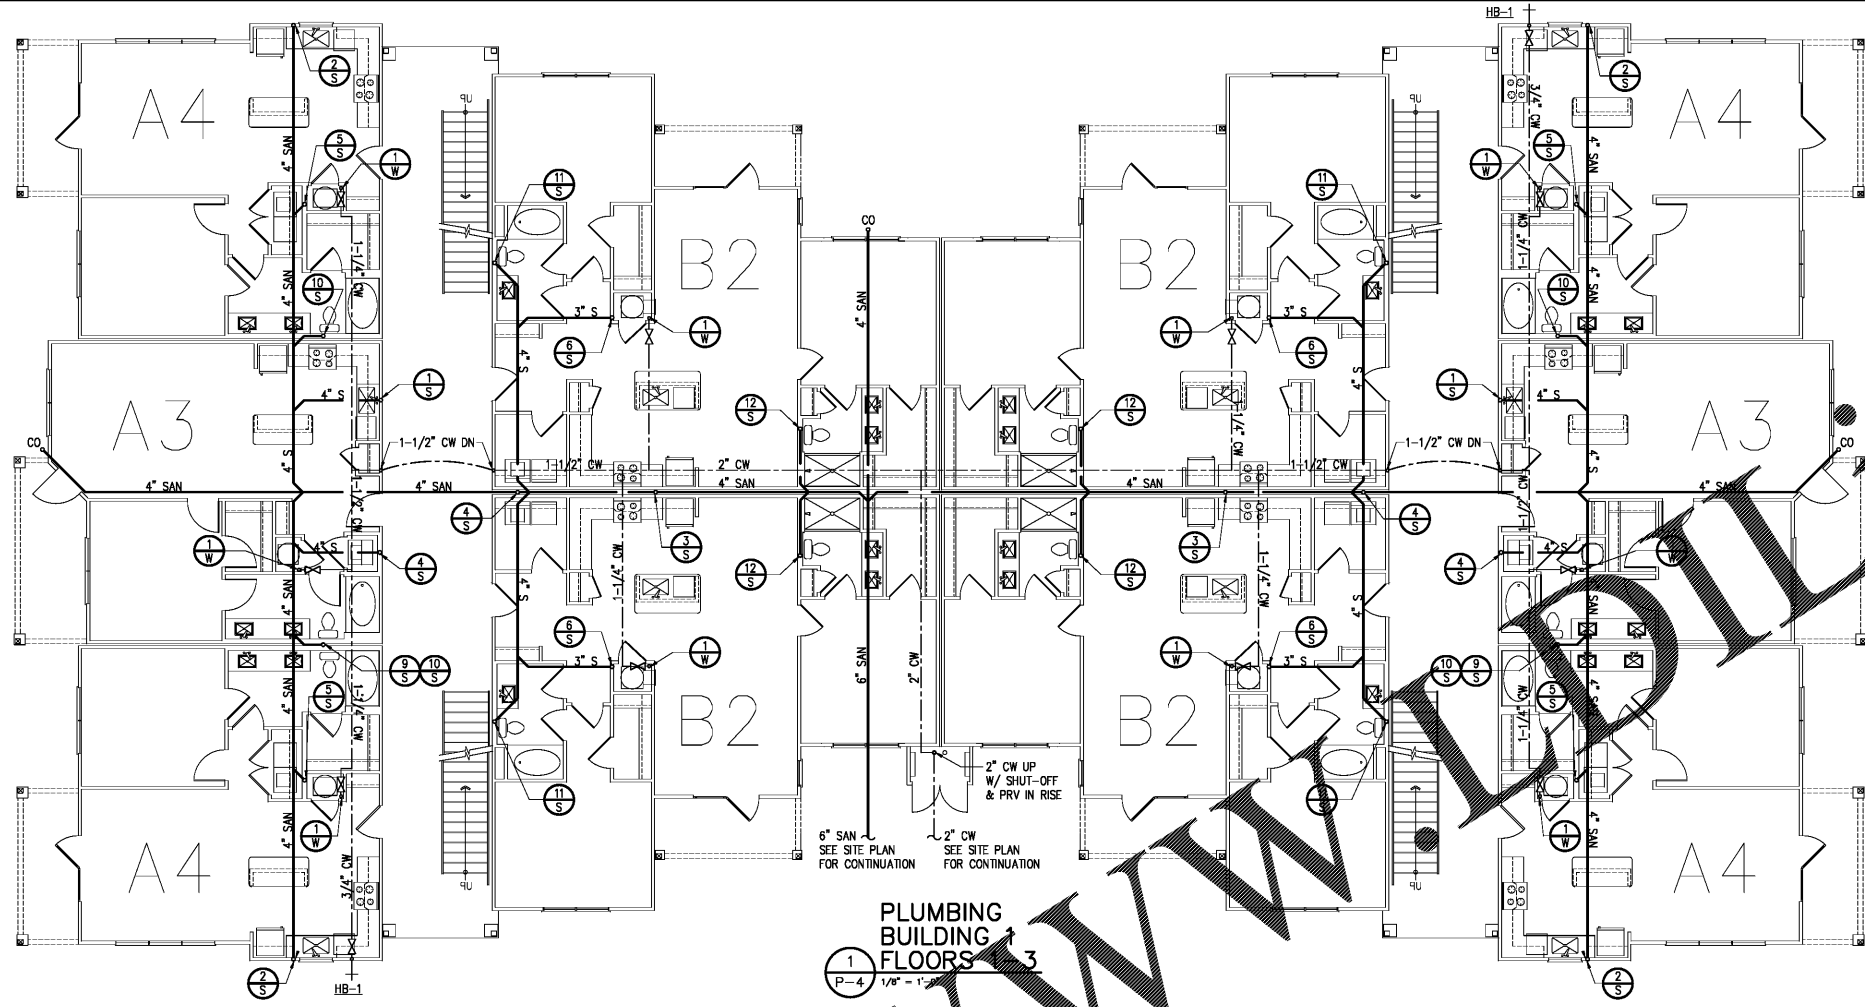

PLUMBING
BUILDING 1
FLOORS 1-3
P-4
1/8" = 1'-0"

PLUMBING
BLDG 2 & 9
FLOORS 1-3
P-4
1/8" = 1'-0"

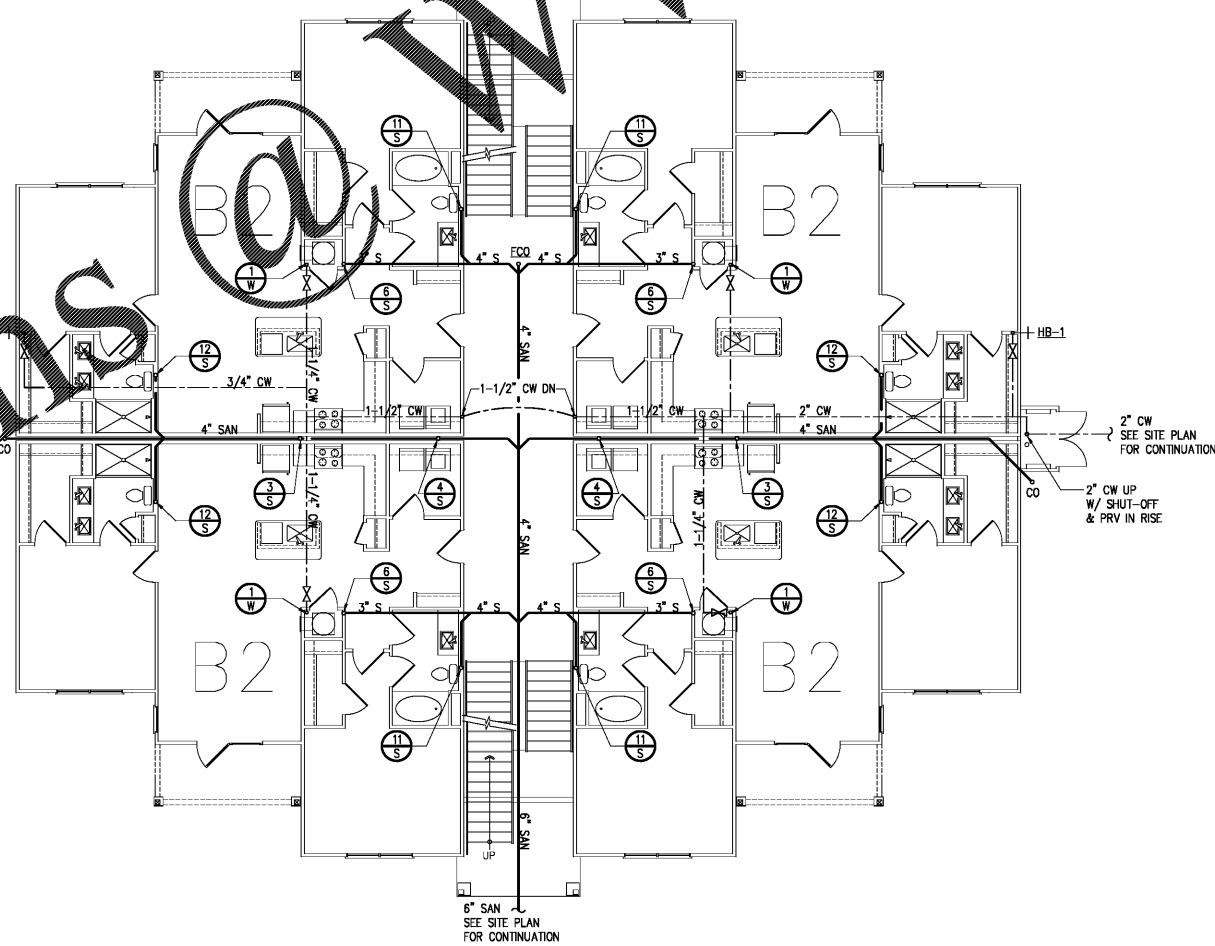

6" SAN
SEE SITE PLAN
FOR CONTINUATION



ENGLISH & ASSOCIATES
ARCHITECTS, INC.

3084 MERCER UNIVERSITY DRIVE, SUITE 100
ATLANTA, GEORGIA 30341

DENGLISH@ENGLISHASSOCIATESINC.COM

JOB PROGRESS:

ITEM	DATE

REVISIONS:

DATE NO.

This drawing, as an instrument of service, is and shall remain the property of the Architect. Of Record and shall not be published, reproduced or used in any way without the written permission of the Architect. Of Record. DO NOT scale the drawing. All questions to be submitted as a formal request for information to the Architect. Of Record.

ALEXANDRIA

AN APARTMENT COMMUNITY

FOR

BOBO FAMILY GROUP

HUNTSVILLE, ALABAMA

JOB NUMBER:

DRAWN BY: RK

CHECKED BY: RK

PLUMBING
BUILDING PLANS

SHEET NO.

P-4