


1 LEASING OFFICE - ELECTRICAL PLAN  
 E-13.1 SCALE: 1/8" = 1'-0"

- LEASING OFFICE PLAN NOTES:
- 1 VERIFY EXACT LOCATION WITH ARCHITECTURAL DRAWINGS.
  - 2 PROVIDE DUPLEX RECEPTACLE WITH TWO USB CHARGING OUTLETS.
  - 3 SWITCH SHALL CONTROL LIGHTS AND EXHAUST FAN.
  - 4 LOCATION OF TELEPHONE TERMINAL BOARD AND TV HEAD END.
  - 5 REFER TO MECHANICAL EQUIPMENT SCHEDULE FOR ELECTRICAL REQUIREMENTS.



2 LEASING OFFICE - LIGHTING PLAN  
 E-13.1 SCALE: 1/8" = 1'-0"

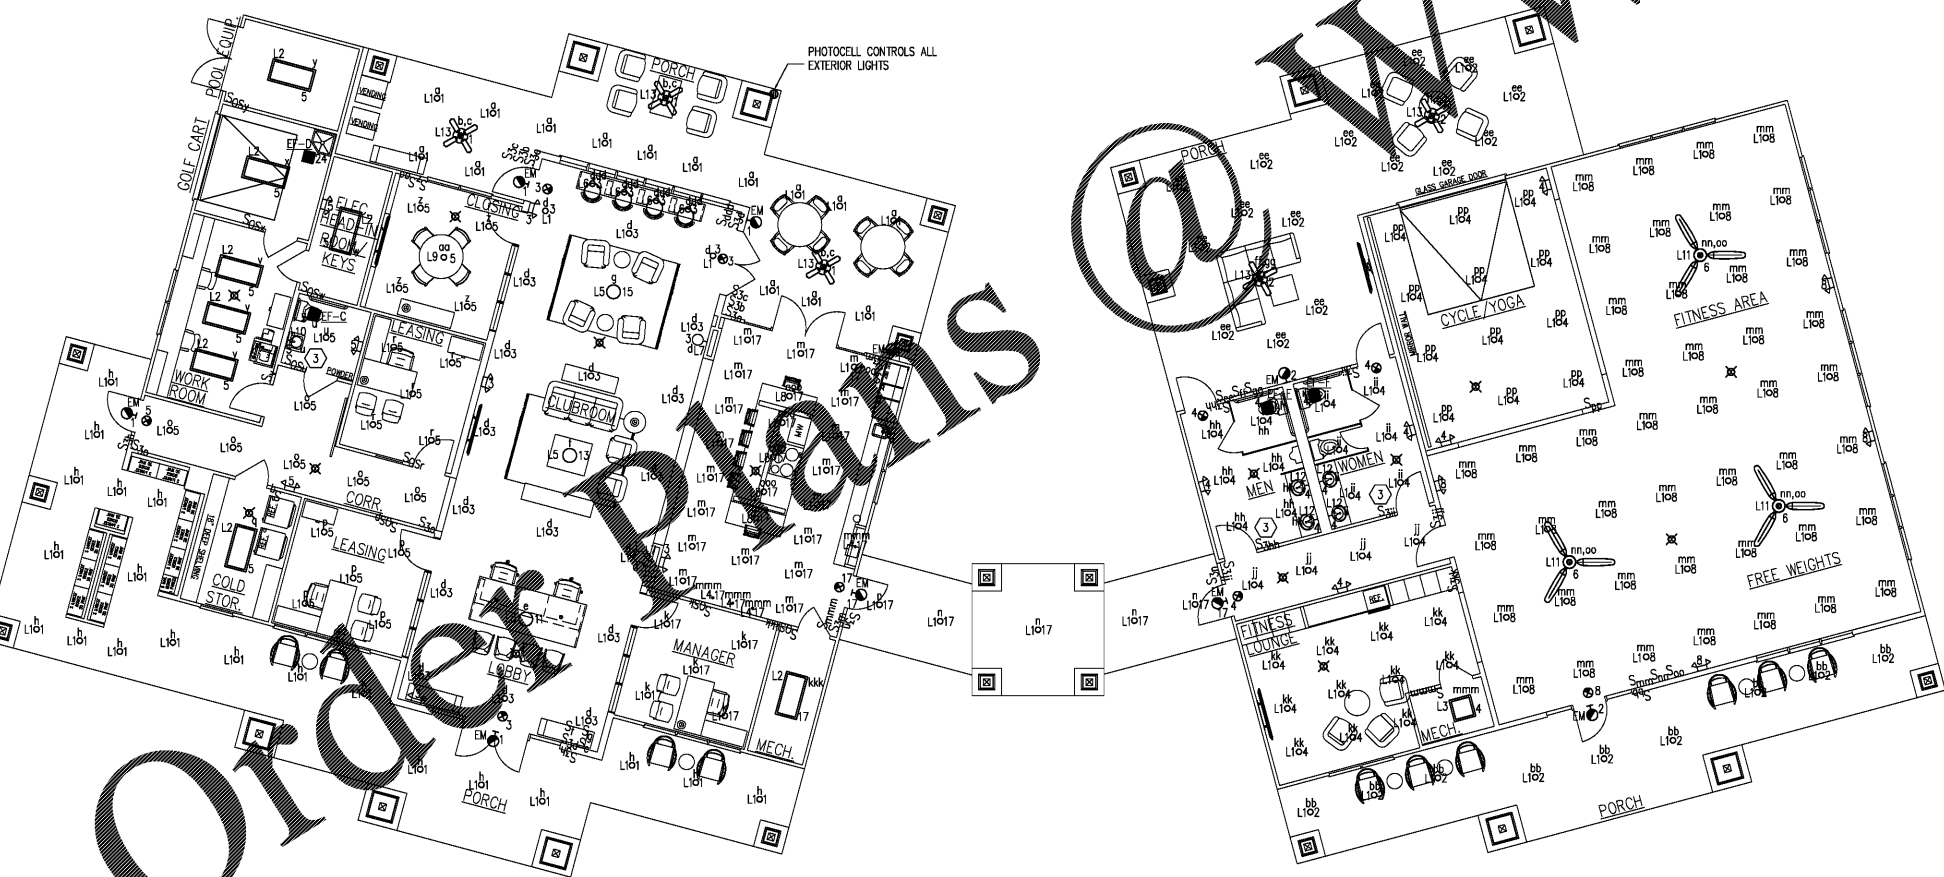

**ENGLISH & ASSOCIATES**  
 ARCHITECTS, INC.  
 3084 MERCER UNIVERSITY DRIVE, SUITE 100  
 ATLANTA, GEORGIA 30341  
 DENGGLISH@ENGLISHASSOCIATESINC.COM

JOB PROGRESS:

ITEM: DATE:

REVISIONS:

TAG: DATE:

This drawing, as an instrument of service, is and shall remain the property of the Architect Of Record and shall not be published, reproduced or used in any way without the written permission of the Architect Of Record. DO NOT scale this drawing. All questions to be submitted as a formal request for information to the Architect Of Record.

**ALEXANDRIA**  
 AN APARTMENT COMMUNITY  
 FOR  
 Bobo Family Group  
 HUNTSVILLE, ALABAMA

JOB NUMBER:

DRAWN BY:

CHECKED BY:

LEASING OFFICE  
 LIGHTING &  
 ELECTRICAL PLANS  
 SHEET NO.

E-13.1