



1 4 BAY GARAGE WITH STORAGE - ELECTRICAL PLAN  
 E-14.1 SCALE: 1/4" = 1'-0"

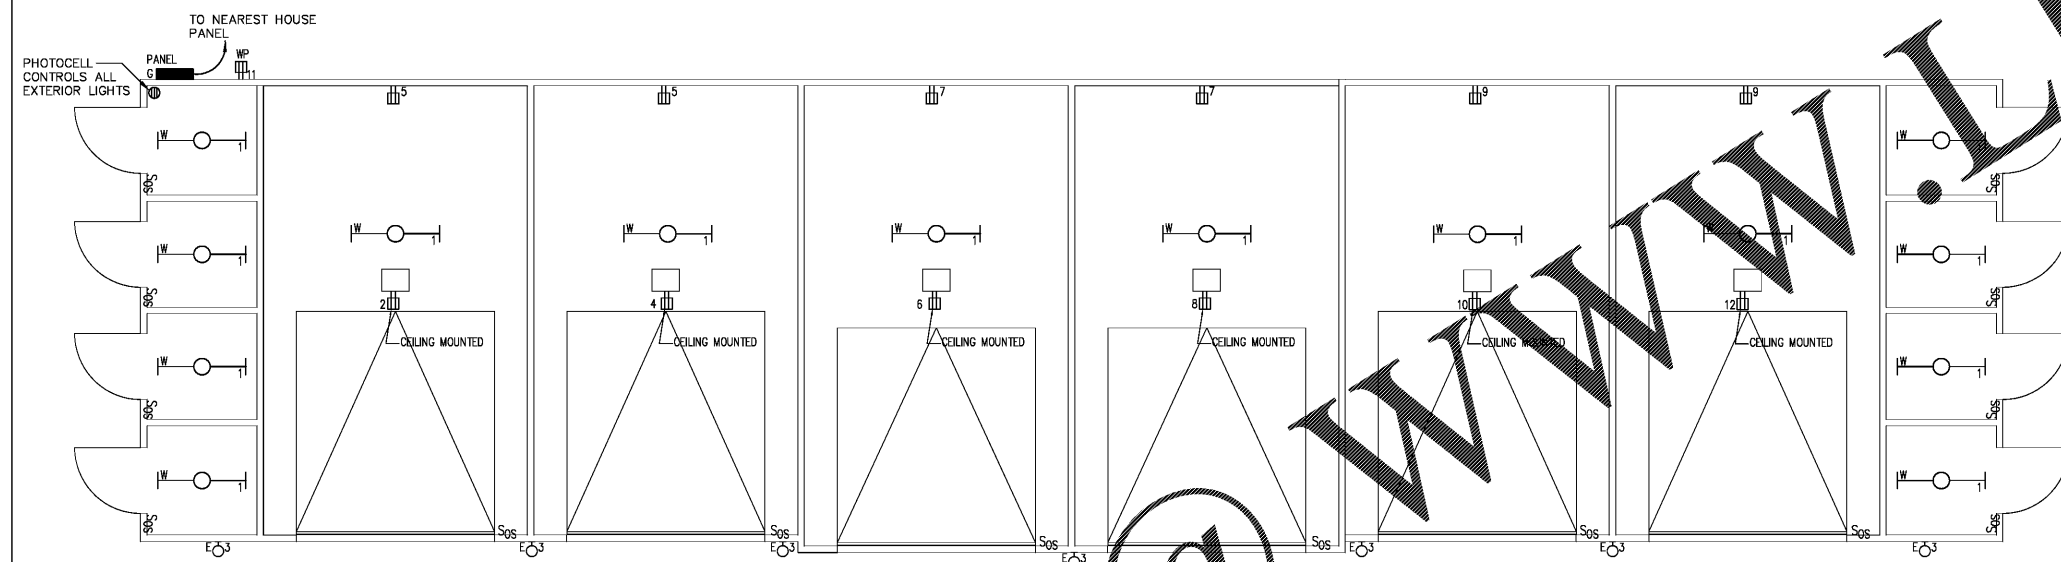

2 6 BAY GARAGE WITH STORAGE - ELECTRICAL PLAN  
 E-14.1 SCALE: 1/4" = 1'-0"

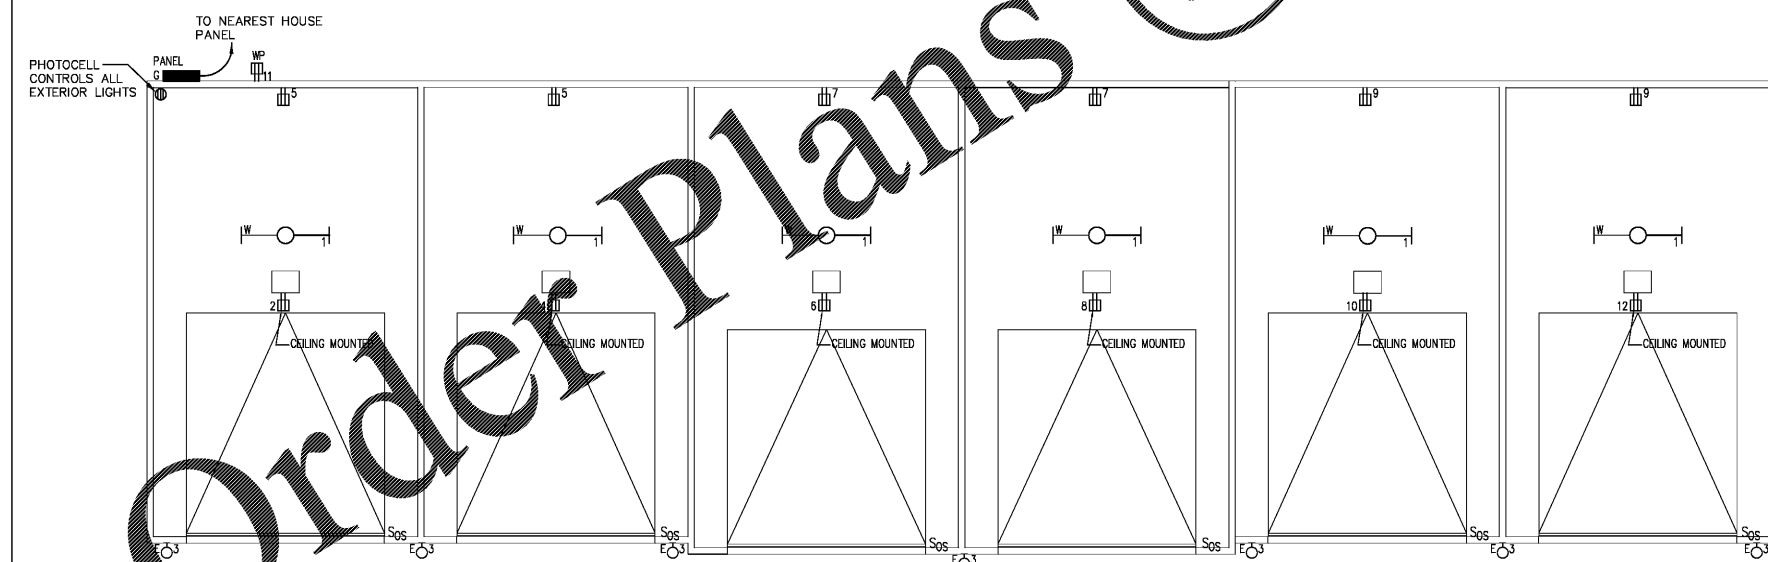

3 6 BAY GARAGE - ELECTRICAL PLAN  
 E-14.1 SCALE: 1/4" = 1'-0"



**ENGLISH & ASSOCIATES**  
 ARCHITECTS, INC.  
 3084 MERCER UNIVERSITY DRIVE, SUITE 100  
 ATLANTA, GEORGIA 30341  
 DENGGLISH@ENGLISHASSOCIATESINC.COM

JOB PROGRESS:  
 ITEM: DATE:

REVISIONS:  
 TAG: DATE:

This drawing, as an instrument of service, is and shall remain the property of the Architect Of Record and shall not be published, reproduced or used in any way without the written permission of the Architect Of Record. DO NOT scale this drawing. All questions to be submitted as a formal request for information to the Architect Of Record.

**ALEXANDRIA**  
 AN APARTMENT COMMUNITY  
 FOR  
 Bobo Family Group  
 HUNTSVILLE, ALABAMA

JOB NUMBER:  
 DRAWN BY:  
 CHECKED BY:  
 GARAGE ELECTRICAL PLANS  
 SHEET NO.

E-14.1

WWW.LDILine.com

Order Plans @