


MAINTENANCE BUILDING NOTES:
 ① REFER TO MECHANICAL EQUIPMENT SCHEDULE FOR ELECTRICAL REQUIREMENTS.

① MAINTENANCE BUILDING ELECTRICAL PLAN
 E-14.2 SCALE: 1/4" = 1'-0"



② TRASH COMPACTOR ELECTRICAL PLAN
 E-14.2 SCALE: 1/4" = 1'-0"

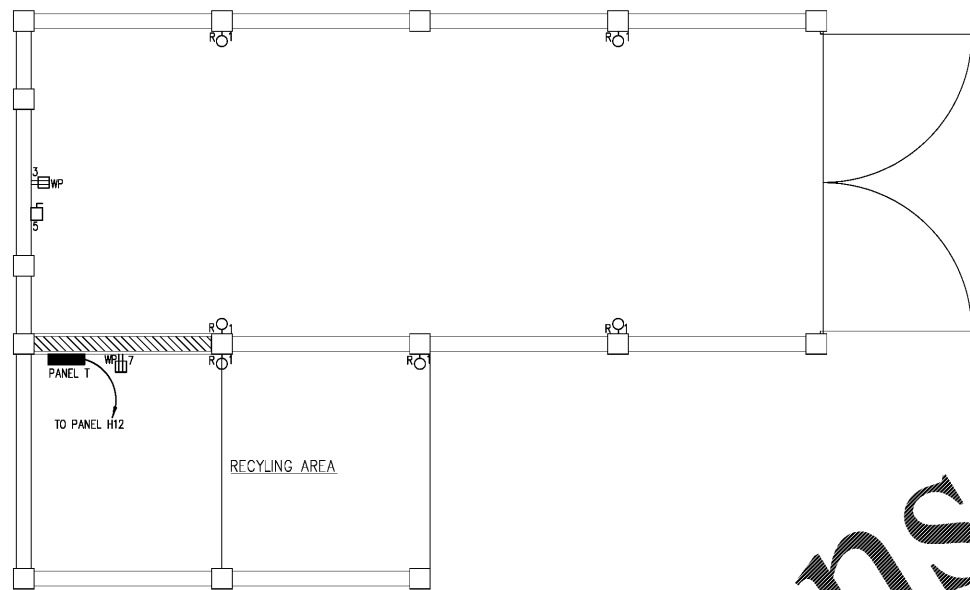

ENGLISH & ASSOCIATES
 ARCHITECTS, INC.
 3084 MERCER UNIVERSITY DRIVE, SUITE 100
 ATLANTA, GEORGIA 30341
 DENGGLISH@ENGLISHASSOCIATESINC.COM

JOB PROGRESS:

ITEM: DATE:

REVISIONS:

TAG: DATE:

This drawing, as an instrument of service, is and shall remain the property of the Architect Of Record and shall not be published, reproduced or used in any way without the written permission of the Architect Of Record. DO NOT scale this drawing. All questions to be submitted as a formal request for information to the Architect Of Record.

ALEXANDRIA
 AN APARTMENT COMMUNITY
 FOR
 Bobo Family Group
 HUNTSVILLE, ALABAMA

JOB NUMBER:

DRAWN BY:

CHECKED BY:

MAINTENANCE &
 TRASH COMPACTOR
 ELECTRICAL PLANS
 SHEET NO.

E-14.2

Order Plans @ www.LDILine.com