


1 BUILDINGS 2 & 9 GROUND LEVEL - ELECTRICAL PLANS
 E-5.1 SCALE: 1/8" = 1'-0"

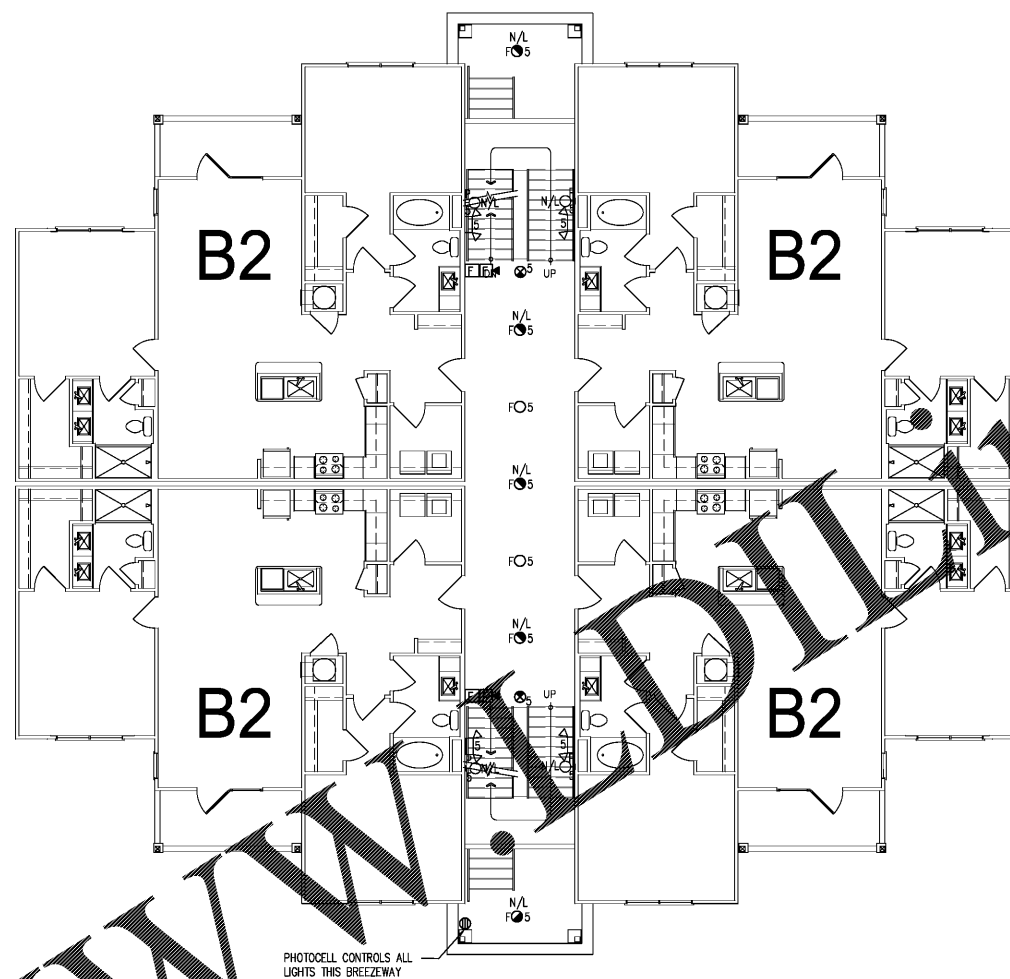

2 BUILDINGS 2 & 9 SECOND LEVEL - ELECTRICAL PLANS
 E-5.1 SCALE: 1/8" = 1'-0"

Order Plans @

WWW.DIline.com



ENGLISH & ASSOCIATES ARCHITECTS, INC.
 3084 MERCER UNIVERSITY DRIVE, SUITE 100
 ATLANTA, GEORGIA 30341
 DENGGLISH@ENGLISHASSOCIATESINC.COM

JOB PROGRESS:
 ITEM: DATE:

REVISIONS:
 TAG: DATE:

This drawing, as an instrument of service, is and shall remain the property of the Architect. It shall not be reproduced or used in any way without the written permission of the Architect. All questions to be submitted as a formal request for information to the Architect Of Record.

ALEXANDRIA
 AN APARTMENT COMMUNITY
 FOR
 Bobo Family Group
 HUNTSVILLE, ALABAMA

JOB NUMBER:
 DRAWN BY:
 CHECKED BY:
 BUILDINGS 2 & 9
 GROUND & SECOND LEVEL
 ELECTRICAL PLANS
 SHEET NO.

E-5.1

- BUILDING PLAN NOTES:
- 1 BUILDING SERVICE LOCATION. SEE RISER DIAGRAM. PROVIDE PERMANENT PNEUMATIC LABELS AT EACH METER INDICATING UNIT NUMBER. COORDINATE REQUIRED HEIGHT OF LETTERS WITH UTILITY AND FIRE DEPARTMENT.
 - 2 HOUSE PANEL LOCATION.
 - 3 CONDENSER UNIT LOCATIONS. REFER TO PANEL SCHEDULES AND MECHANICAL EQUIPMENT SCHEDULE FOR ELECTRICAL REQUIREMENTS. PROVIDE A DISCONNECT ADJACENT TO EACH UNIT WITH AT LEAST 3'-0" OF CLEARANCE IN FRONT.
 - 4 PROVIDE FIRE ALARM CONNECTION TO TAMPER AND FLOW SWITCHES. COORDINATE QUANTITY AND LOCATION WITH FIRE SPRINKLER CONTRACTOR.
 - 5 COORDINATE FACP LOCATION WITH FIRE MARSHAL. THE FIRE ALARM SYSTEM SHALL BE DESIGNED BY THE FIRE ALARM CONTRACTOR AND THE DRAWINGS SHALL BE SEALED BY A PROFESSIONAL ENGINEER. ALL FIRE ALARM SYSTEMS SHALL REPORT TO THE MAIN SYSTEM IN THE LEASING OFFICE VIA WIRELESS CONNECTION. THERE SHALL BE NO FIRE ALARM CABLING INSTALLED UNDERGROUND. PROVIDE SURGE AND LIGHTNING PROTECTION ON EVERY FACP.
 - 6 PROVIDE (1) 2" CONDUIT FOR TELEPHONE AND (1) 2" CONDUIT FOR CATV TO UTILITY LOCATION. PROVIDE PULL STRING IN EACH CONDUIT. COORDINATE LOCATIONS OF CONDUIT WITH SERVICE PROVIDERS.