


Order Plans @

ELECTRICAL NOTES:
 ELECTRICAL OUTLET, JUNCTION BOX, AND LIGHTING MUST BE REFERRED TO AND CONFIRMED WITH ELECTRICAL ENGINEER'S DRAWINGS AS WELL AS STATE REQUIREMENTS. LOCATIONS AS SHOWN ARE DESIRABLE IN ACCORDANCE WITH DESIGN. REFER TO ELECTRICAL ENGINEER'S DRAWING FOR ELECTRICAL INFORMATION.

- ELECTRICAL LEGEND:**
- ▶ PHONE / DATA
 - ▽ DATA
 - ⊕ DUPLEX OUTLET
 - ⊕ GF GROUND FAULT INTERRUPT OUTLET
 - ⊕ CABLE OUTLET
 - POWER SOURCE LOCATION
 - ⊕ JUNCTION BOX FOR WALL SCONCE
 - ⊕ FLOOR ELECTRICAL OUTLET
 - ⊕ FLOOR DATA OUTLET

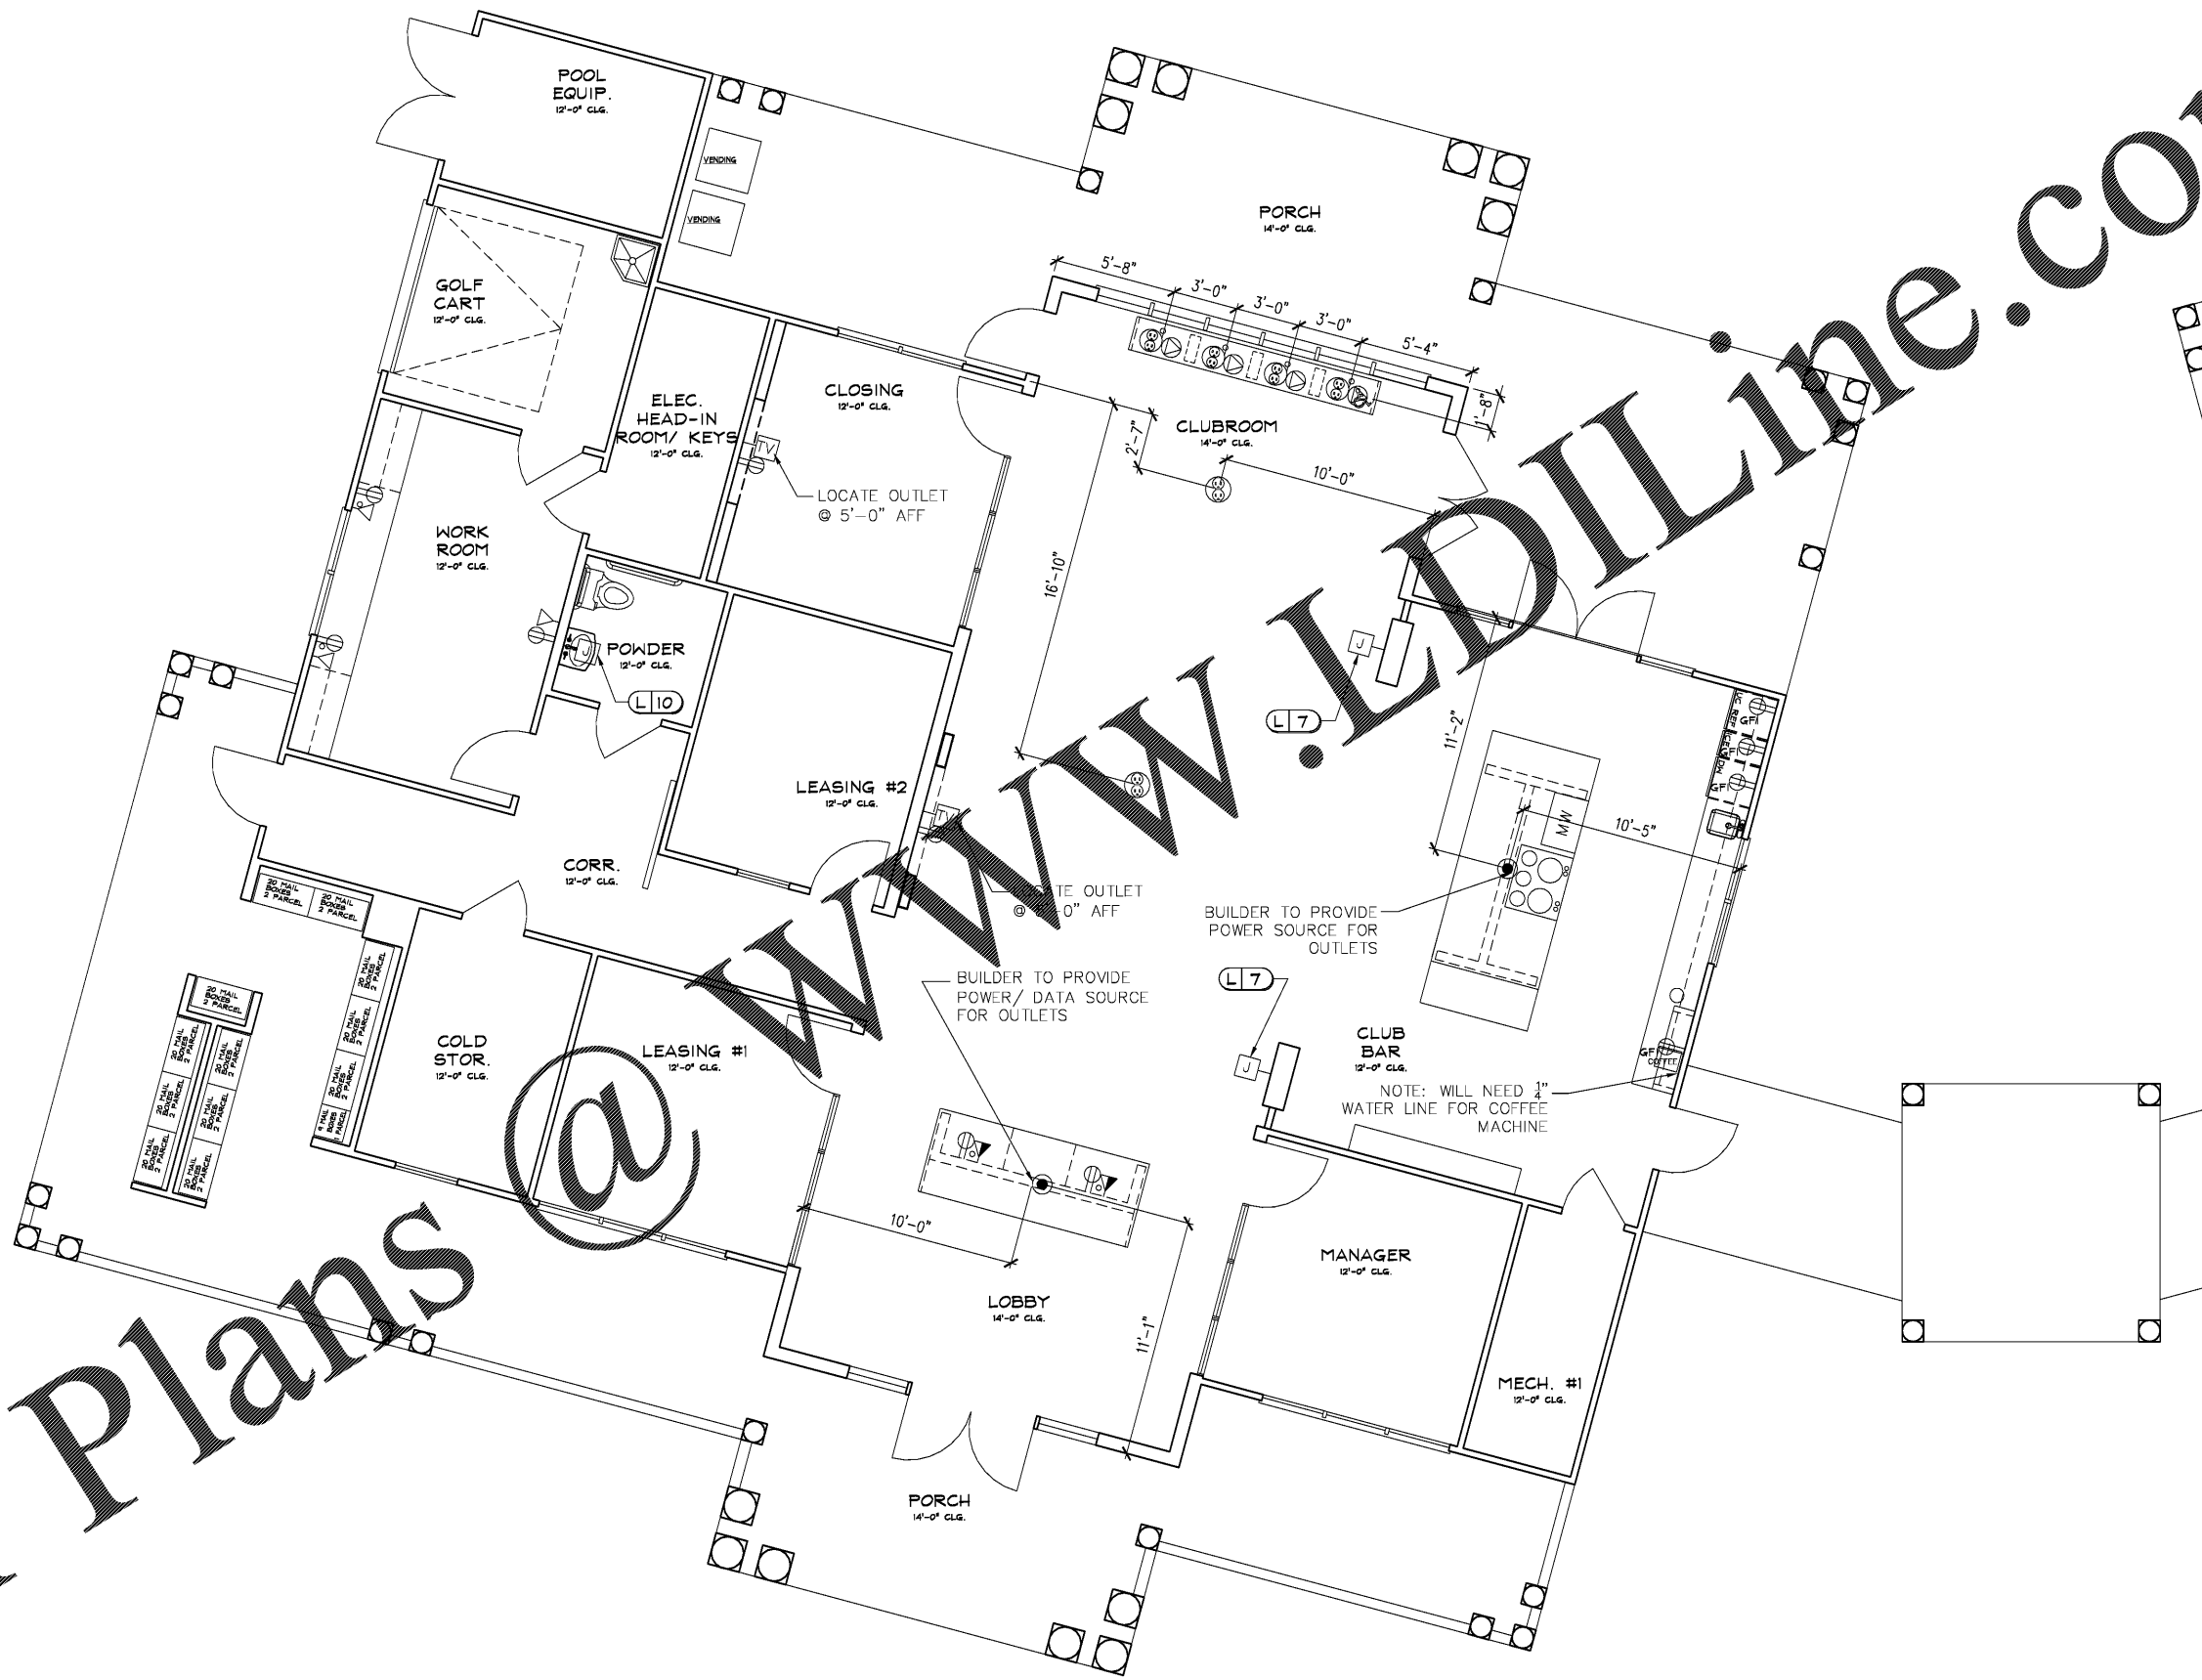

1 ELECTRICAL ADDITIONS PLAN "A"
 10.300A SCALE : 1/4" = 1'-0"

DEI
 DESIGN ENVIRONMENTS INC.
 1000 EAST WILSON AVENUE, SUITE 200
 HUNTSVILLE, AL 35894
 Phone: 770-428-3000
 Fax: 770-428-3001
 E-Mail: info@designenvironments.com

This Drawing is the property of Design Environments Inc. It is to be used only for the project and site identified on the drawing. It is not to be reproduced or used without the written permission of Design Environments Inc.

LEASING/AMENITY @
 ALEXANDRIA
 HUNTSVILLE, AL
 BOBO FAMILY GROUP

REV.	DATE	REVISIONS

RELEASED FOR CONSTRUCTION
 BEGIN DATE: 10.30.18
 RELEASE DATE: 12.28.18
 DESIGNER: NSQ
 CAD DESIGNER: WP
 REVIEWED BY: NSQ, WP, MS

JOB #: 18270
 TITLE: ELECTRICAL ADDITIONS PLAN "A"
 SHEET: ID.300A