

THESE DOCUMENTS, AS INSTRUMENTS OF SERVICE, REMAIN THE PROPERTY OF THE ARCHITECT AND NO PART THEREOF MAY BE USED OR REPRODUCED IN ANY FORM WITHOUT WRITTEN PERMISSION

DATE	
REVISIONS	
NO.	

CONSTRUCTION DOCUMENTS

WING A REFLECTED CEILING PLAN

SCALE: 1/8" = 1'-0"


SHEET

**A3.01**

6 OF 32

FILE: 18.08

DATE: 12/14/18

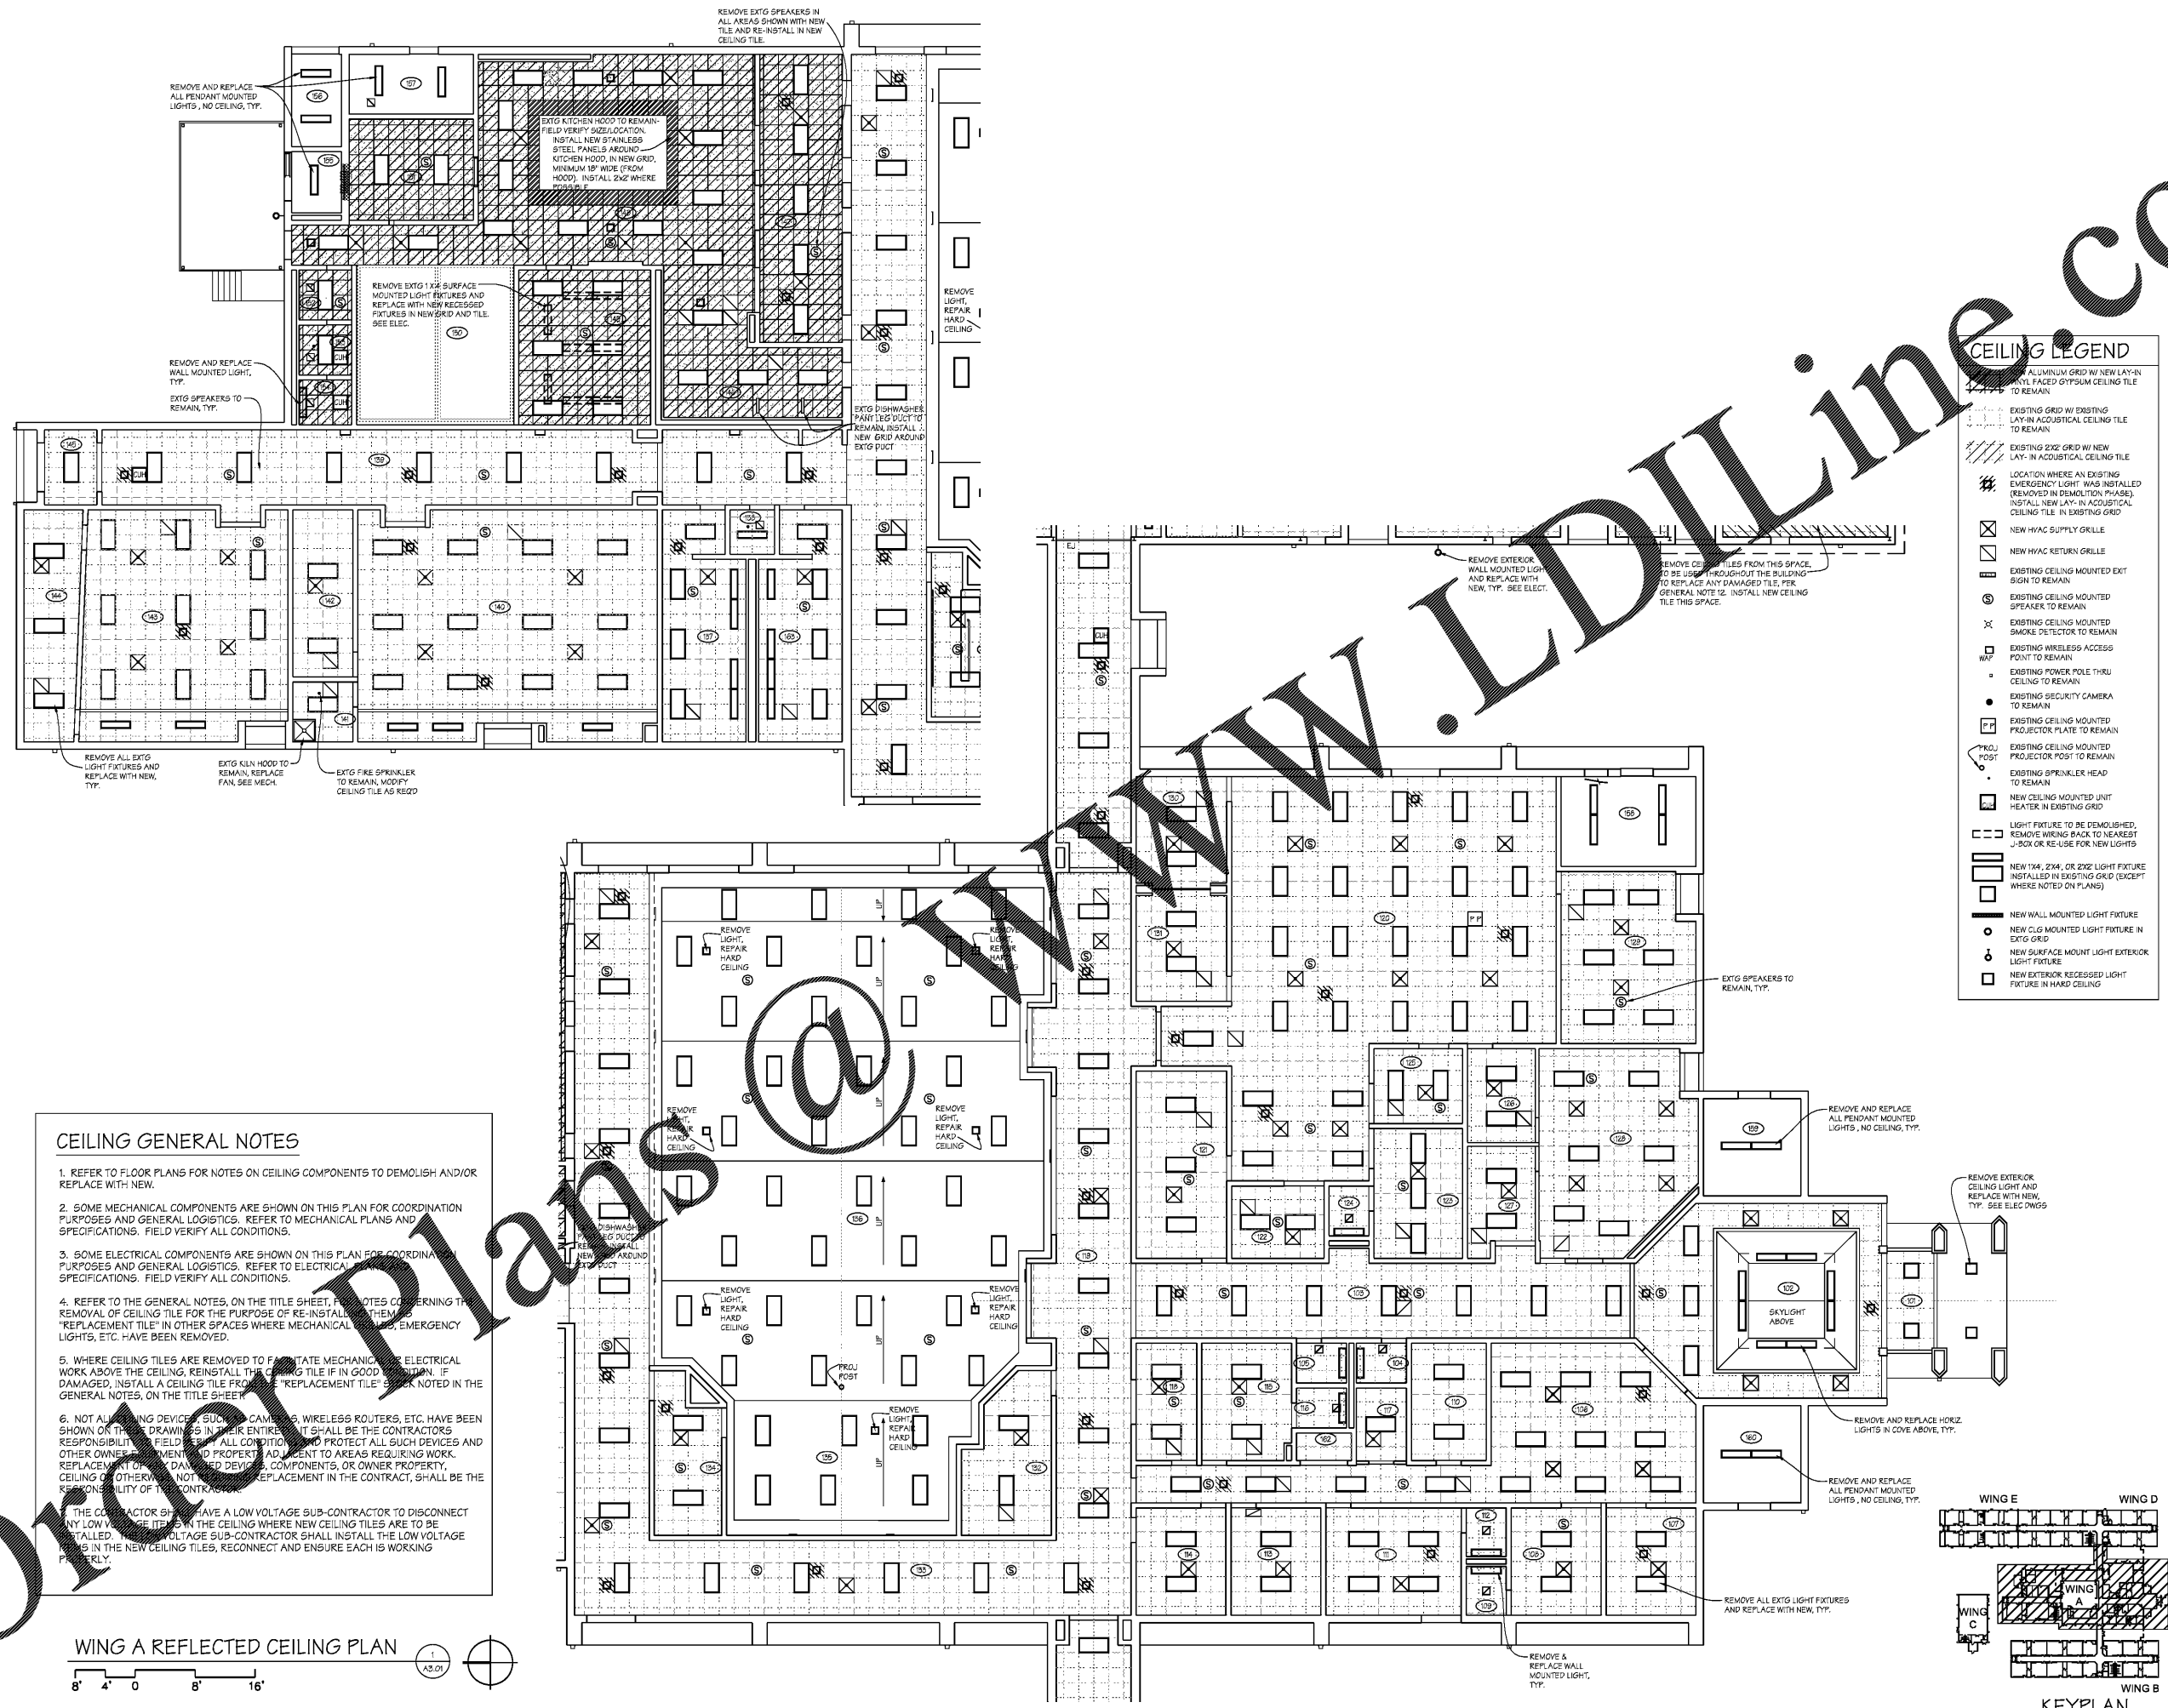

**CEILING GENERAL NOTES**

- REFER TO FLOOR PLANS FOR NOTES ON CEILING COMPONENTS TO DEMOLISH AND/OR REPLACE WITH NEW.
- SOME MECHANICAL COMPONENTS ARE SHOWN ON THIS PLAN FOR COORDINATION PURPOSES AND GENERAL LOGISTICS. REFER TO MECHANICAL PLANS AND SPECIFICATIONS. FIELD VERIFY ALL CONDITIONS.
- SOME ELECTRICAL COMPONENTS ARE SHOWN ON THIS PLAN FOR COORDINATION PURPOSES AND GENERAL LOGISTICS. REFER TO ELECTRICAL PLANS AND SPECIFICATIONS. FIELD VERIFY ALL CONDITIONS.
- REFER TO THE GENERAL NOTES, ON THE TITLE SHEET, FOR NOTES CONCERNING THE REMOVAL OF CEILING TILE FOR THE PURPOSE OF RE-INSTALLING THEM AS "REPLACEMENT TILE" IN OTHER SPACES WHERE MECHANICAL, ELECTRICAL, EMERGENCY LIGHTS, ETC. HAVE BEEN REMOVED.
- WHERE CEILING TILES ARE REMOVED TO FACILITATE MECHANICAL OR ELECTRICAL WORK ABOVE THE CEILING, REINSTALL THE CEILING TILE IF IN GOOD CONDITION. IF DAMAGED, INSTALL A CEILING TILE FROM THE "REPLACEMENT TILE" STOCK NOTED IN THE GENERAL NOTES, ON THE TITLE SHEET.
- NOT ALL CEILING DEVICES, SUCH AS CAMERAS, WIRELESS ROUTERS, ETC. HAVE BEEN SHOWN ON THESE DRAWINGS IN THEIR ENTIRETY. IT SHALL BE THE CONTRACTOR'S RESPONSIBILITY TO FIELD VERIFY ALL CONDITIONS AND PROTECT ALL SUCH DEVICES AND OTHER OWNERS' AND PROPERTY ADJACENT TO AREAS REQUIRING WORK. REPLACEMENT OF ANY DAMAGED DEVICES, COMPONENTS, OR OWNER PROPERTY, CEILING OR OTHERWISE, NOT NOTED IN THE CONTRACT, SHALL BE THE RESPONSIBILITY OF THE CONTRACTOR.
- THE CONTRACTOR SHALL HAVE A LOW VOLTAGE SUB-CONTRACTOR TO DISCONNECT ANY LOW VOLTAGE DEVICES IN THE CEILING WHERE NEW CEILING TILES ARE TO BE INSTALLED. THE LOW VOLTAGE SUB-CONTRACTOR SHALL INSTALL THE LOW VOLTAGE DEVICES IN THE NEW CEILING TILES, RECONNECT AND ENSURE EACH IS WORKING PROPERLY.

**WING A REFLECTED CEILING PLAN**

1  
AS OF