


2/M1.02


KEY PLAN

1/M1.02

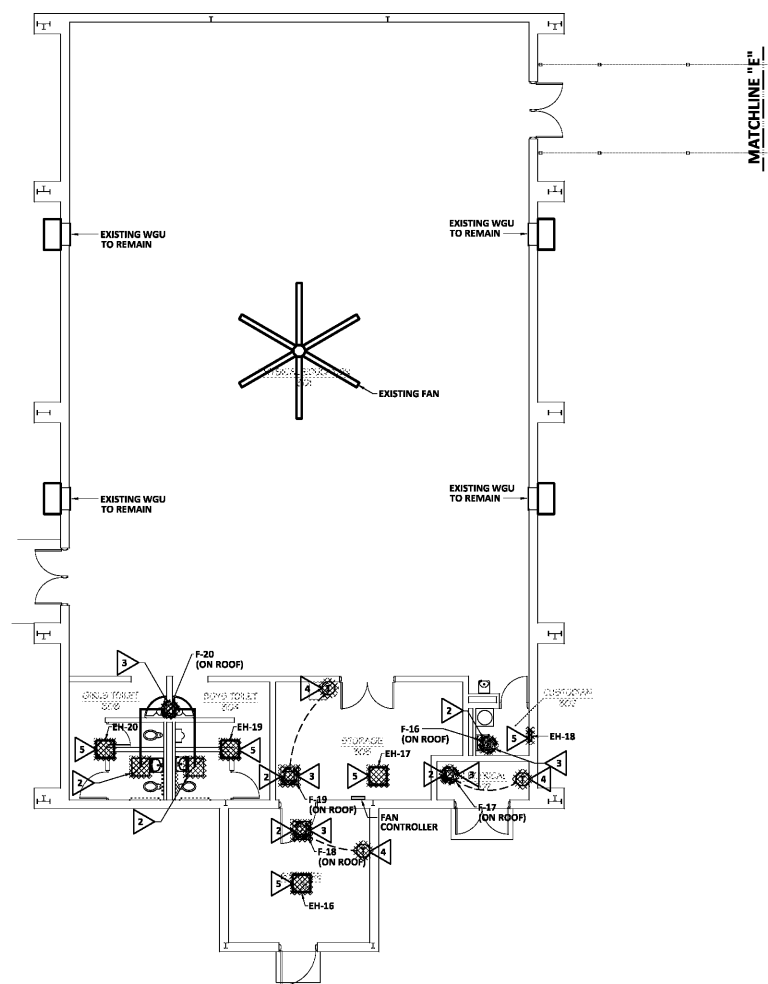


2 HVAC DEMOLITION PLAN - WING "C"
SCALE: 1/8" = 1'-0"


- DEMOLITION NOTES (THIS SHEET ONLY):**
- ▽ DEMOLISH EXISTING WALL-MOUNT GAS UNIT AND ASSOCIATED RETURN GRILLE, WIRING, CONTROLS AND ACCESSORIES. REMOVE EXISTING ABOVE-GROUND GAS PIPING.
 - ▽ DEMOLISH EXISTING EXHAUST GRILLE.
 - ▽ DEMOLISH EXISTING EXHAUST FAN AND ASSOCIATED ACCESSORIES. EXHAUST RISER TO REMAIN.
 - ▽ DEMOLISH EXISTING THERMOSTAT.
 - ▽ DEMOLISH EXISTING ELECTRIC HEATER AND ASSOCIATED ACCESSORIES.
 - ▽ DEMOLISH EXISTING THRU-WALL UNIT AND ASSOCIATED ACCESSORIES.
 - ▽ DEMOLISH EXISTING MINI SPLIT SYSTEM AND ASSOCIATED ACCESSORIES.
 - ▽ DEMOLISH HVAC TIME CLOCK AND ASSOCIATED WIRING. REPAIR WALL TO MATCH EXISTING.

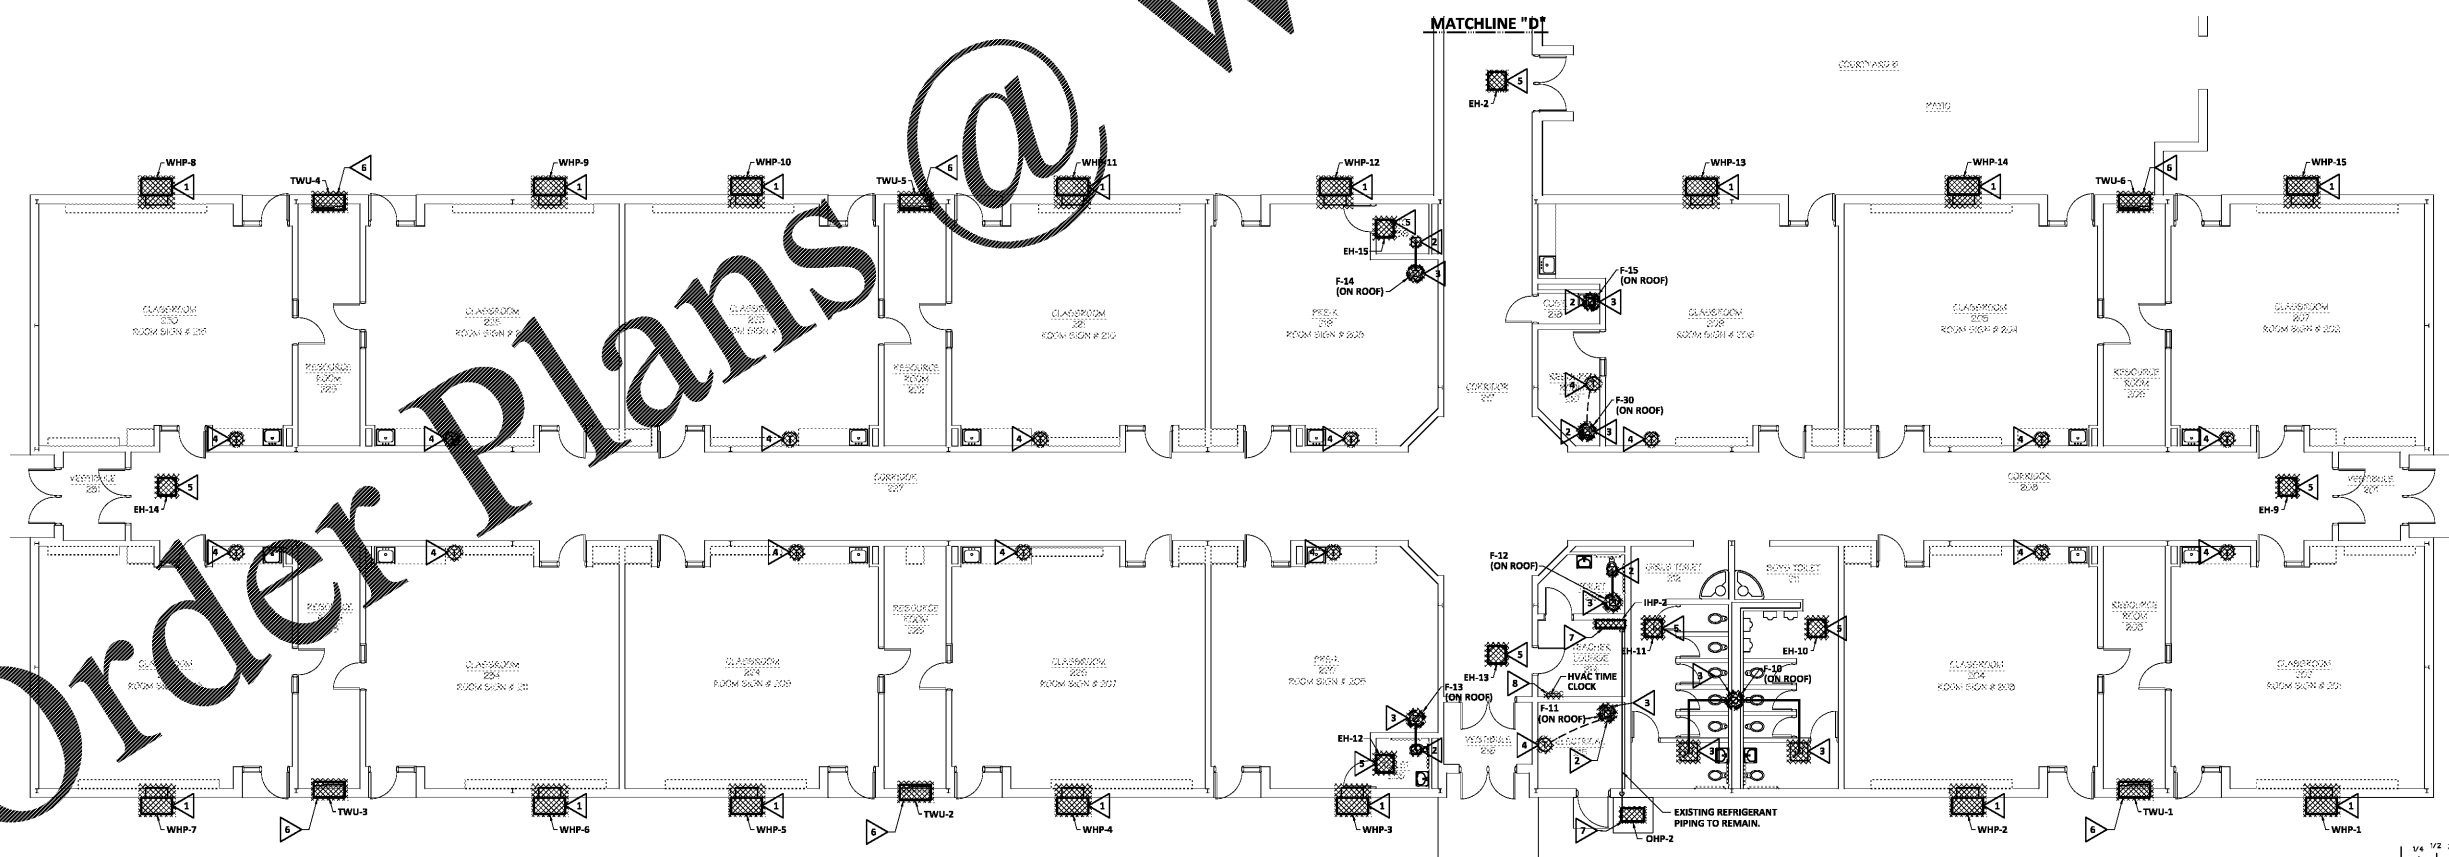

 1 HVAC DEMOLITION PLAN - WING "B"
SCALE: 1/8" = 1'-0"



PLOT DATE: 12/14/18
FILENAME: 18106M1
PLOT SCALE: 1 = 96

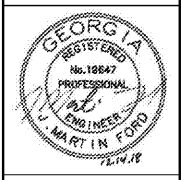

FRUIT, FORD & ASSOCIATES, INC.
CONSULTING ENGINEERS
100 IRVING STREET, SUITE 301
ALBUQUERQUE, GEORGIA 30611
404.288.7400 • FAX 404.288.7401

THESE DOCUMENTS, AS SERVICE, REMAIN THE PROPERTY OF THE ARCHITECT AND NO PART THEREOF MAY BE USED OR REPRODUCED IN ANY FORM WITHOUT WRITTEN PERMISSION

NO.	REVISIONS	DATE

CONSTRUCTION DOCUMENTS

HVAC PLAN

SCALE: 1/8" = 1'-0"

SHEET
M1.02

11 OF 32
FILE: 18.04
DATE: 12/14/18

Order Plans @

WWW.LDILine.com