 


2 M1.03
 HVAC DEMOLITION PLAN - WING "E"
 SCALE: 1/8" = 1'-0"


DEMOLITION NOTES (THIS SHEET ONLY):

- ▷ DEMOLISH EXISTING SUPPLY DIFFUSER.
- ▷ DEMOLISH EXISTING WALL-MOUNT GAS UNIT AND ASSOCIATED AIR DEVICES, WIRING, CONTROLS AND ACCESSORIES. REMOVE EXISTING ABOVE-GROUND GAS PIPING.
- ▷ DEMOLISH EXISTING EXHAUST GRILLE.
- ▷ DEMOLISH EXISTING THERMOSTAT.
- ▷ DEMOLISH EXISTING FAN AND ASSOCIATED ACCESSORIES. DUCT RISER TO REMAIN.
- ▷ DEMOLISH EXISTING ELECTRIC HEATER AND ASSOCIATED ACCESSORIES.
- ▷ DEMOLISH EXISTING THRU-WALL UNIT AND ASSOCIATED LOUVER AND ACCESSORIES.
- ▷ DEMOLISH EXISTING GRILLE.
- ▷ DEMOLISH EXISTING REFRIG. UNIT SYSTEM AND ASSOCIATED ACCESSORIES.
- ▷ DEMOLISH EXISTING HVAC TIME CLOCK AND ASSOCIATED WIRING. REPAIR WALL TO MATCH EXISTING.

2/M1.03 1/M1.03



KEY PLAN

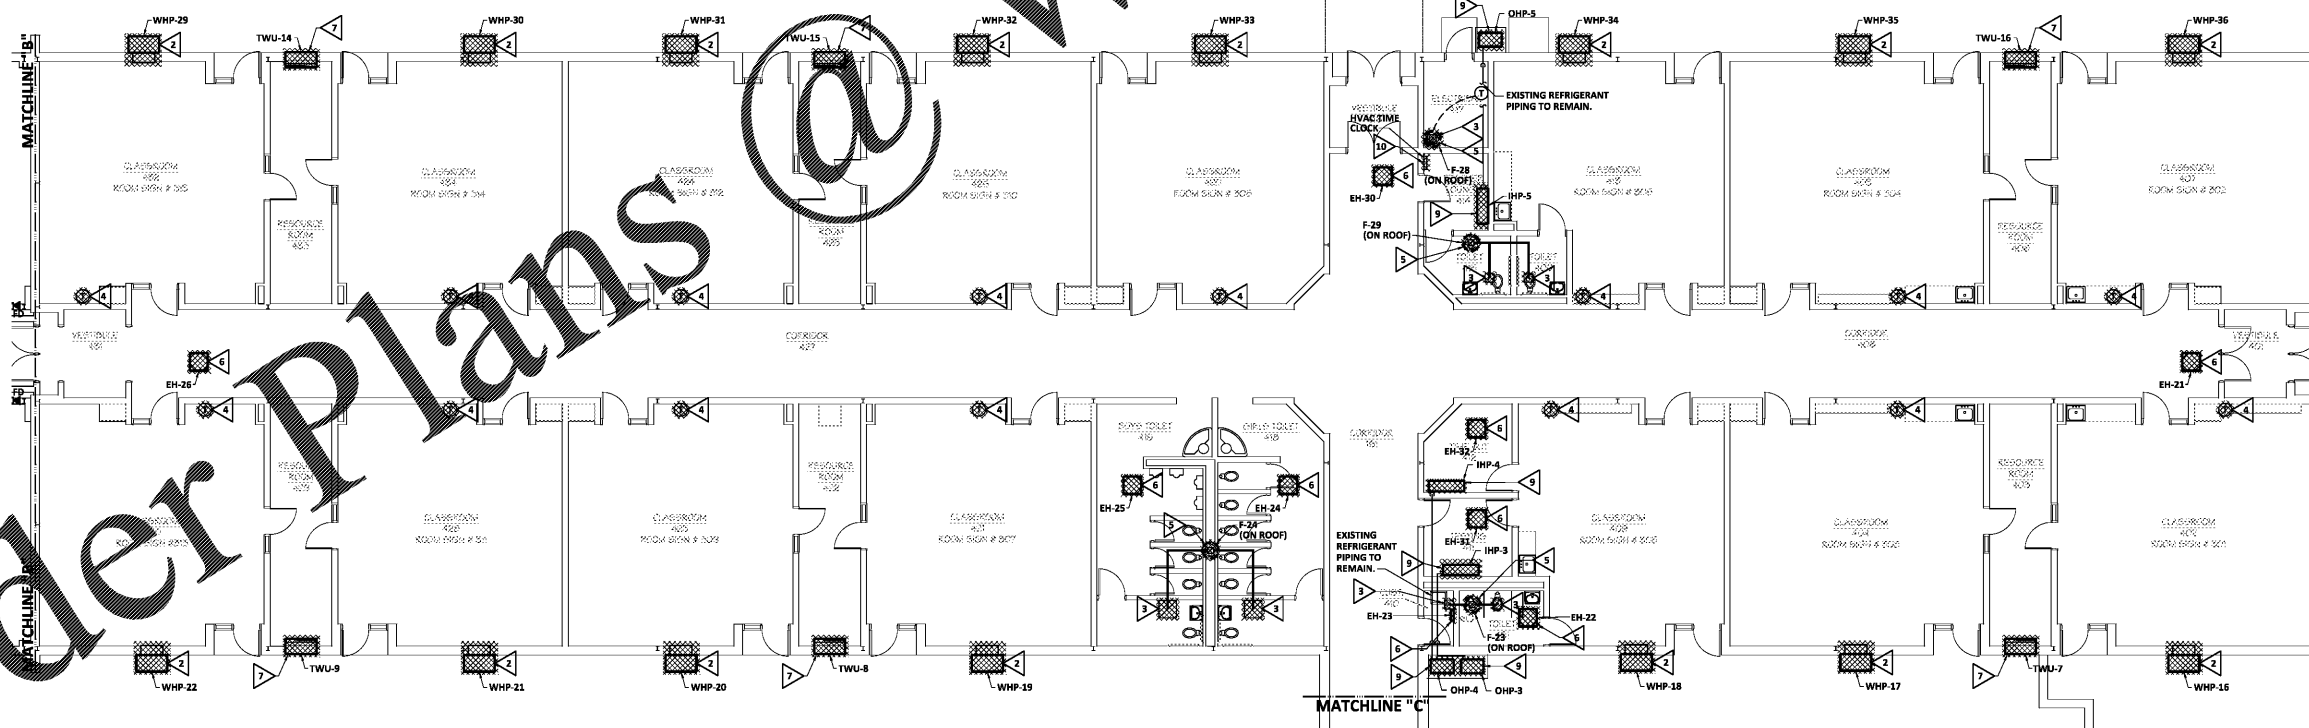


1 M1.03
 HVAC DEMOLITION PLAN - WING "D"
 SCALE: 1/8" = 1'-0"

DELOACH
 721 WALNUT STREET
 POST OFFICE BOX 6286
 MARIETTA, GEORGIA 30067
 phone: 478-742-4939
 fax: 478-742-5007
 www.gmpdevalach.com

ARCHITECTS
 PC

HVAC & LIGHTING REPLACEMENT AT
ALLATOONA ELEMENTARY
SCHOOL

4150 NEW HOPE CHURCH ROAD, ADWORTH, GA 30102
 FOR THE BARTOW COUNTY SCHOOL SYSTEM - DR. PHILLIP D. PAGE, SUPERINTENDENT
 CARTERSVILLE, GEORGIA

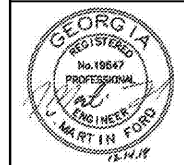


FRUITT, FORD & ASSOCIATES, INC.
 CONSULTING ENGINEERS
 100 IRVING STREET, SUITE 3A
 ALBANY, GEORGIA 31706
 478-288-7100 • FAX 478-288-7101

THESE DOCUMENTS, AS SHOWN, ARE THE PROPERTY OF THE ARCHITECT AND NO PART THEREOF MAY BE USED OR REPRODUCED IN ANY FORM WITHOUT WRITTEN PERMISSION.

NO.	REVISIONS	DATE

CONSTRUCTION DOCUMENTS

 HVAC PLAN
 SCALE: 1/8" = 1'-0"
 SHEET
M1.03
 12 OF 32
 FILE: 18.04
 DATE: 12/14/18



REFERENCE SCALE
 PLOT DATE: 12/14/18
 FILENAME: 18106M1
 PLOT SCALE: 1 = 96
 1/8

FRUITT, FORD & ASSOCIATES, INC.
 ALBANY, GA 31706

Order Plans @ www.edline.com