



**PRIDDY, FORD & ASSOCIATES, INC.**  
CONSULTING ENGINEERS  
100 IRONWOOD STREET, SUITE 300  
ALBANY, GEORGIA 31706  
478-536-1100 • FAX 478-536-1101

THESE DOCUMENTS,  
AS SERVICE, REMAIN THE  
PROPERTY OF THE  
ARCHITECT AND NO  
PART THEREOF MAY BE  
USED OR REPRODUCED  
IN ANY FORM WITHOUT  
WRITTEN PERMISSION

NO.	REVISIONS	DATE



CONSTRUCTION DOCUMENTS

HVAC PLAN

SCALE: 1/8" = 1'-0"

SHEET  
**M2.02**  
14 OF 32


FILE: 18.04  
DATE: 12/14/18

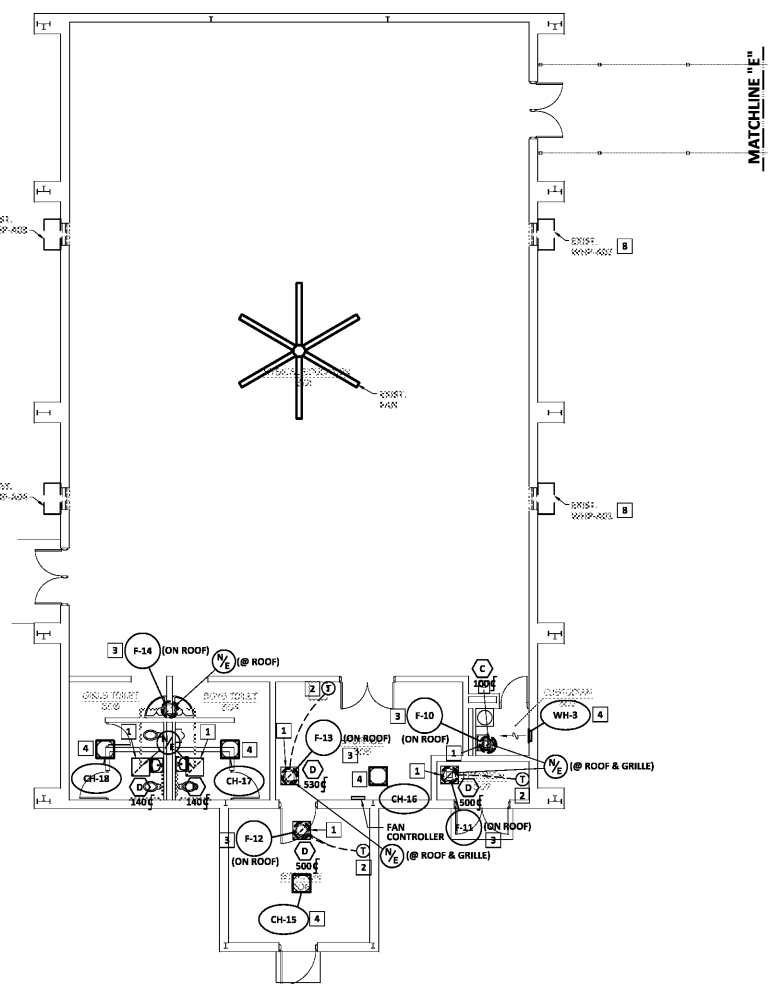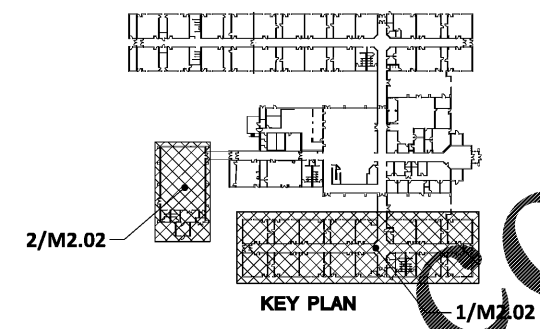


2 HVAC NEW WORK PLAN - WING "C"  
SCALE: 1/8" = 1'-0"

**KEY NOTES (THIS SHEET ONLY):**

- 1 PROVIDE NEW EXHAUST GRILLE IN EXISTING LOCATION.
- 2 PROVIDE NEW THERMOSTAT IN EXISTING LOCATION.
- 3 PROVIDE NEW ROOFTOP FAN AND ASSOCIATED ACCESSORIES IN EXISTING LOCATION. PROVIDE TRANSITION AS REQUIRED TO CONNECT TO EXISTING RISER.
- 4 PROVIDE NEW ELECTRIC HEATER IN EXISTING LOCATION.
- 5 PROVIDE NEW DUCTLESS SPLIT SYSTEM AND ASSOCIATED WIRING, CONTROLS AND ACCESSORIES. CONNECT TO EXISTING REFRIGERANT PIPING.
- 6 PROVIDE NEW WALL-MOUNT GAS UNIT AND ASSOCIATED AIR DEVICES, CONTROLS, WIRING, ION GENERATOR AND ACCESSORIES. CONNECT NEW GAS PIPING TO EXISTING GAS PIPING. FIELD VERIFY EXACT SIZE AND LOCATION. DISCHARGE CONDENSATE TO GRADE AND COORDINATE DRY WELL LOCATION WITH FIELD CONDITIONS. SEE ARCHITECTURAL.
- 7 PROVIDE NEW THRU-WALL UNIT AND ASSOCIATED WIRING, CONTROLS AND ACCESSORIES.
- 8 PROVIDE NEW CONTROLLER FOR EXISTING WALL MOUNT HEAT PUMP. SEE SPECIFICATIONS.
- 9 PURGE, CLEAN AND REUSE EXISTING REFRIGERANT PIPING WHERE POSSIBLE.

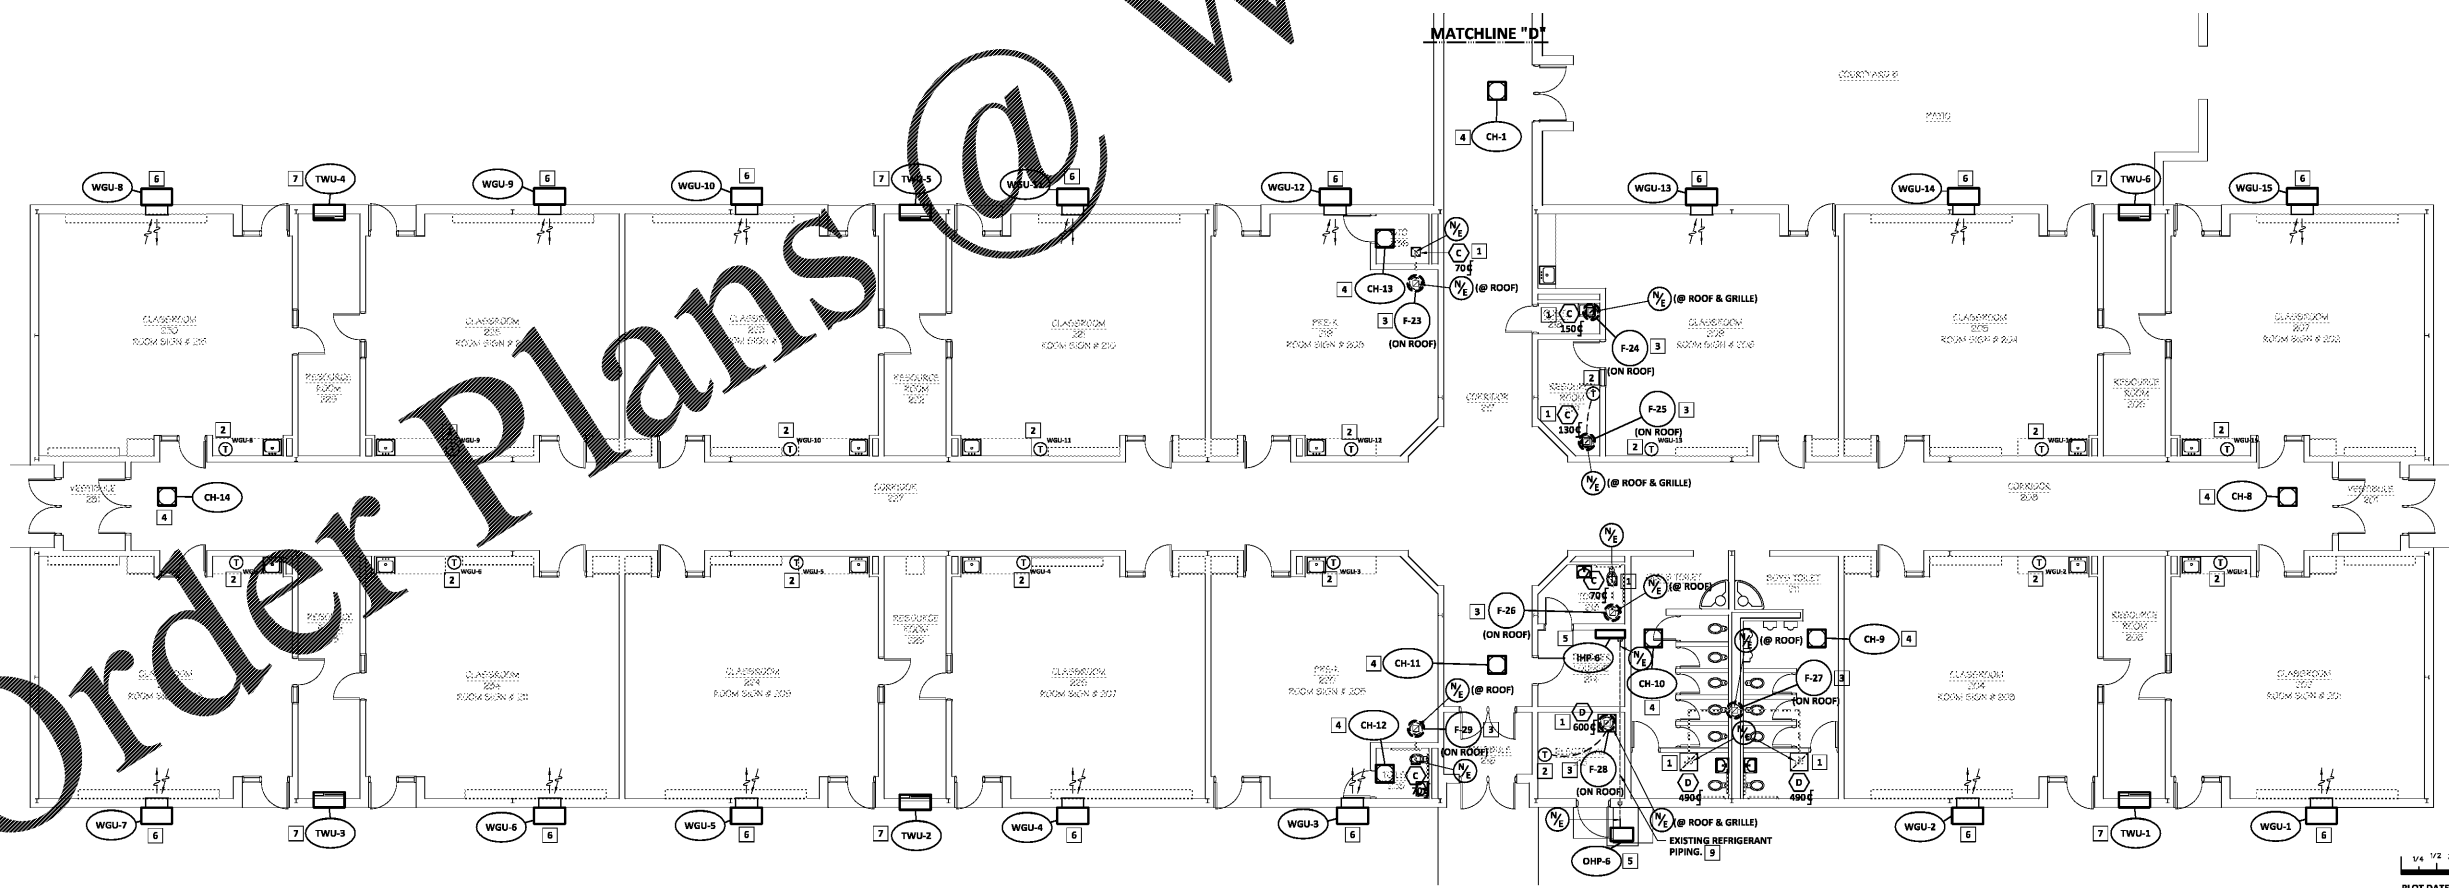

 1 HVAC NEW WORK PLAN - WING "B"  
SCALE: 1/8" = 1'-0"



PLOT DATE: 12/14/18  
FILENAME: 18106M2  
PLOT SCALE: 1 = 96  
1/8

PRIDDY, FORD & ASSOCIATES, INC.  
ALBANY, GA 31706

Order Plans @

WWW.LDILine.com