



2 M2.03 HVAC NEW WORK PLAN - WING "E"  
SCALE: 1/8" = 1'-0"

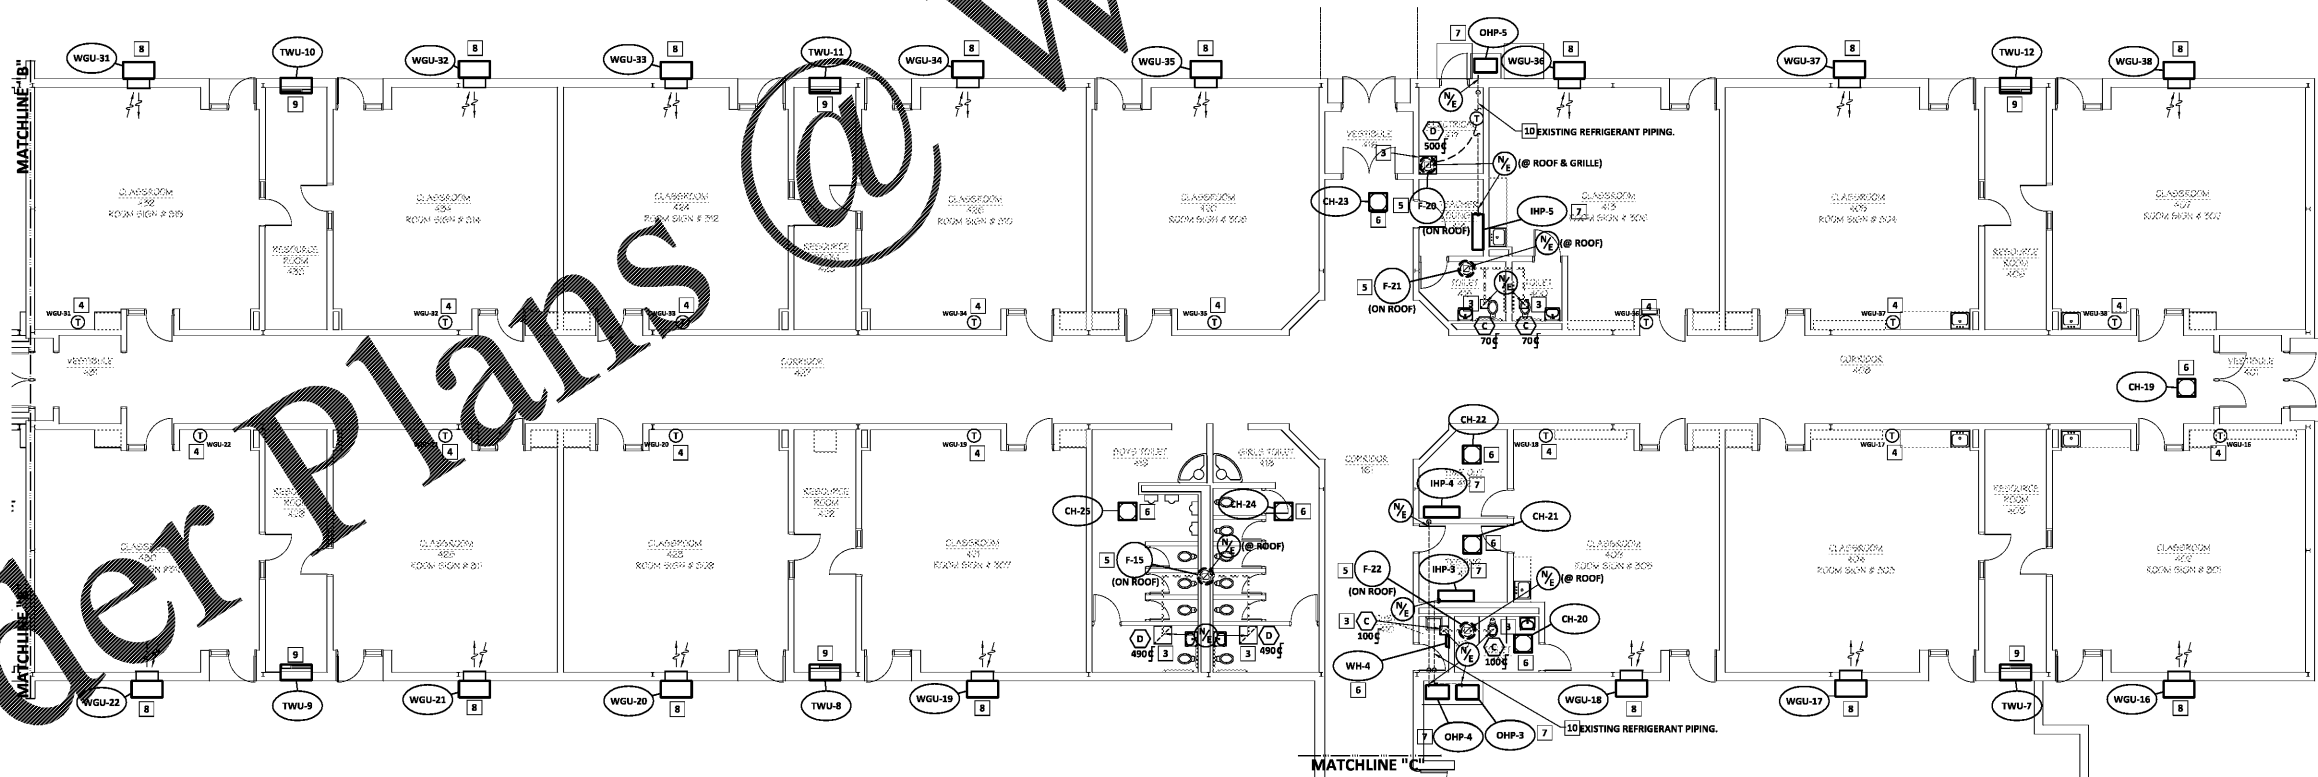

1 M2.03 HVAC NEW WORK PLAN - WING "D"  
SCALE: 1/8" = 1'-0"

- KEY NOTES (THIS SHEET ONLY):**
- 1 PROVIDE NEW SUPPLY DIFFUSER IN EXISTING LOCATION.
  - 2 PROVIDE NEW RETURN GRILLE IN EXISTING LOCATION.
  - 3 PROVIDE NEW EXHAUST GRILLE IN EXISTING LOCATION.
  - 4 PROVIDE NEW THERMOSTAT IN EXISTING LOCATION.
  - 5 PROVIDE NEW ROOFTOP FAN AND ASSOCIATED ACCESSORIES IN EXISTING LOCATION. PROVIDE TRANSITION AS REQUIRED TO CONNECT TO EXISTING RISER.
  - 6 PROVIDE NEW ELECTRIC HEATER IN EXISTING LOCATION.
  - 7 PROVIDE NEW DUCTLESS SPLIT SYSTEM AND ASSOCIATED WIRING, CONTROLS AND ACCESSORIES. CONNECT TO EXISTING REFRIGERANT PIPING.
  - 8 PROVIDE NEW WALL-MOUNT GAS UNIT AND ASSOCIATED AIR DEVICES, CONTROLS, WIRING AND ACCESSORIES. CONNECT NEW GAS PIPING TO EXISTING GAS PIPING. FIELD VERIFY EXACT SIZE AND LOCATION. DISCHARGE CONDENSATE TO GRADE AND COORDINATE DRY WELL LOCATION WITH FIELD CONDITIONS. SEE ARCHITECTURAL.
  - 9 PROVIDE NEW THRU-WALL UNIT AND ASSOCIATED WIRING, CONTROLS AND ACCESSORIES.
  - 10 PURGE, CLEAN AND REUSE EXISTING REFRIGERANT PIPING WHERE POSSIBLE.

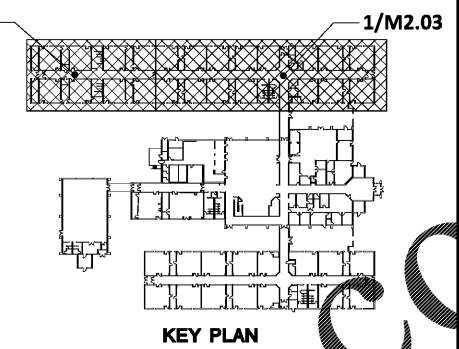

KEY PLAN

**DELOACH**  
721 WALNUT STREET  
POST OFFICE BOX 6206  
Macon, GEORGIA 31206  
phone: 478-742-4939  
fax: 478-742-5207  
www.deloach.com

**ARCHITECTS**  
PC

HVAC & LIGHTING REPLACEMENT AT  
**ALLATOONA ELEMENTARY SCHOOL**  
4150 NEW HOPE CHURCH ROAD, ACONORTH, GA 30102  
FOR THE BARTOW COUNTY SCHOOL SYSTEM - DR. PHILLIP D. PAGE, SUPERINTENDENT  
CARTERSVILLE, GEORGIA




**FRUIT, FORD & ASSOCIATES, INC.**  
CONSULTING ENGINEERS  
100 IRVING STREET, SUITE 300  
ALBUQUERQUE, GEORGIA 3001  
404.236.7400 • FAX 404.236.7401

THESE DOCUMENTS, AS SHOWN, ARE THE PROPERTY OF FRUIT, FORD & ASSOCIATES, INC. NO PART THEREOF MAY BE REPRODUCED OR USED IN ANY FORM WITHOUT WRITTEN PERMISSION.

DATE	REVISIONS

CONSTRUCTION DOCUMENTS

 HVAC PLAN  
SCALE: 1/8" = 1'-0"  
SHEET  
**M2.03**  
15 OF 32  
FILE: 18.04  
DATE: 12/14/18



PLOT DATE: 12/14/18  
FILENAME: 18106M2  
PLOT SCALE: 1 = 96  
1/8

FRUIT, FORD & ASSOCIATES, INC.  
ALBUQUERQUE, GEORGIA 3001

Order Plans @ WWW.LDLine.com