


GENERAL LIGHTING NEW NOTES:

- A. REMOVE EXISTING SWITCHES AND FACEPLATES. PROVIDE ALL NEW DEVICES AND FACEPLATES CONFORM WIRING TO MEET OPERATION SHOWN ON NEW WORK PLAN.
- B. REMOVE EXISTING EXIT SIGNS AND EGRESS LIGHT FIXTURES AND CONFORM WIRING TO MEET OPERATION SHOWN ON NEW WORK PLAN.
- C. LIGHT FIXTURES TO BE REPLACED IN AREAS SHOWN. REPLACE EXISTING LIGHT FIXTURES TO JUNCTION BOX FOR FIXTURES IN LAY-IN CEILING. PROVIDE ADDITIONAL RACEWAY AND CONDUCTORS AS REQUIRED FOR NEW OCCUPANCY LOADS. DIMMERS TO BE INSTALLED IN FIXTURES AND NEW DIMMERS IN CLASSROOMS.
- D. PROVIDE UNSWITCHED HOT TO NEW EGRESS FIXTURES FROM CIRCUIT BREAKERS IN THE AREA TO POWER INTEGRAL BATTERY BACKUP.


KEYED NOTES:

- 1. REPLACE SWITCH WITH 0-10V DIMMER, PROVIDE ADDITIONAL CONDUCTORS AS REQUIRED.

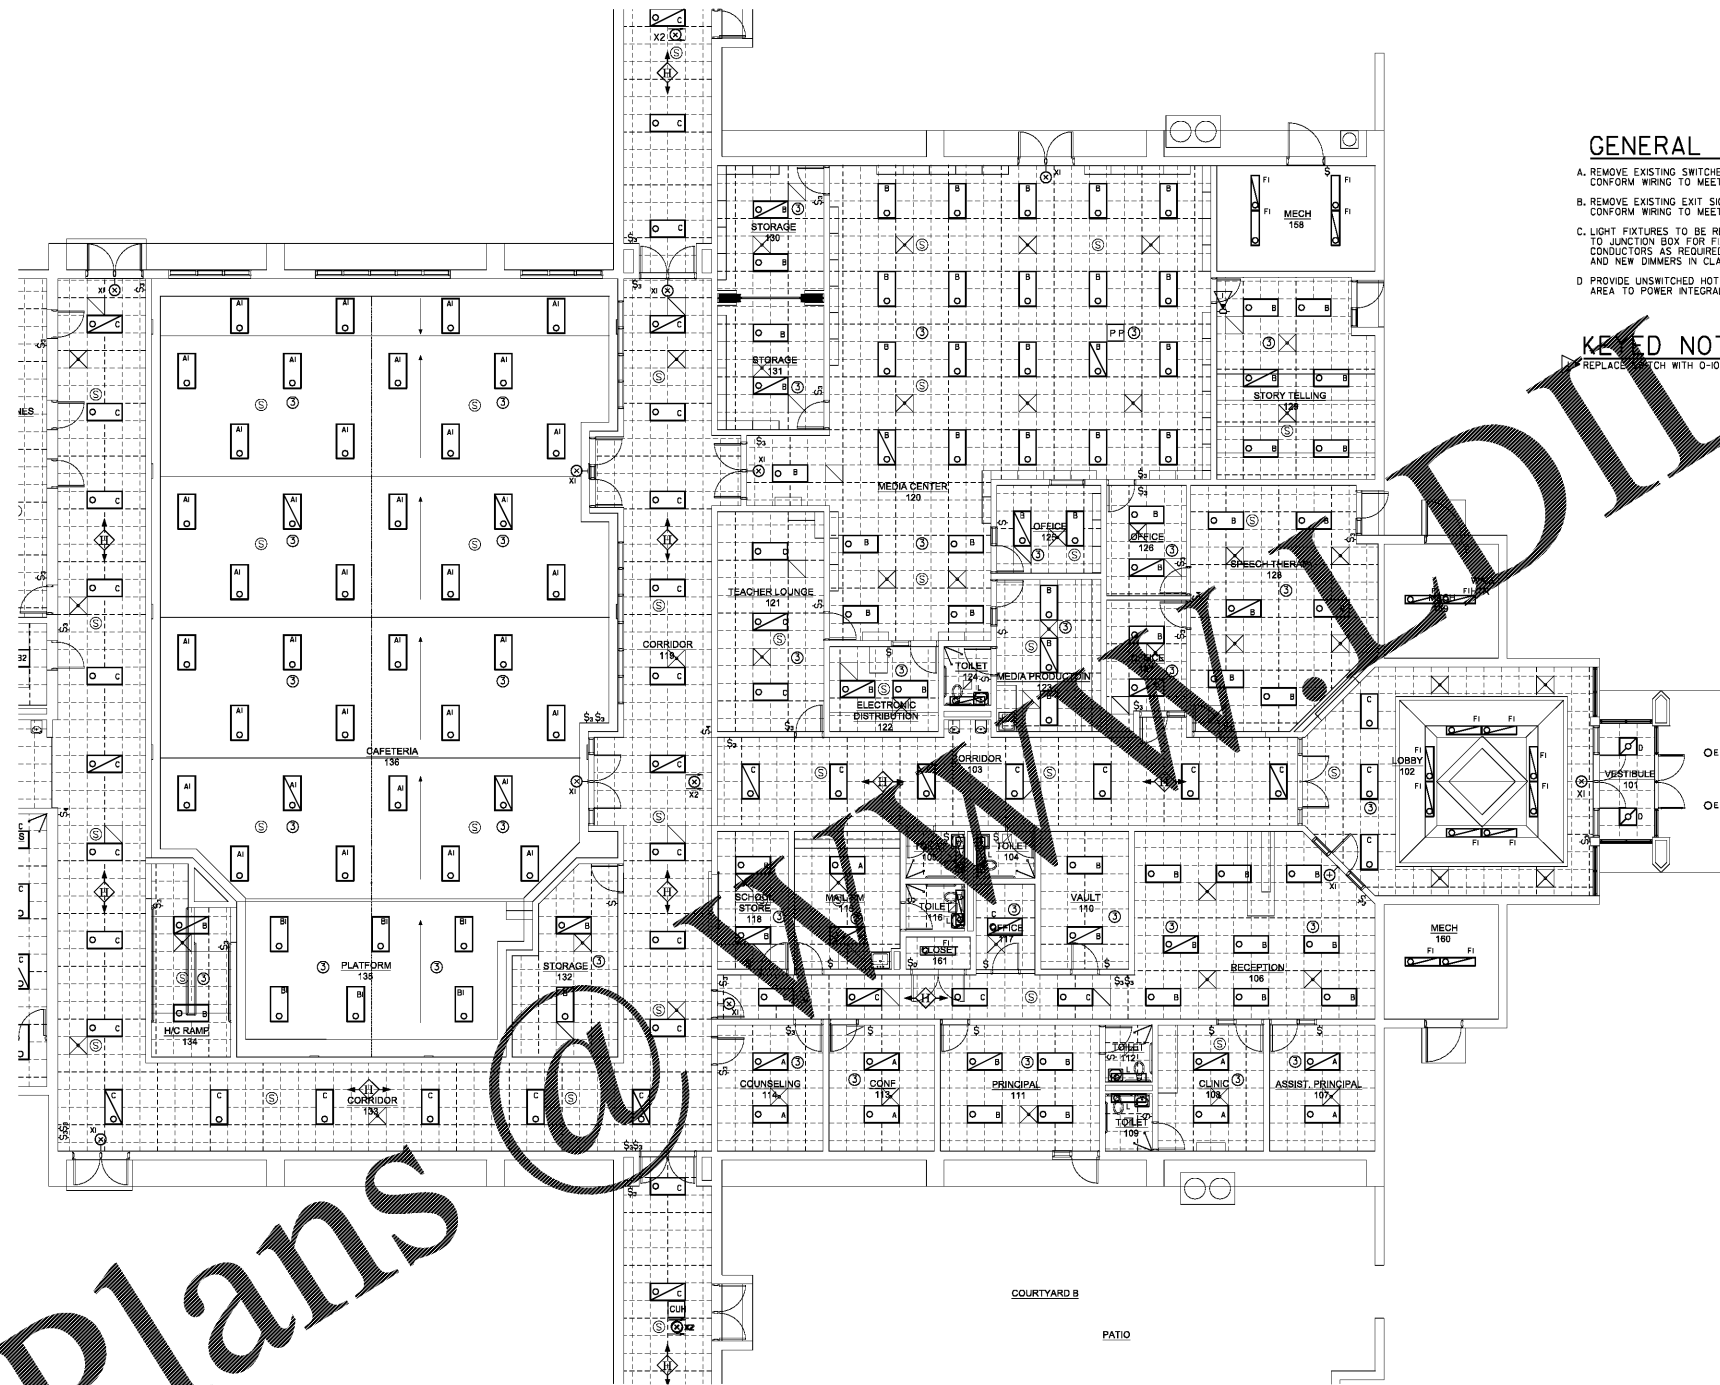

1 FLOOR PLAN WING A - LIGHTING

E2.1 SCALE: 1/8"=1'-0"

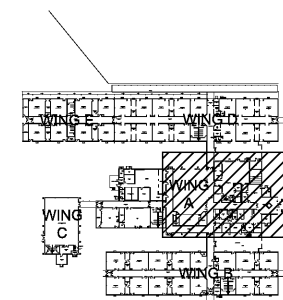

KEYPLAN



THESE DOCUMENTS, AS INSTRUMENTS OF SERVICE, REMAIN THE PROPERTY OF THE ARCHITECT AND NO PART THEREOF MAY BE USED OR REPRODUCED IN ANY FORM WITHOUT WRITTEN PERMISSION

NO.	REVISIONS	DATE

CONSTRUCTION DOCUMENTS

FLOOR PLAN WING A - LIGHTING

SHEET
E2.1
21 OF 32

FILE: 18.08
DATE: 12/14/18

Order Plans

WWW.DIPLINE.COM