

MECHANICAL POWER UNIT DATA NOTES (THIS SHEET ONLY)

N- NEW UNIT
 ES- EXISTING UNIT TO REMAIN AS-IS
 ER- EXISTING UNIT TO BE REMOVED AND NOT REPLACED
 RE- EXISTING UNIT TO BE REMOVED AND REPLACED
 EB- EXISTING BREAKER TO BE REUSED
 EC- EXISTING BREAKER TO BE REUSED
 EW- EXISTING WIRE TO BE REUSED
 ED- EXISTING DISCONNECT TO BE REUSED
 ET- EXISTING THERMOSTAT TO BE REUSED
 RB- EXISTING BREAKER TO BE REPLACED
 RC- EXISTING CONDUIT TO BE REPLACED
 RW- EXISTING WIRE TO BE REPLACED
 RD- EXISTING DISCONNECT TO BE REPLACED
 RT- EXISTING THERMOSTAT TO BE REPLACED
 NB- TOTALLY NEW BREAKER
 NC- TOTALLY NEW CONDUIT
 NW- TOTALLY NEW WIRE
 ND- TOTALLY NEW DISCONNECT
 NT- TOTALLY NEW THERMOSTAT
 SO- PROVIDE DUCT SMOKE DETECTION SUPPLY DUCT

NOTES:
 1. UTILIZE ONE POLE OF EXISTING BREAKER, AND UTILIZE EXISTING CONDUCTORS AS REQUIRED PER 2017 NEC.

HVAC & LIGHTING REPLACEMENT AT
ALLATOONA ELEMENTARY SCHOOL
 4150 NEW HOPE CHURCH ROAD
 ACWORTH, GEORGIA 30102
 FOR THE BARTOW COUNTY SCHOOL SYSTEM, DR. PHILLIP PAGE, SUPERINTENDENT
 CARTERSVILLE, GEORGIA



THESE DOCUMENTS, AS INSTRUMENTS OF SERVICE, REMAIN THE PROPERTY OF ELECTRICAL DESIGN CONSULTANTS, INC. PART THEREOF MAY BE USED OR REPRODUCED IN ANY FORM WITHOUT WRITTEN PERMISSION


NO.	REVISIONS	DATE

CONSTRUCTION DOCUMENTS


FLOOR PLAN WING A - HVAC

SHEET
E3.1
 26 OF 32

FILE: 18.08
 DATE: 12/14/18

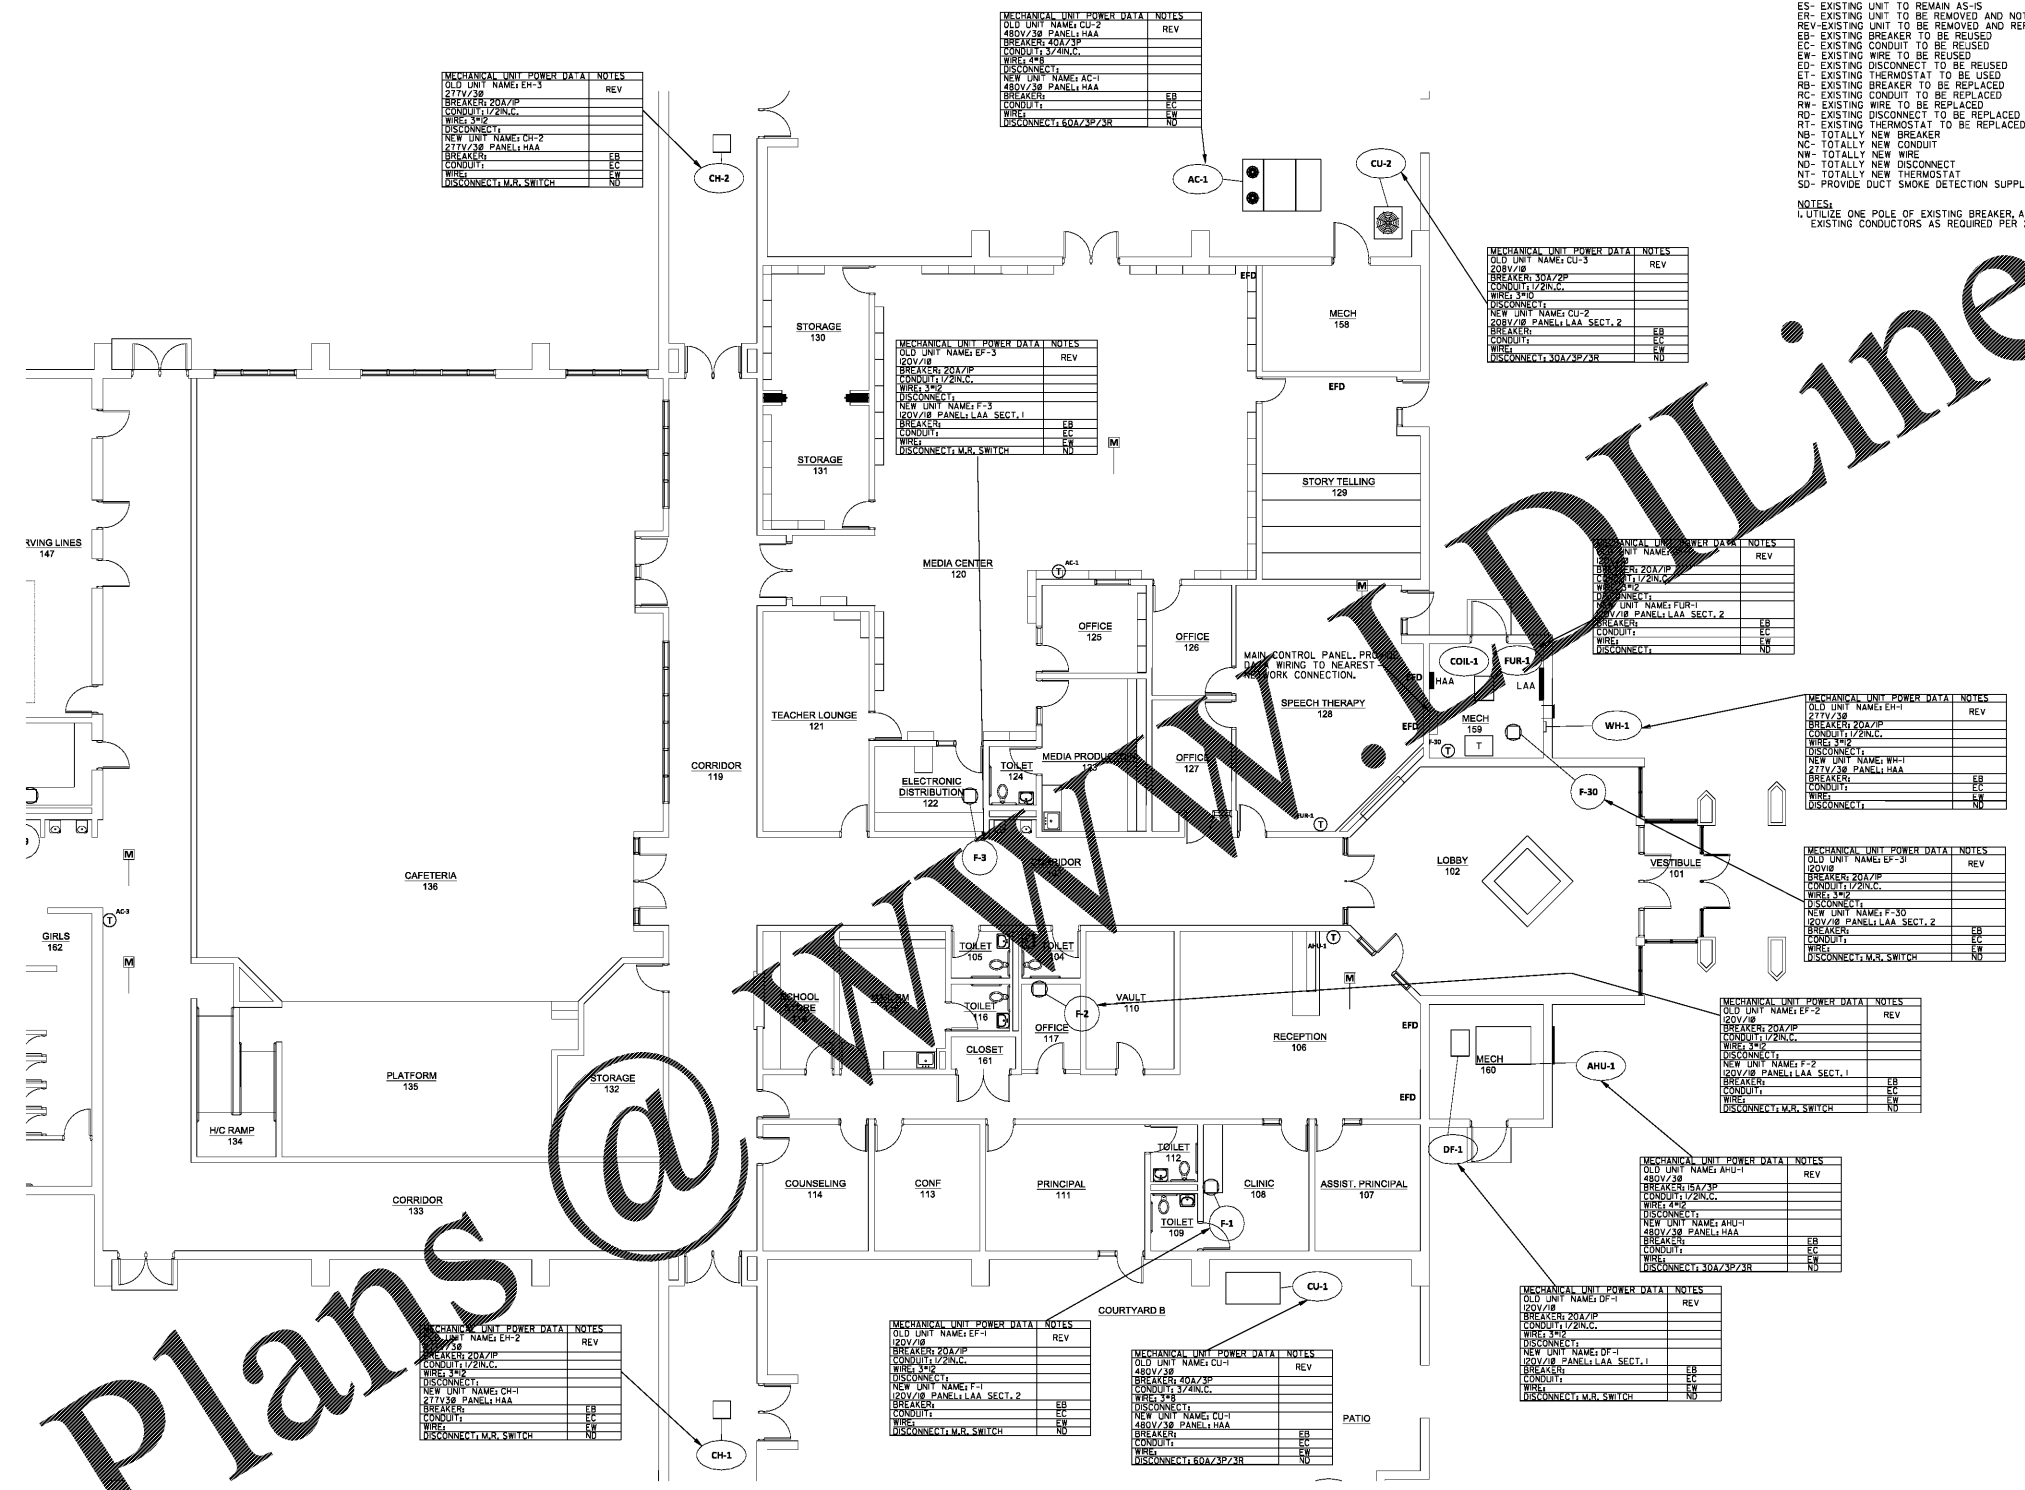

1 FLOOR PLAN WING A - HVAC
 E3.1 SCALE: 1/8"=1'-0"

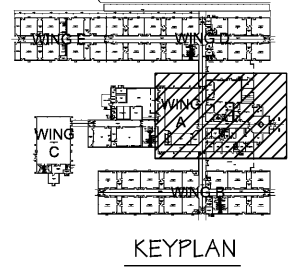

Order Plans @